
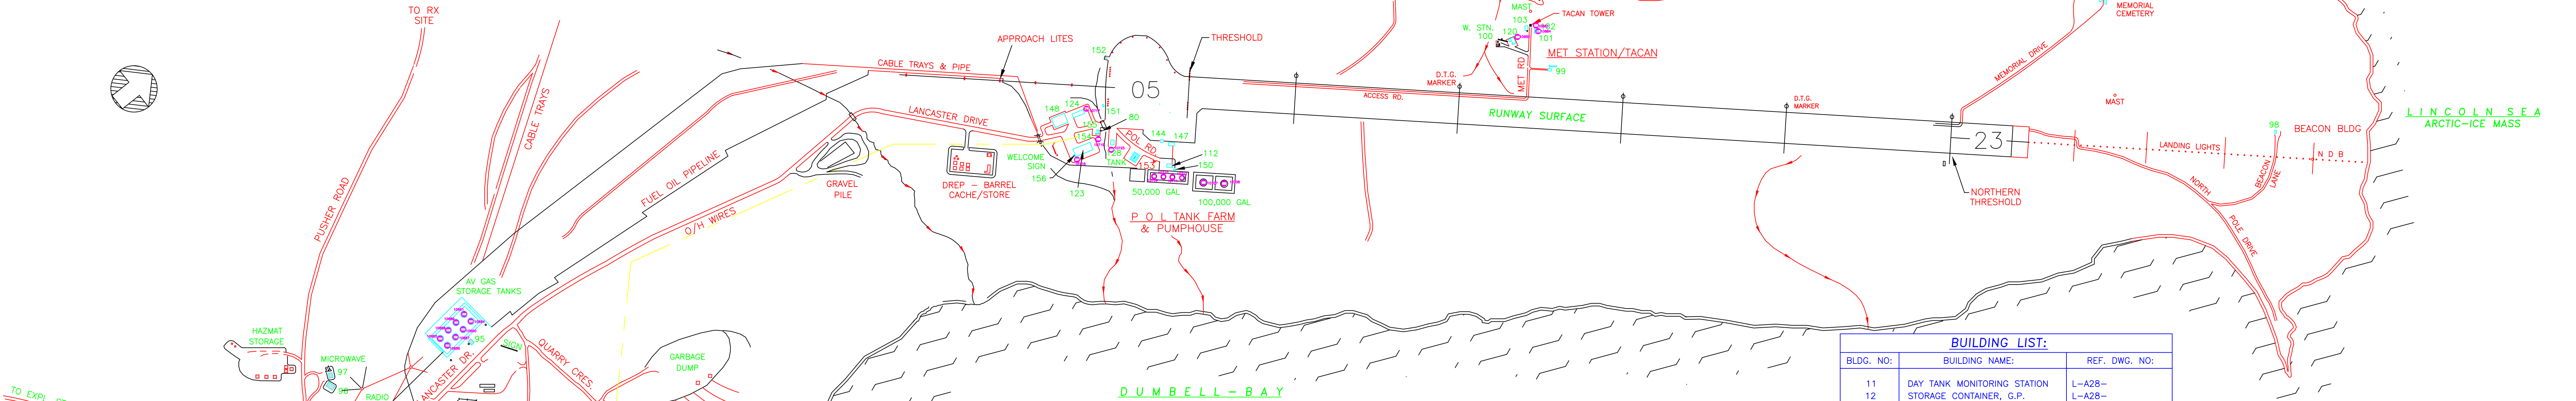
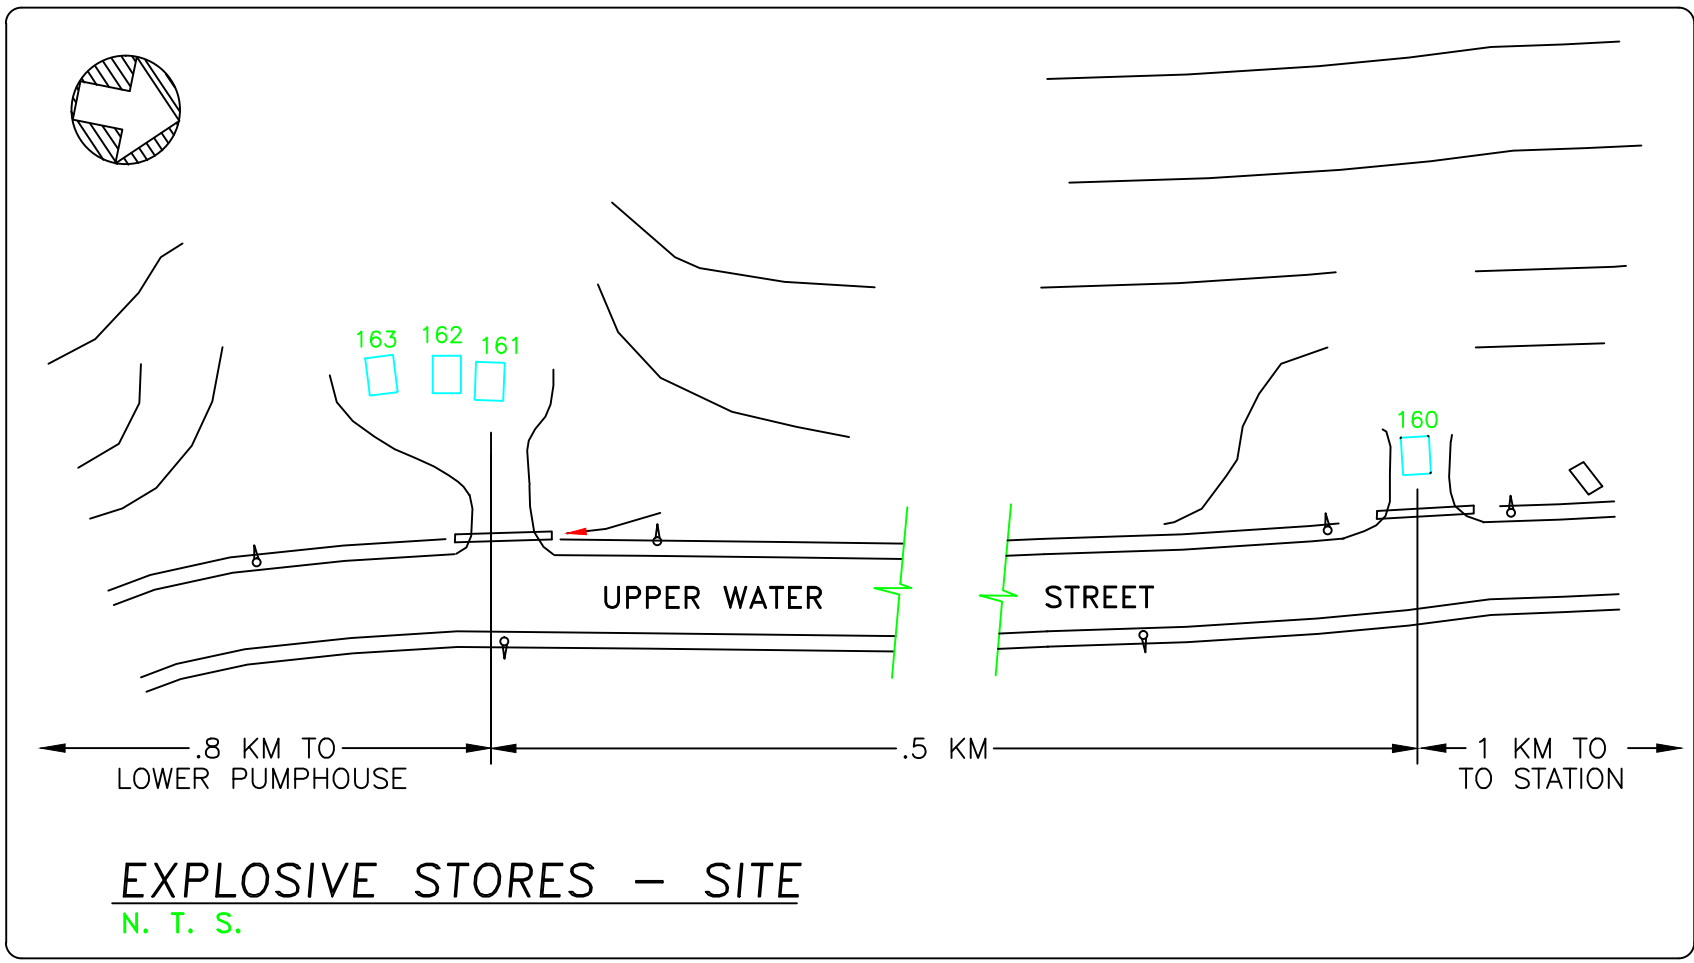
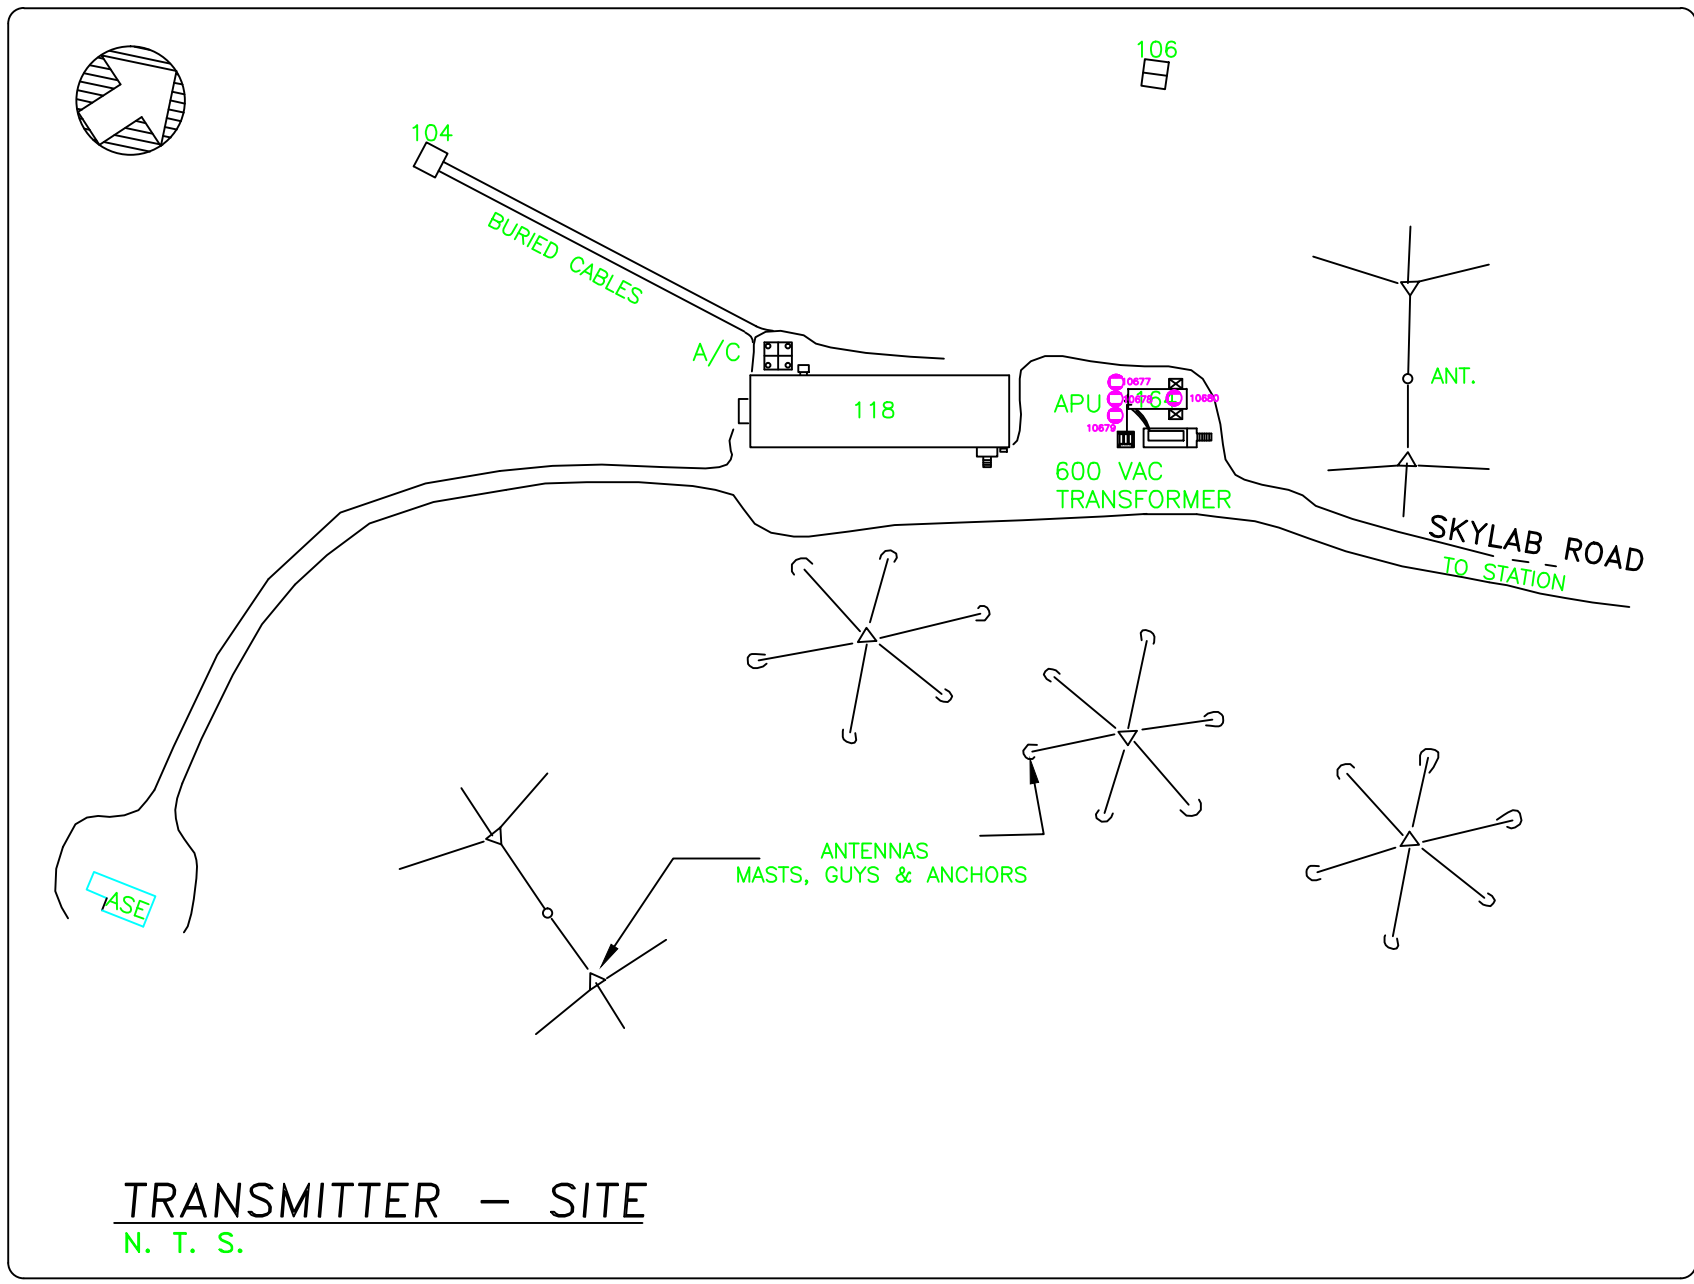
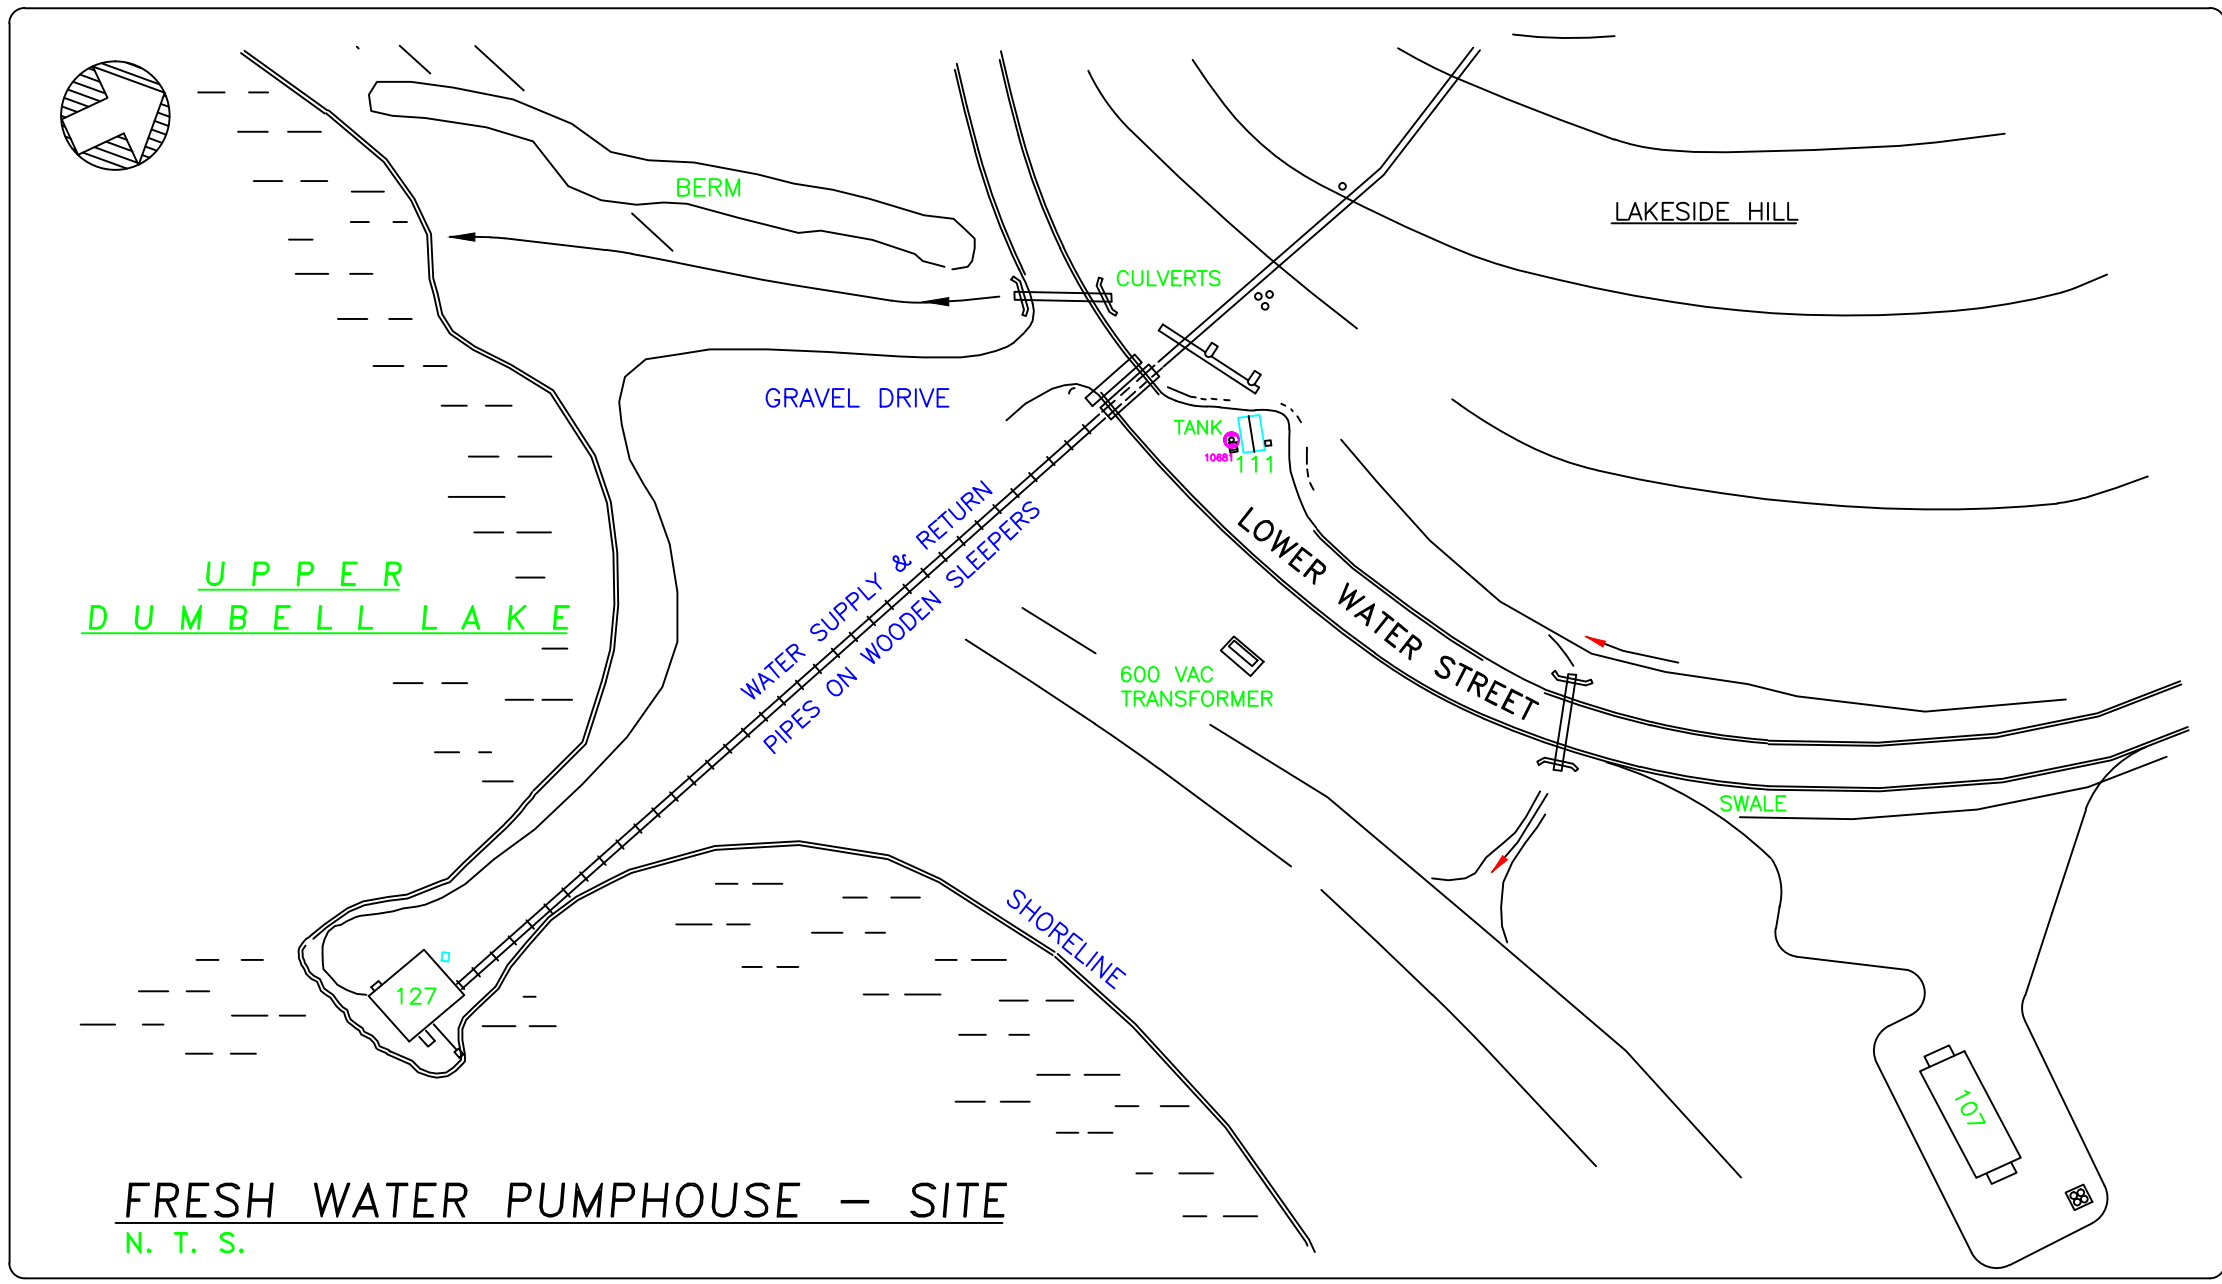


WING CONSTRUCTION ENGINEERING SQUADRON
8 WING TRENTON ONTARIO

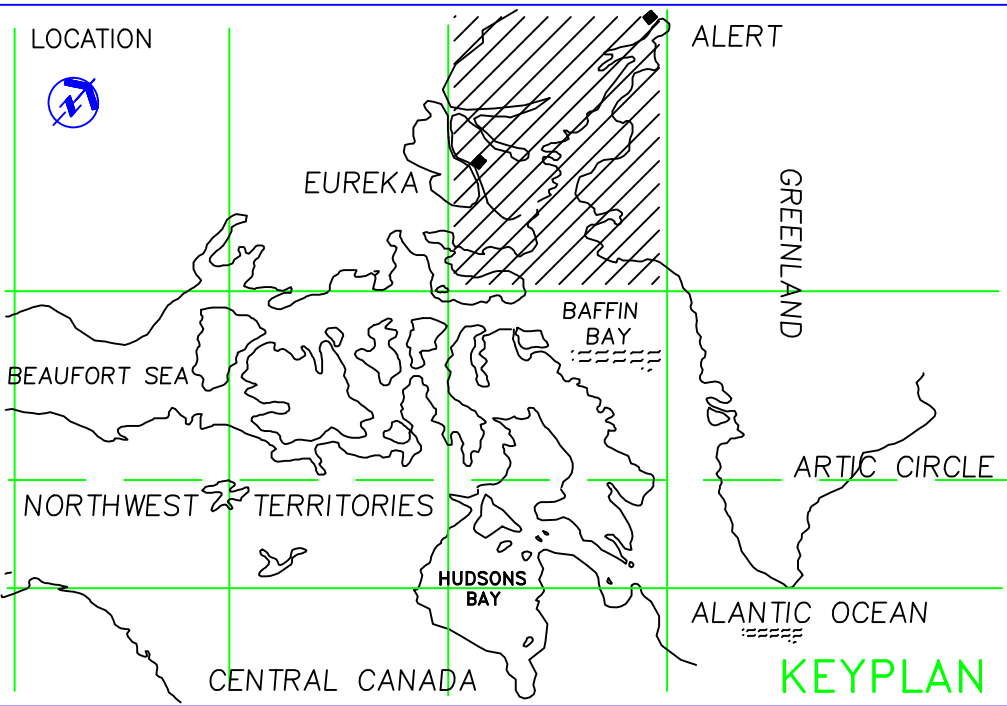

BUILDING LIST:		
BLDG. NO:	BUILDING NAME:	REF. DWG. NO:
11	DAY TANK MONITORING STATION	L-A28-
12	STORAGE CONTAINER, G.P.	L-A28-
13	MCKENNA BUILDING	
14	FUEL DISPENSING HOSE SHED	
15	DAY TANK - PUMP HOUSE	
16	TRANSPORT STORAGE BLDG.	
17	MAINTENANCE/TRANSPORT	
18	ICE SHELF STORAGE BLDG.	
19	TRANSPORT/MAINT. OFFICE	
20	GE COLD STORAGE BLDG.	
21	ICEU - STORAGE (OP HUT)	
29	INCINERATOR/OXIDIZER FACILITY	
35	ELECT. SPLICE HUT	
39	GYM & BOWLING ALLEY	
40	CURLING RINK	
41	STORAGE TRAILER	
60	C-SPAN (OLD 20 LINE)	
61	C-SPAN, PIPE STORAGE	
65	C-SPAN	
80	ALPC RESISTOR SHED	
90	FLAMMABLE STORAGE	
95	POL MONITORING SHACK	
96	SOLAR ENERGY SHACK	
97	TOWER BLDG	
98	RUNWAY BEACON BLDG.	
99	QUAD RADAR SHACK	
100	AUTOMATIC WEATHER STATION	
101	TACAN APU	
102	TACAN GR-516 GEAR, CONTAINER	
103	GE ELECT. SHOP COLD STORAGE	
105	REMOTE TX - PUSHER BLDG.	
106	BULK STORAGE BLDG.	
107	STORAGE - CACHE	
108	CABLE HUT (WEST)	
109	CABLE HUT (EAST)	
110	MAINT. SECTION - KIMONO HUT	
111	APU - LOWER PUMPHOUSE	
112	POL - PUMPHOUSE	
113	VEHICLE COLD STORAGE	
114	WATER TREATMENT PLANT	
115	QUARTERS - CHIMO	
116	QUARTERS - LADNER	
117	QUARTERS - WHITEHORSE	
118	TX SITE BLDG.	
119	OPERATIONS BLDG.	
119A	OPS CONTAINER	
120	MET BLDG.	
121	LAKE WATER PUMPHOUSE (LOWER)	
122	SPLICE HUT	
123	BATTERY STORAGE	
124	TRAFFIC BLDG. - HILTON	
125	HAPS BLDG.	
125 A B	KITCHEN STORAGE CONTAINERS	
127	COMP GAS & MAINT. STORAGE	
128	AIRPORT GARAGE	
129	TRANSPORT POL STORE	
129 A B	COMPRESSED GAS STORAGE	
130	WATER TREATMENT PLANT	
131	MAIN SUPPLY WAREHOUSE	
132	WATER TREATMENT PLANT	
134	LINE TROOP GARAGE	
136	PCB STORAGE	
137	ELECT. DIST. AT DOE SITE	
139	COMPACTOR/SHREDDER BLDG	
140	MAIN CE/FIREHALL BLDG.	
140 A & B	CE. STORAGE CONTAINERS	
144	HOSE/CHOCK SHED	
145	MAIN POWER PLANT	
146	STANDBY POWER PLANT	
147	FUEL HYDRANT BLDG.	
148	DREP BLDG.	
150	MCC SHACK FOR PUMP HOUSE	
151	AIRFIELD LIGHTING SPLICE SHACK	
152	AIRCRAFT POWER PLUG-IN SHACK	
153	LEVEL CONTROL - POL FARM	
154	APU FOR RUNWAY LIGHTING	
155	CONTROLS FOR RUNWAY LIGHTS	

BLDG. NUMBERS: CONT'D.		
156	REFRIGERATED CONTAINER	
157	ROCK CRUSHER BLDG.	
158	POWER PLANT - CRUSHER	
160-163	EXPOSIVE STORAGE SHACK	
164	APU - TX SITE	L-A28-
165	OUTHOUSE (OLD DOE SITE)	L-A28-

DWG. NOTES:
1.-THIS DRAWING BASED ON ICEU-DRAWING NUMBERS L-A28-842A-104 & 105, 106. DATED 02/07/1986
2.-THIS DRAWING IS METRIC UNITS.
3.- "AES" REFERS TO "ATMOSPHERIC & ENVIRONMENT SERVICES BY DOE"

DO NOT SCALE DRAWING

3	08/99	GENERAL REVISION - SITE VISIT	S.G.S.
2	08/98	GENERAL REVISION - SITE VISIT	S.G.S.
1	01/97	GENERAL REVISION-50 SERIES BLDGS REMOVED	S.G.S.
NO.	DATE	REVISION	REVISION

SCALE-ÉCHELLE 1:5000

PROJECT-PROJET SITE RECORD DRAWING

C.F.S. ALERT
ALERT, NUNAVUT
8-WING, CFB TRENTON - SATELLITE

TRADE-MÉTIER	SITING	DATE
		22-08-99

GENERAL - SITE PLAN

PRODUCTION	CONCURRENCE-ASSENTIMENT	
DESIGNED ETUDIE	USERS GROUP:	MAJ. D. CAMERON SCO
DRAWN DESSINE	S.G.S.	M.W.O. McCLYMONT SECTION HD:
CHECKED VÉRIFIÉ	F. L.	S. G. SANSOME CADD/GIS SUPPLY:
COORDINATION	APPROVED - APPROUVÉ	SGT. E. TRENHOLM FIRE CHIEF
		MWO, P. GENDRON SCEO/SWO - MWO G. GENDRON

DWG.NO.-DESSIN NO. L-A28-8401/1-114