
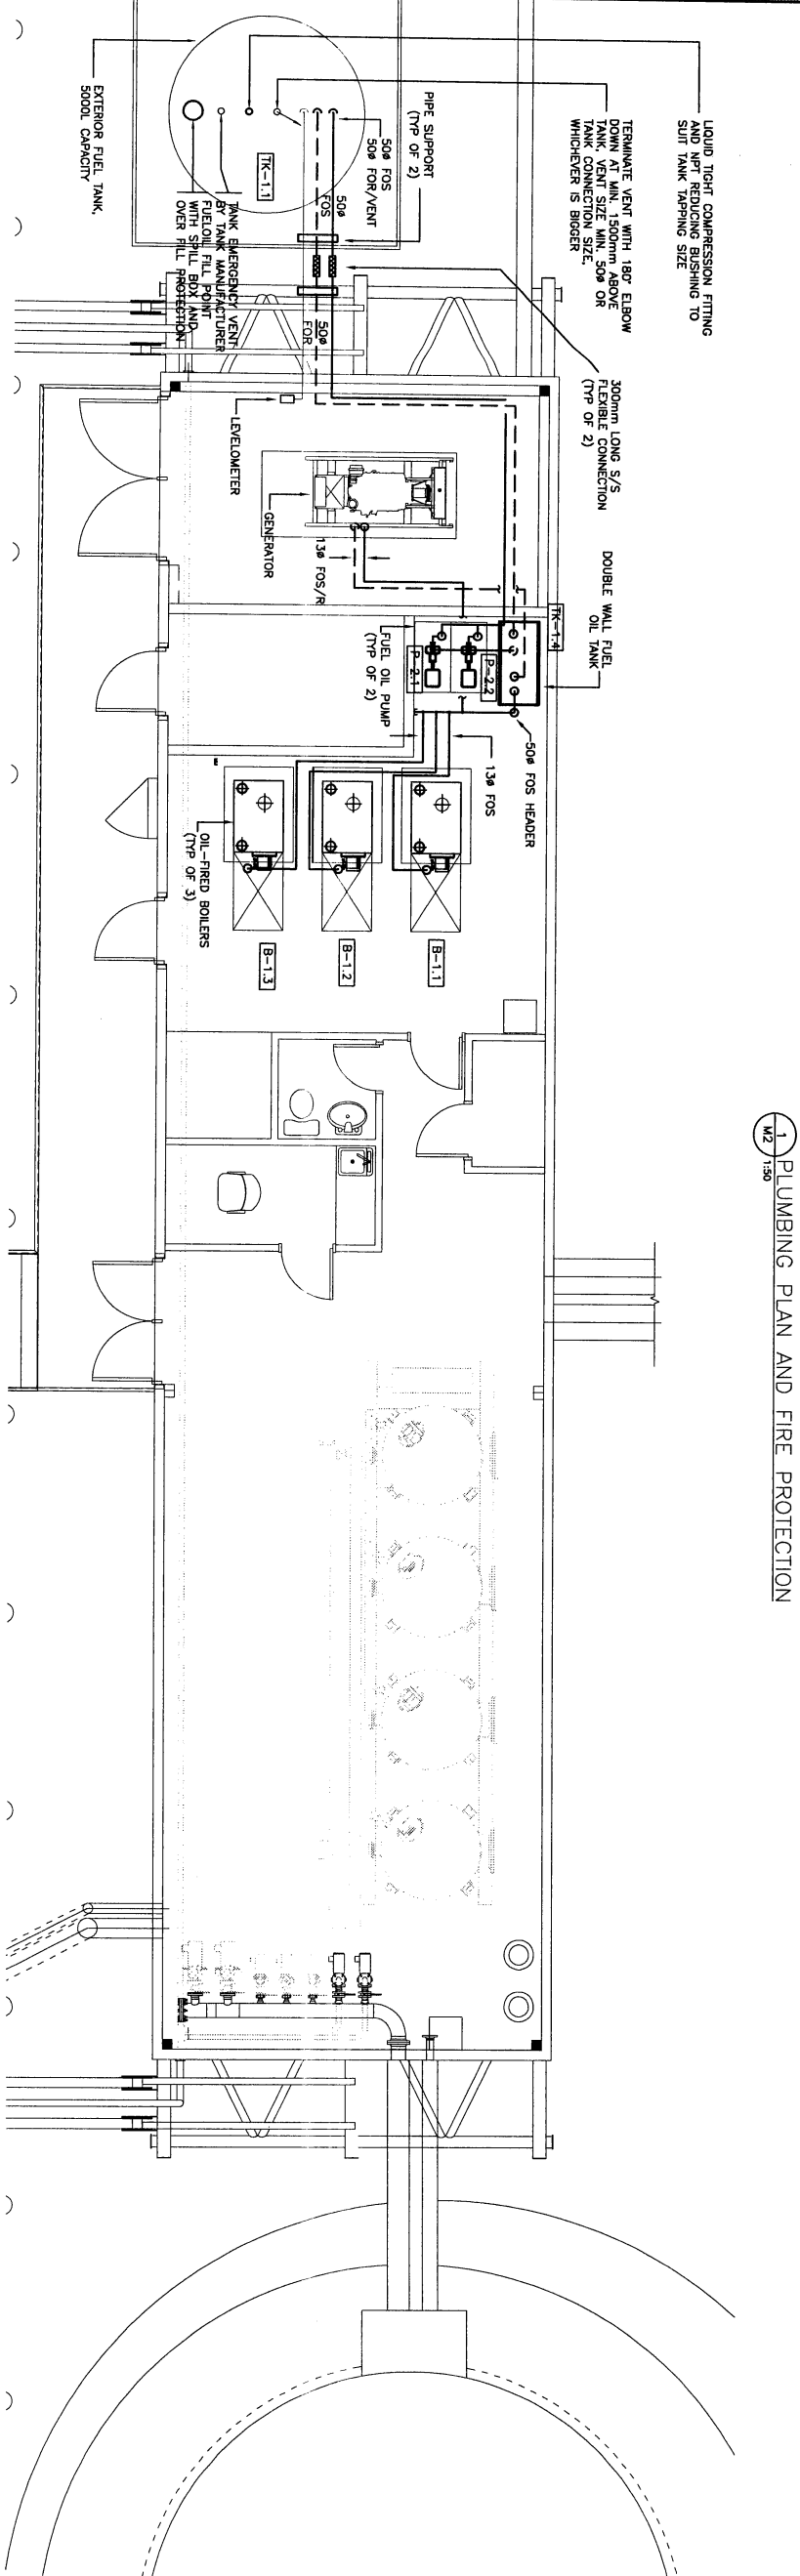
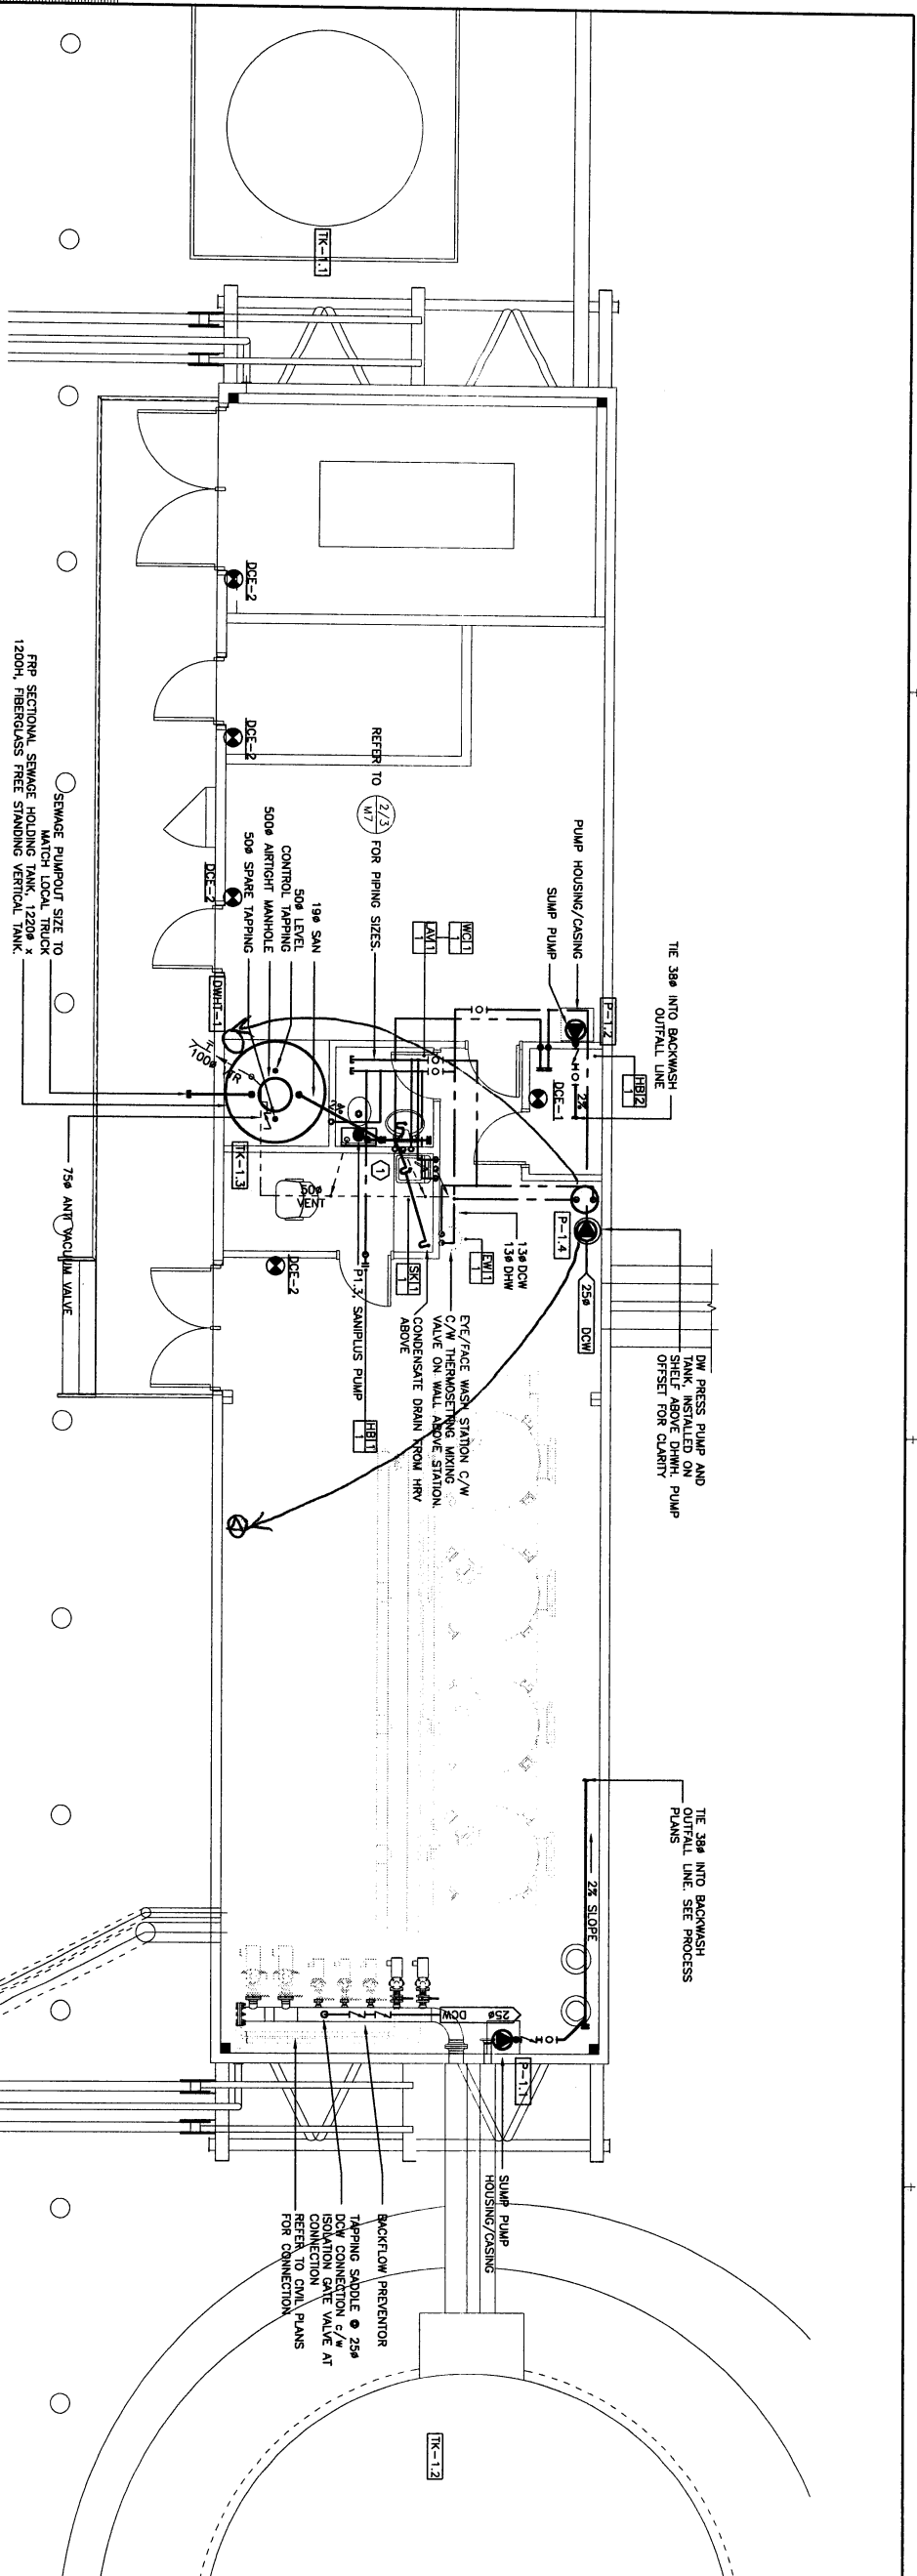



NOTE:
1. REFER TO DETAILS 2 AND 3 ON DRAWING M7 FOR PLUMBING LINES AND DETAILS.
2. REFER TO DETAILS 1 ON DRAWING M7 FOR PIPE SIZES AND DETAILS.

NO.	REVISION DESCRIPTION	DATE SUBMITTED
1	ISSUED FOR CONSTRUCTION	2011/08/19
2	ISSUED FOR TENDER	2011/03/29
3	REVISION DESCRIPTION	DATE SUBMITTED

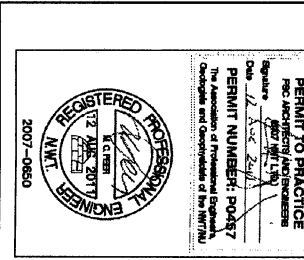


FSC
ARCHITECTS & ENGINEERS
4310 - 53RD STREET, Q.3, BOX 17772
YELLOWKNIFE, NT, X1A 2P4, CANADA
TEL: (867) 920-2982 FAX: (867) 920-4319
PROJECT TITLE: NEW WATER PUMP/CHLORINATION FACILITY AND INTAKE STRUCTURE
LOCATION: BAKER LAKE, NU
PLUMBING, FIRE PROTECTION & FUEL OIL PIPING PLANS
DRAWN BY: RTA/DK
CHECKED BY: AS SHOWN
DATE: 07-30-2013
PROJECT NO: 2007-0650
SCALE: M2


[Signature]

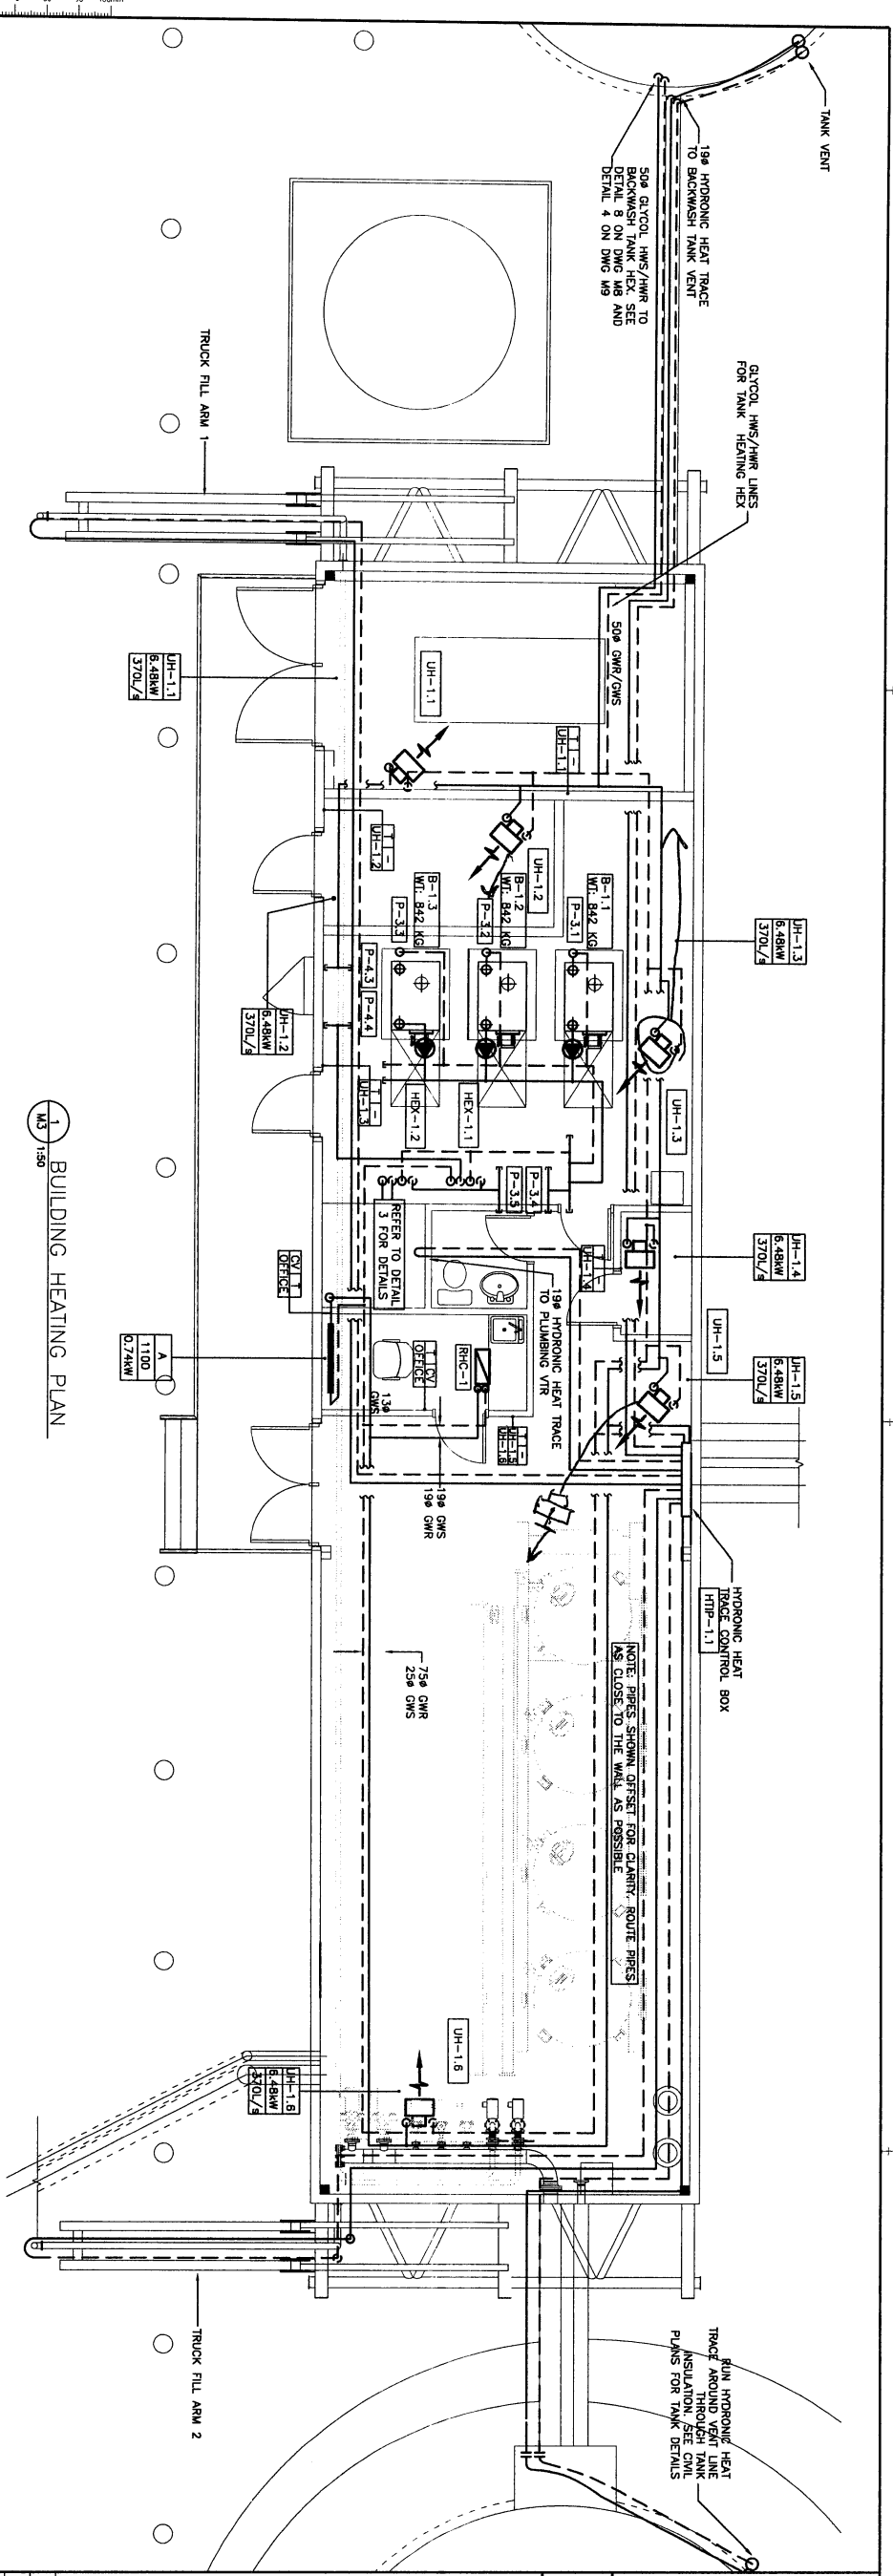

1 BUILDING HEATING PLAN
M3 150

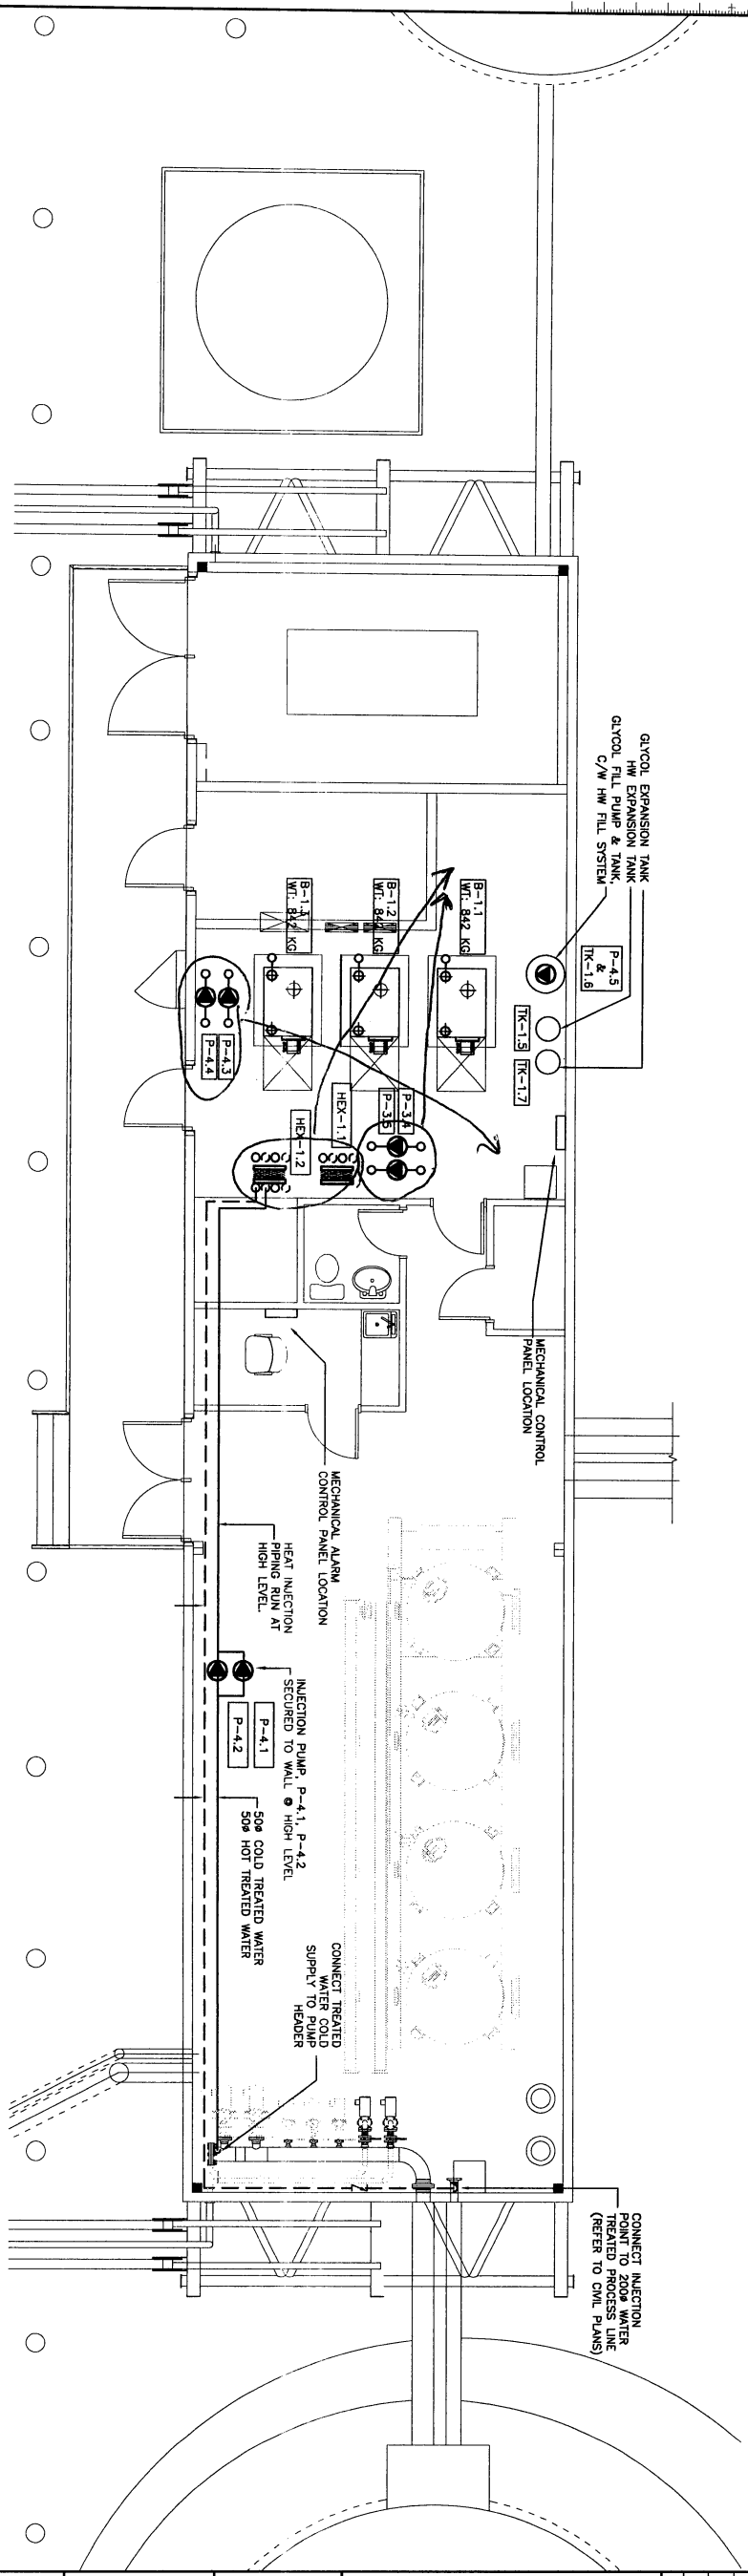


2 MECHANICAL ROOM LOWER LEVEL & PROCESS CONNECTION
M3 150

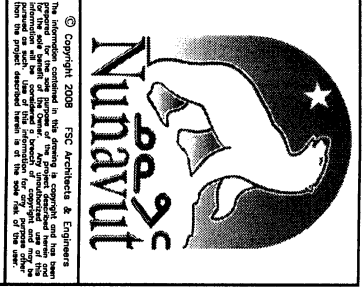

NOTE:
1. SECURE HYDRONIC HEAT TRACE IN POSITION.
2. REFER TO SCHEMATIC ON DWGS M3 AND M6 FOR LINE SIZES


NO.	REVISION DESCRIPTION	DATE ISSUED
1	ISSUED FOR CONSTRUCTION	2011/08/19
2	ISSUED FOR TENDER	2011/03/29

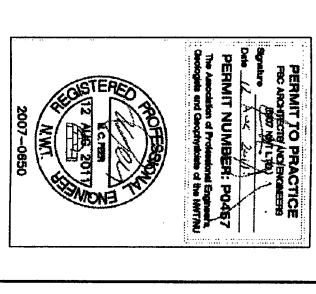


FSC
ARCHITECTS & ENGINEERS
100-10000 30th STREET, S.W. UNIT 100
VANCOUVER, BC V6V 2G9
TEL: (604) 271-9200 FAX: (604) 271-9201

NEW WATER PUMP/CHLORINATION FACILITY AND INTAKE STRUCTURE
BAKER LAKE, NU
HEATING PLAN
RTA/DK AS SHOWN
MP 07-3023
2007-0650
M3

[Signature]

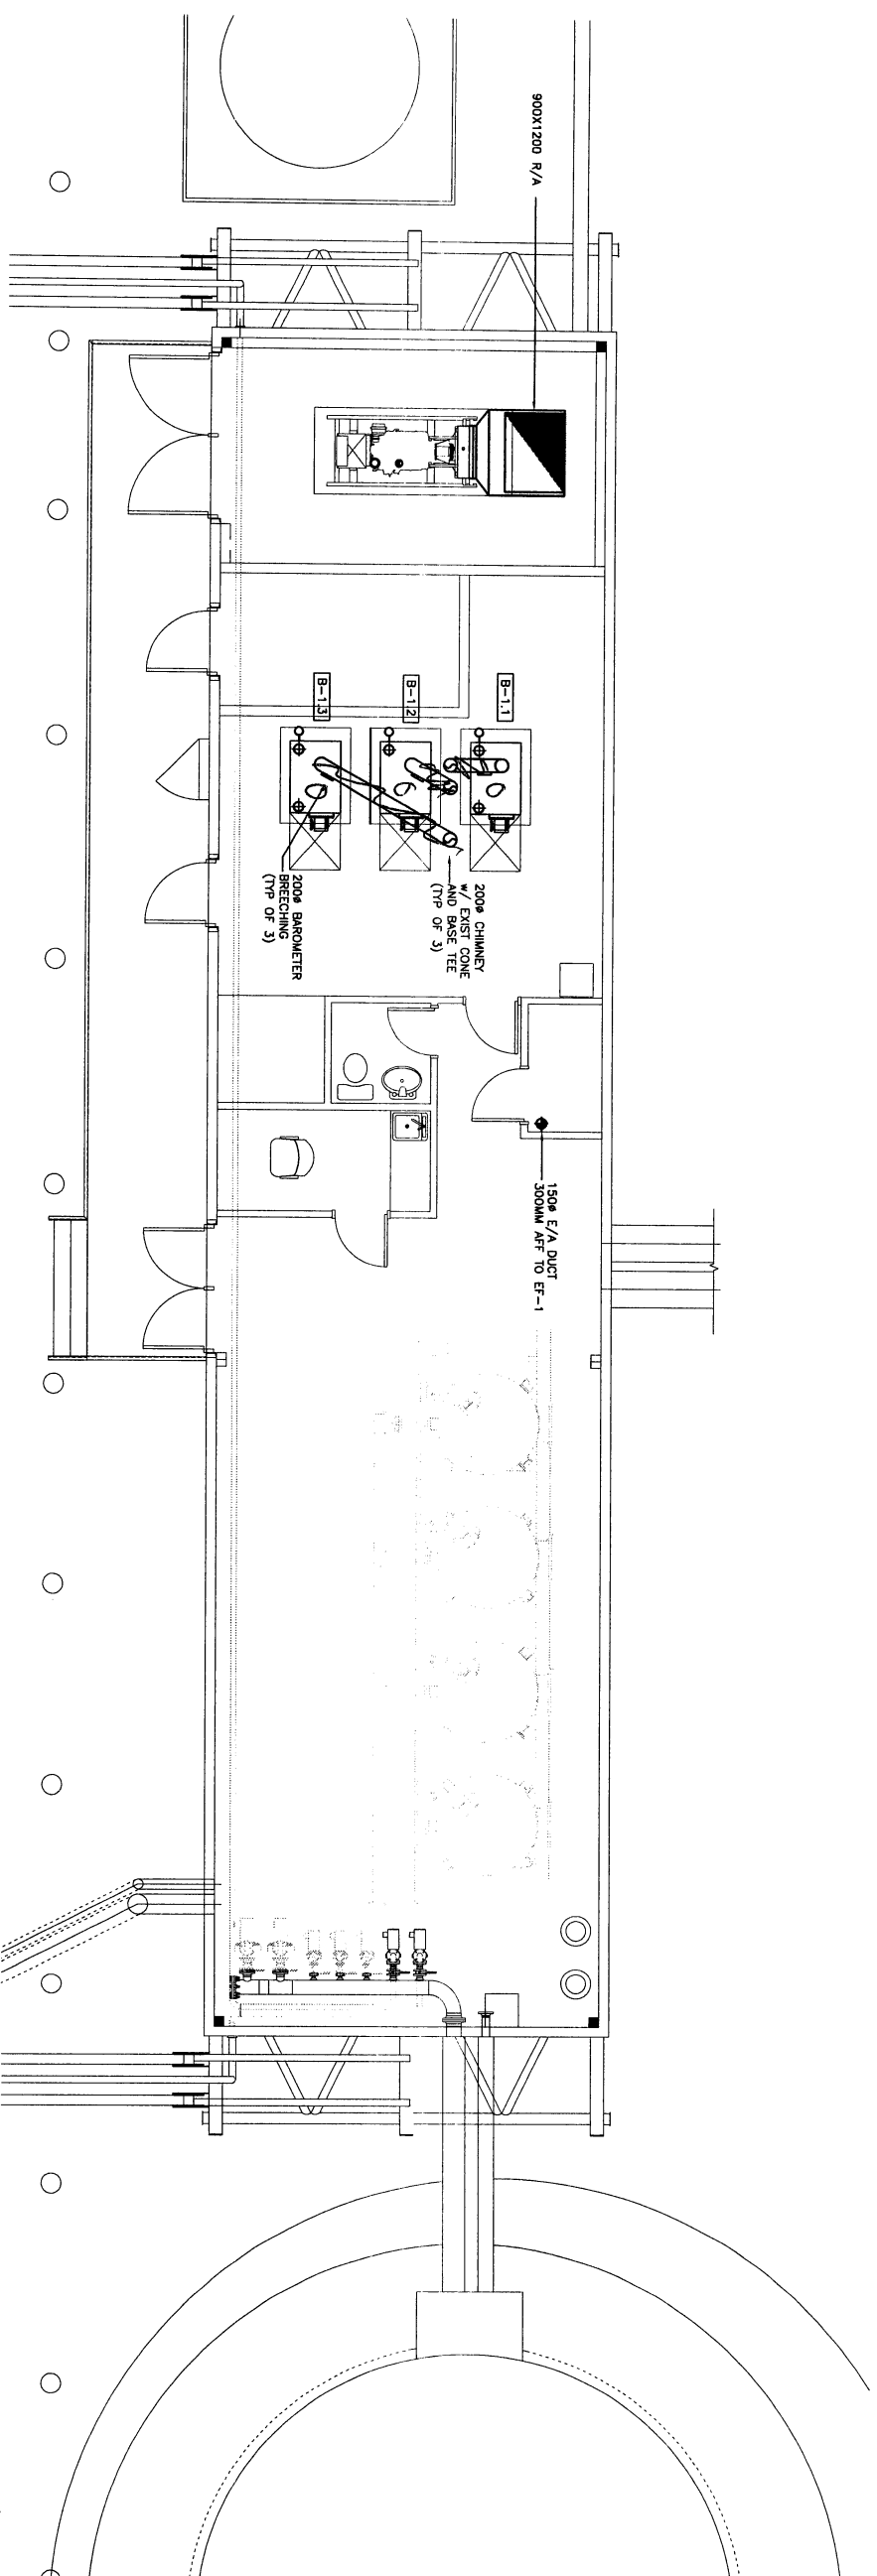


M4 1:50 VENTILATION PLAN - LOW LEVEL

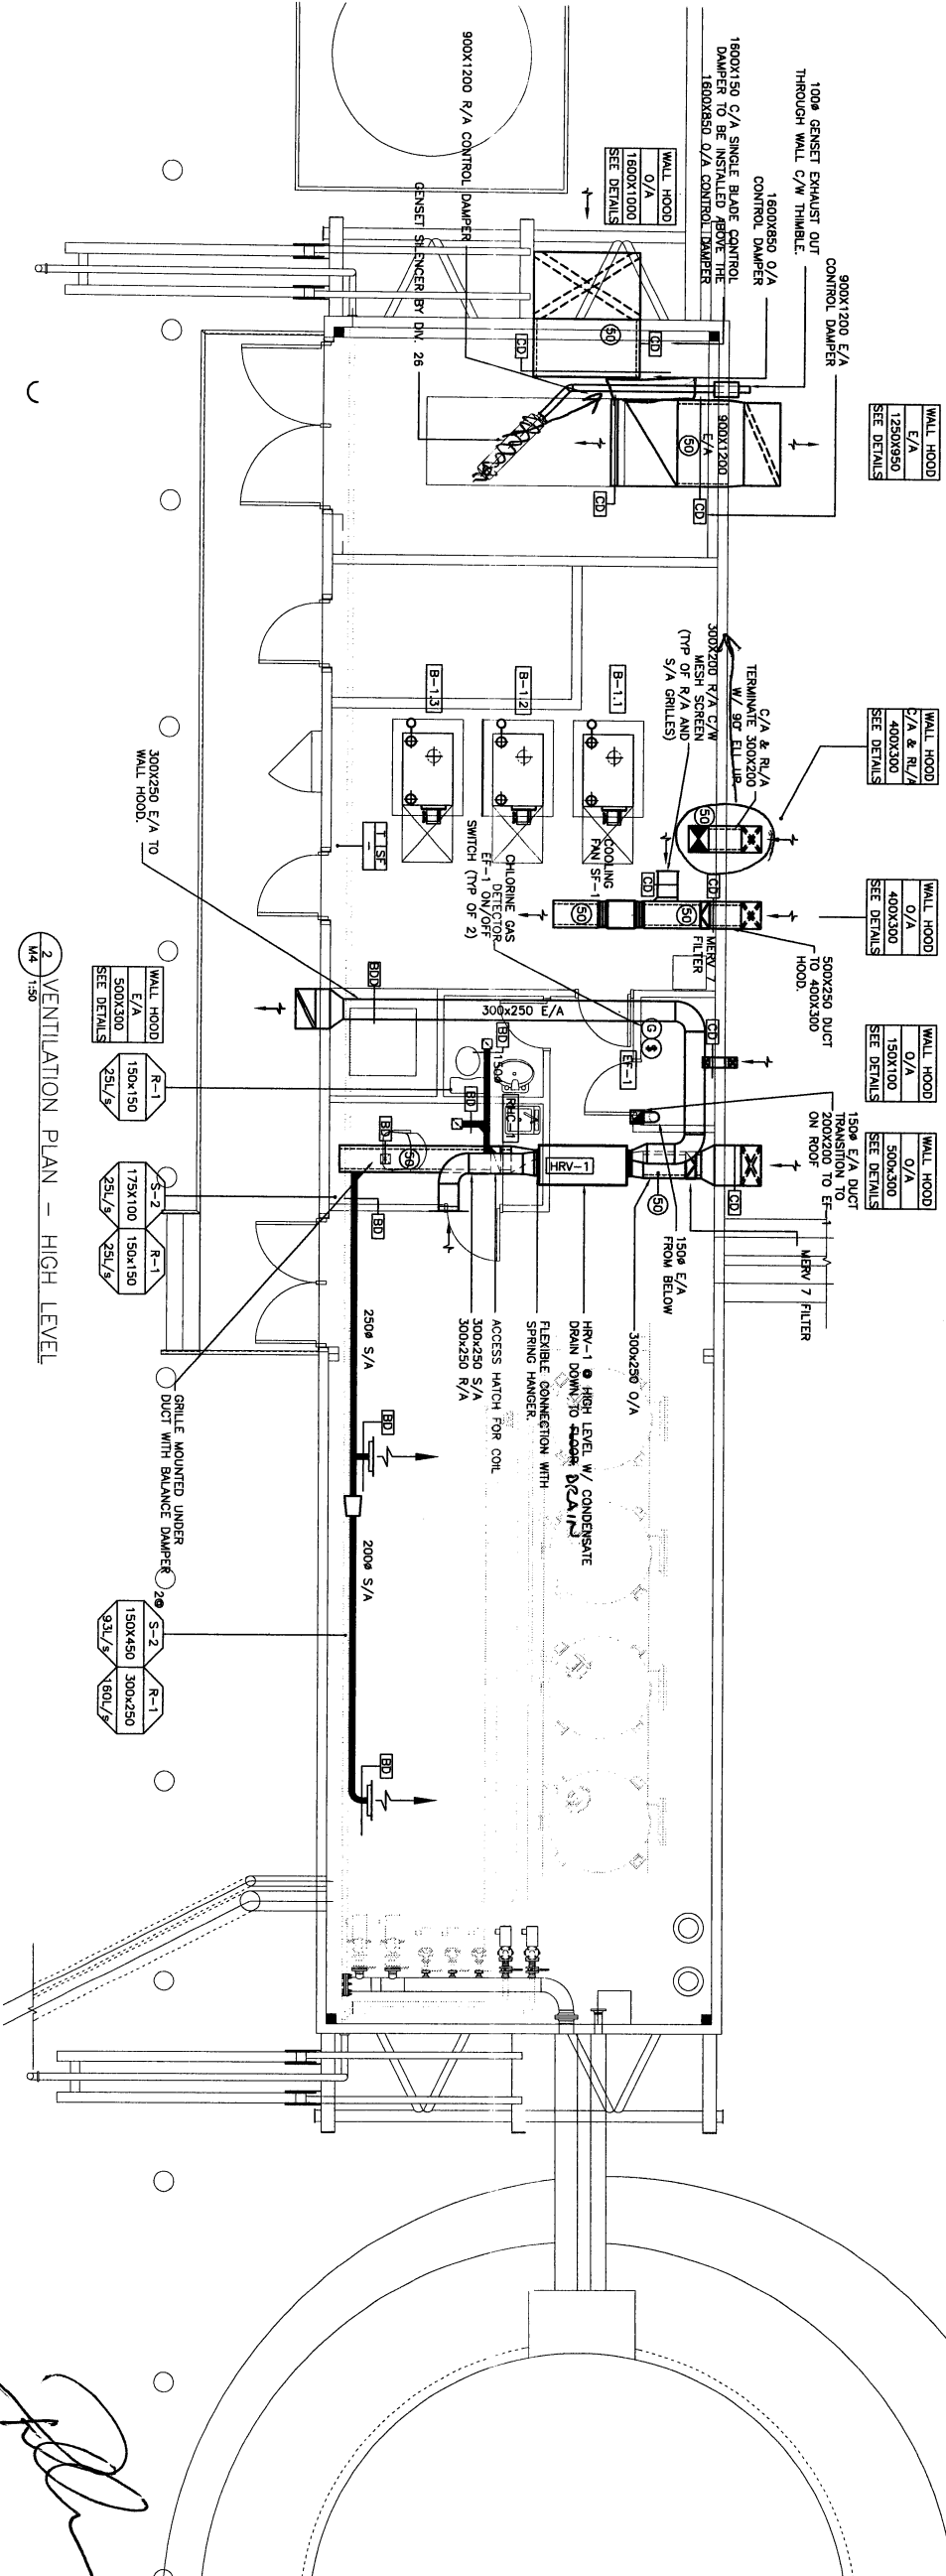


M4 1:50 VENTILATION PLAN - HIGH LEVEL



© Copyright 2008 FSC Architects & Engineers
The Firm hereby certifies that the design and construction of the project described herein was completed by the Firm or under the direct supervision of a registered professional engineer or architect who is a member of the Engineering Council of Canada or the Architects Association of Canada. The project described herein is the work of the Firm.

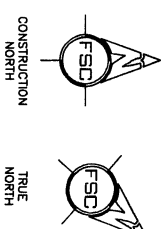

NO.	REVISION DESCRIPTION	DATE ISSUED
1	ISSUED FOR CONSTRUCTION	2011/08/18
0	ISSUED FOR TENDER	2011/03/28

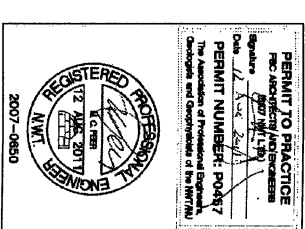

FSC
ARCHITECTS & ENGINEERS
1010 - 3RD STREET SW, SUITE 200
CALGARY, ALBERTA T2C 1A1
TEL: (403) 242-2222 FAX: (403) 242-2223

NEW WATER PUMP/CHLORINATION FACILITY AND INTAKE STRUCTURE

VENTILATION PLANS


DATE	2007-08-30
BY	MP
CHECKED BY	AS SHOWN
DATE	07-30-23

M4



© Copyright 2008 FSC Architects & Engineers
The Firm, its staff and employees are not responsible for the use of the drawings and specifications for any purpose other than that for which they were prepared. The Firm shall not be held responsible for any errors or omissions in the drawings and specifications. The drawings and specifications are the property of the Firm and shall not be reproduced or used in any manner without the written consent of the Firm.


1	ISSUED FOR CONSTRUCTION	2011/06/19
2	ISSUED FOR TENDER	2011/03/28
NO.	REVISION DESCRIPTION	DATE REVISION

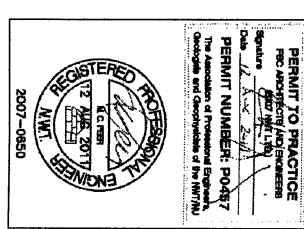

FSC
ARCHITECTS & ENGINEERS
1010 - 5500 SHEPPARD AVE. E. SUITE 200
VICTORIA, B.C. V8N 2T7
TEL: (250) 920-2892 FAX: (250) 920-4119

NEW WATER PUMP/CHLORINATION FACILITY AND INTAKE STRUCTURE
BAKERLAKE, NU
BUILDING HEAT SCHEMATIC

1	RTA/DK	AS SHOWN
2	MP	07-3023
3	2007-08-50	
4	M5	

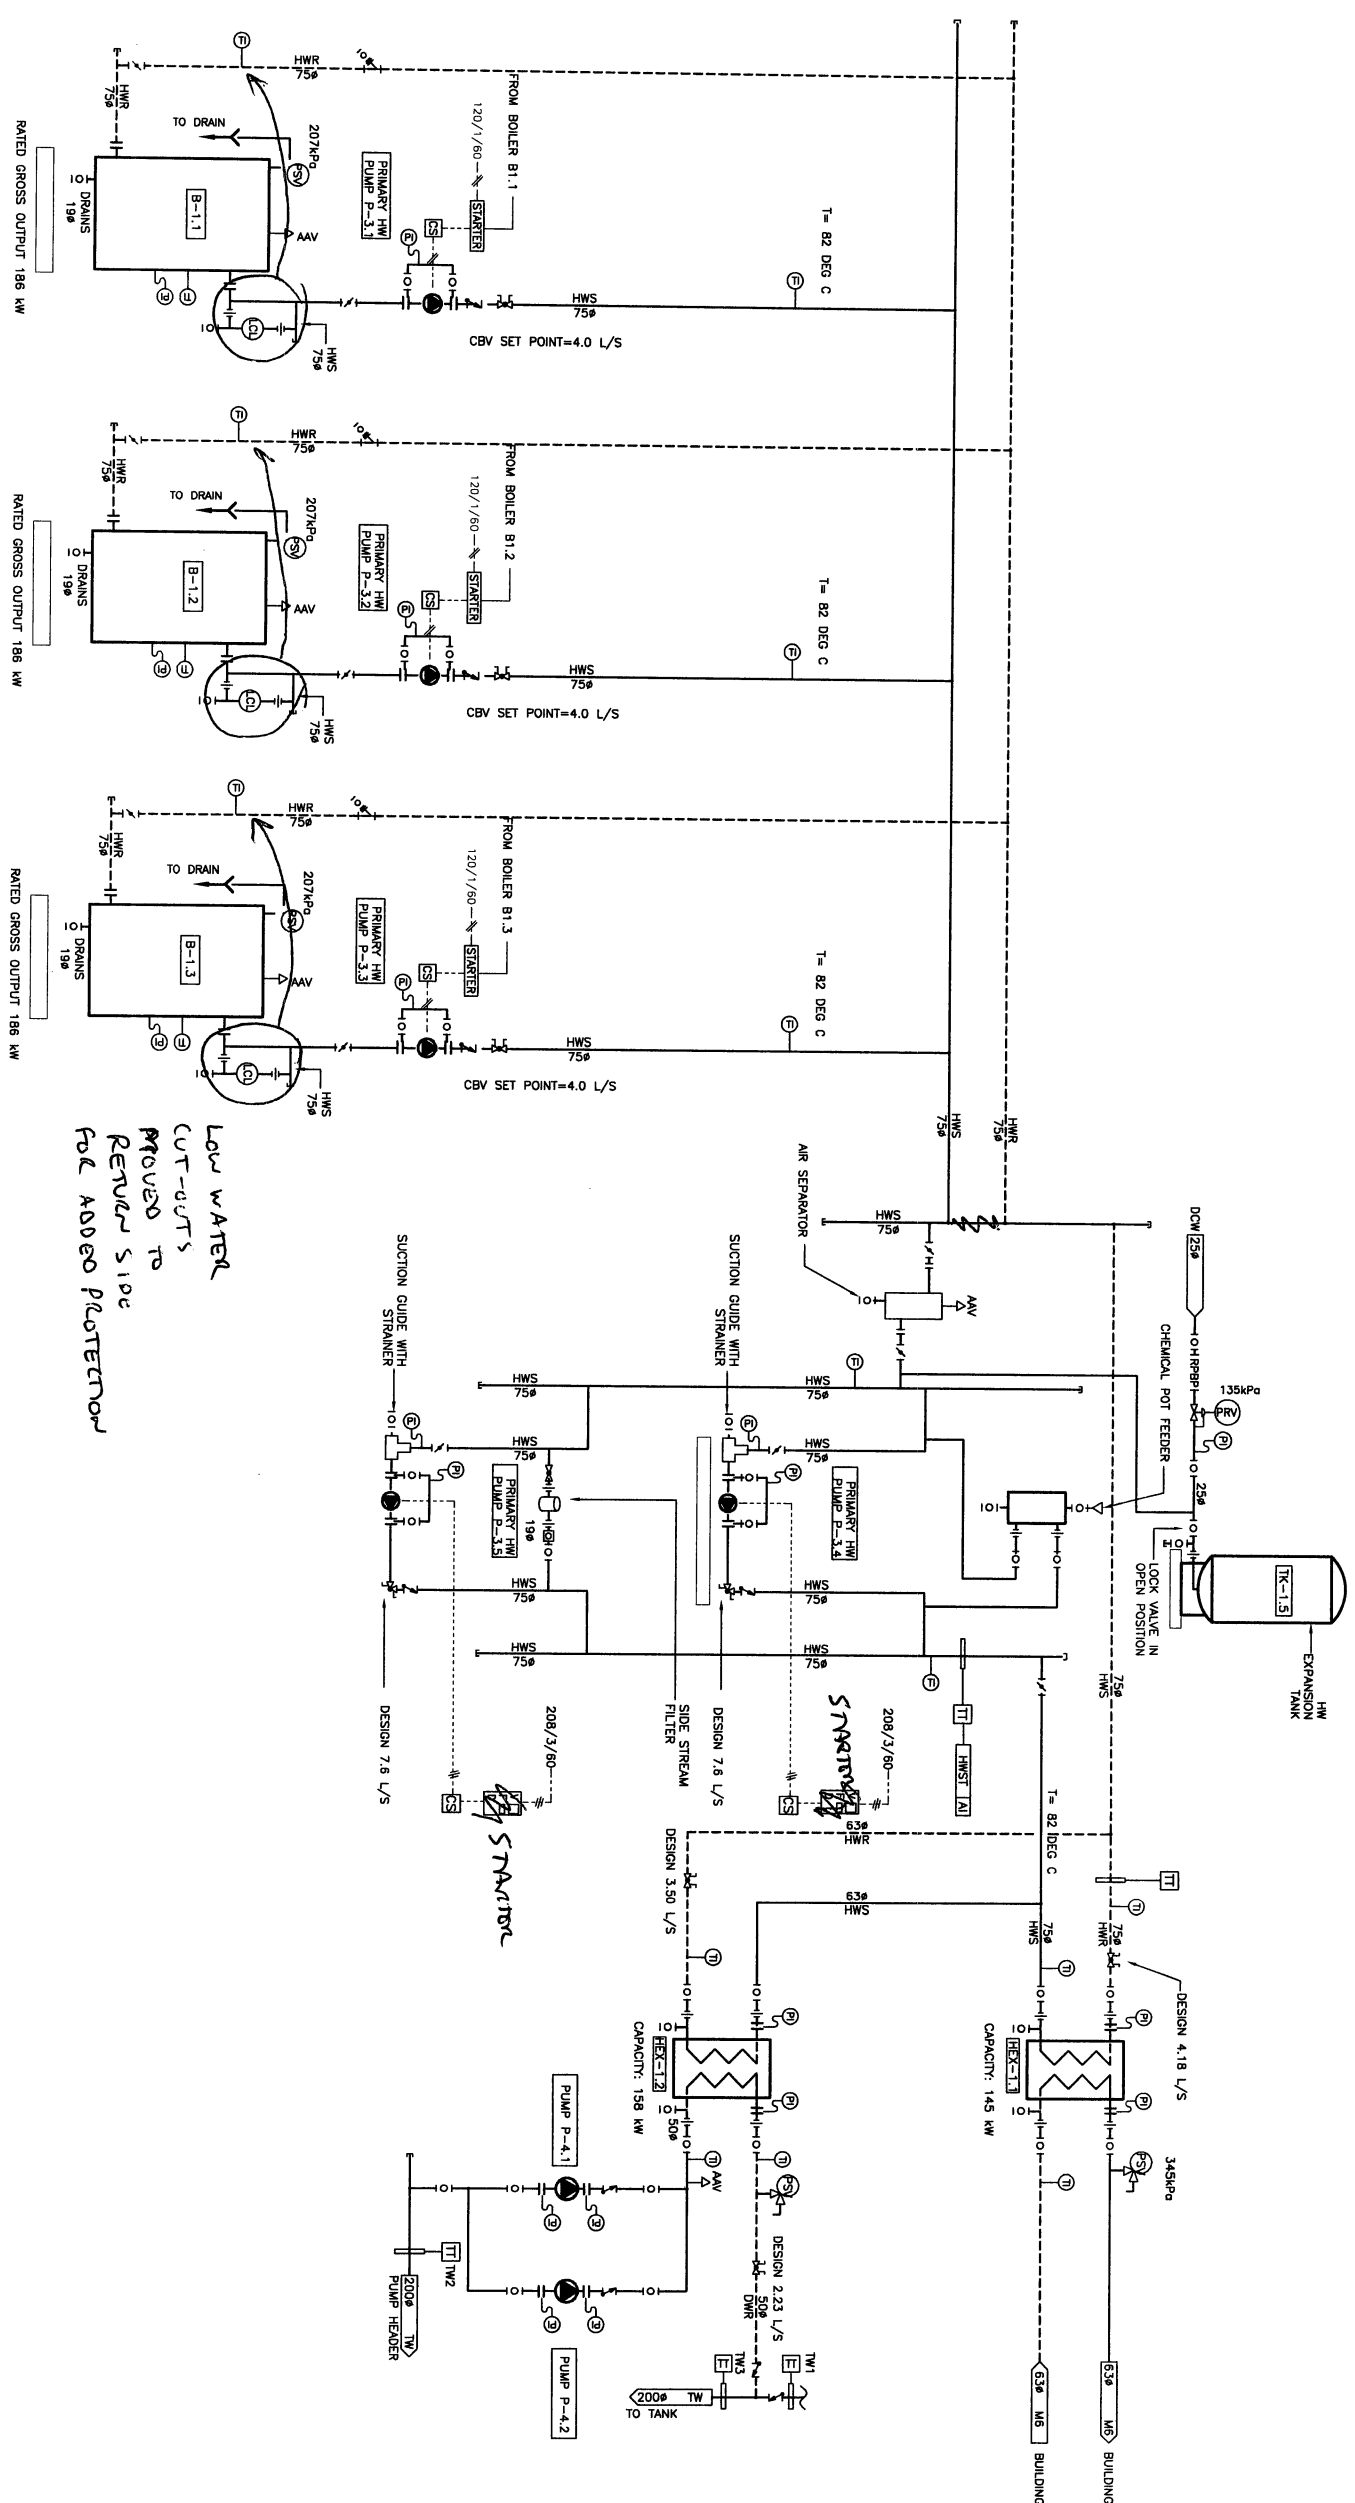

LOW WATER CUT-OUTS
PROVED TO
RETURN SIDE
FOR ADDED PROTECTION

PRIMARY HEATING SCHEMATIC

[Handwritten signature]

