




The Contractor shall verify and be responsible for all dimensions. DO NOT scale the drawing – any errors or omissions shall be reported to Stantec without delay.

The Copyrights to all designs and drawings are the property of Stantec. Reproduction or use for any purpose other than that authorized by Stantec is forbidden.

Consultants

Legend

Notes

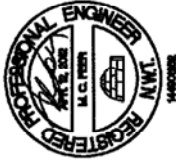[illegible]

GOVERNMENT OF NUNAVUT

Cambridge Bay, NU

Title _____

**MECHANICAL
SITE PLAN**

Project No. 1449-01252	Scale AS NOTED
Drawing No. M-101	Sheet 1 of 6
	Revision 0





Stantec
4910 53rd Street
Yellowknife, NT
X1A 2P4
Tel. (867) 920-2882
Fax. (867) 920-4319
www.stantec.com

Copyright Reserved

The Contractor shall verify and be responsible for all dimensions. DO NOT scale the drawing - any errors or omissions shall be reported to Stantec immediately. The Contractor shall retain the original drawings. The Copyrights to all designs and drawings are the property of Stantec. Reproduction or use for any purpose other than that authorized by Stantec is forbidden.

Consultants

Legend

Notes

Revision

By

Appd.

YY.MM.DD

ISSUED FOR TENDER

BM

MP

12.03.30

80% SUBMISSION

BM

MP

12.03.02

50% SUBMISSION

BM

MP

12.01.18

Issued

By

Appd.

YY.MM.DD

File Name:

Own.

 
Chgd.

By

YY.MM.DD

Permit-Seal

PERMIT TO PRACTICE
STANTEC ARCHITECTURE LTD.
Signature: [Signature]
Date: 12/03/2012
PERMIT NUMBER: P 800
NTNU Association of Professional Engineers and Geoscientists



Client/Project

GOVERNMENT OF NUNAVUT

POTABLE WATER SYSTEM
PHASE I

Cambridge Bay, NU

Title

DETAILS

Project No.

Scale

AS NOTED

Drawing No.










Sheet

Revision

M-501

3 of 5

0

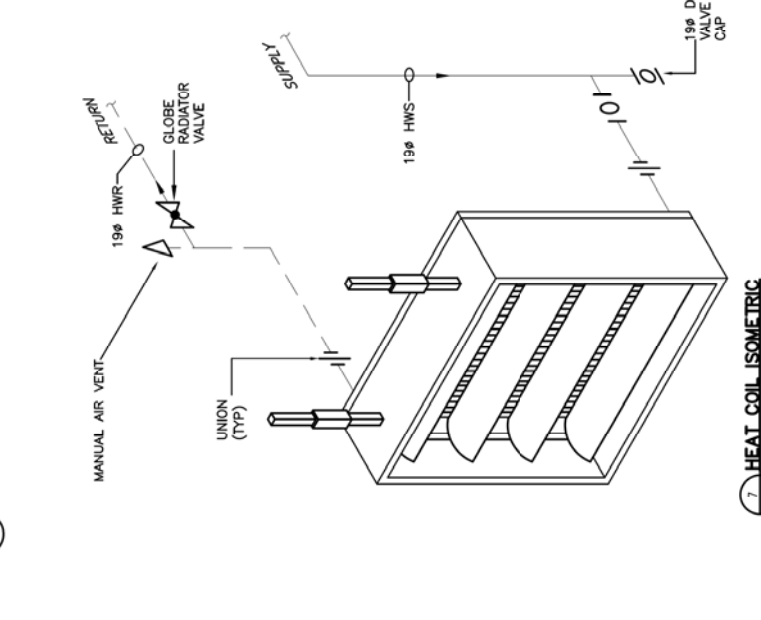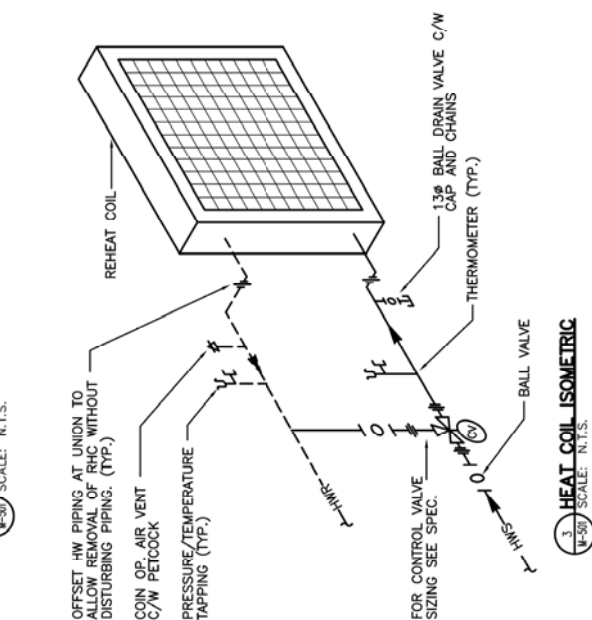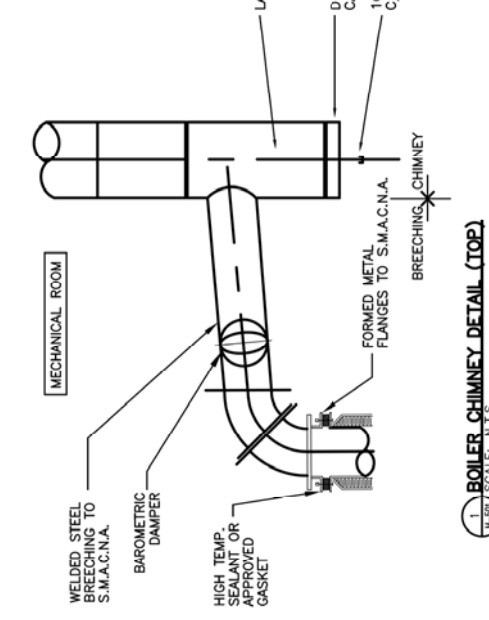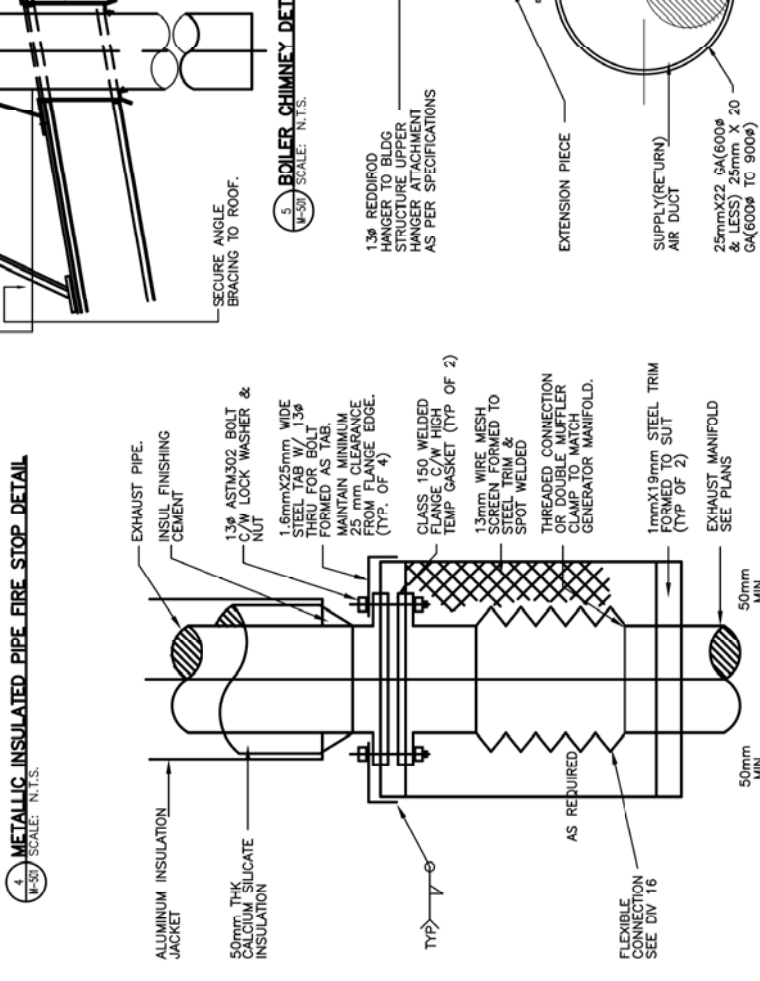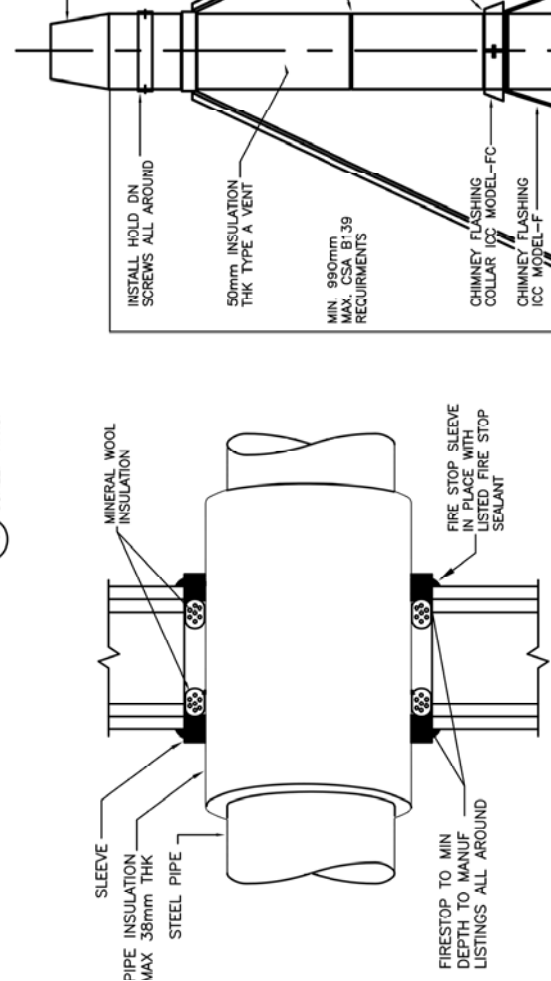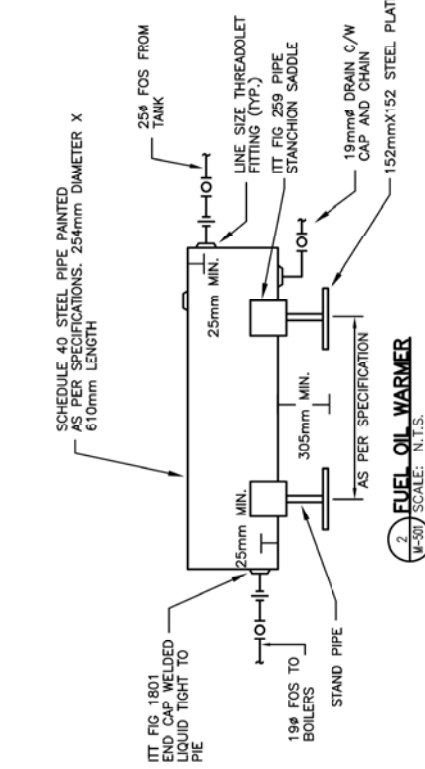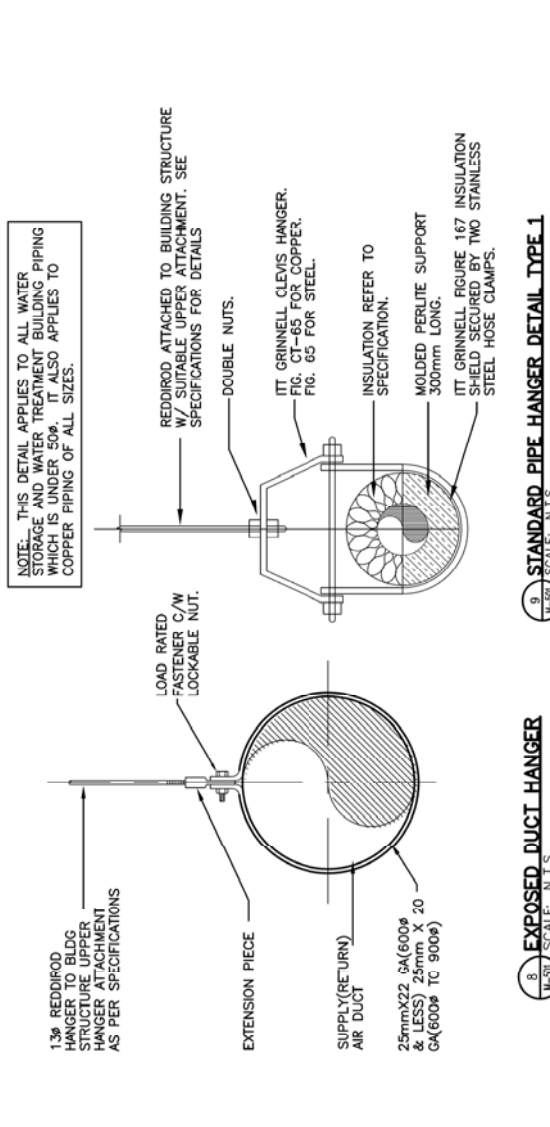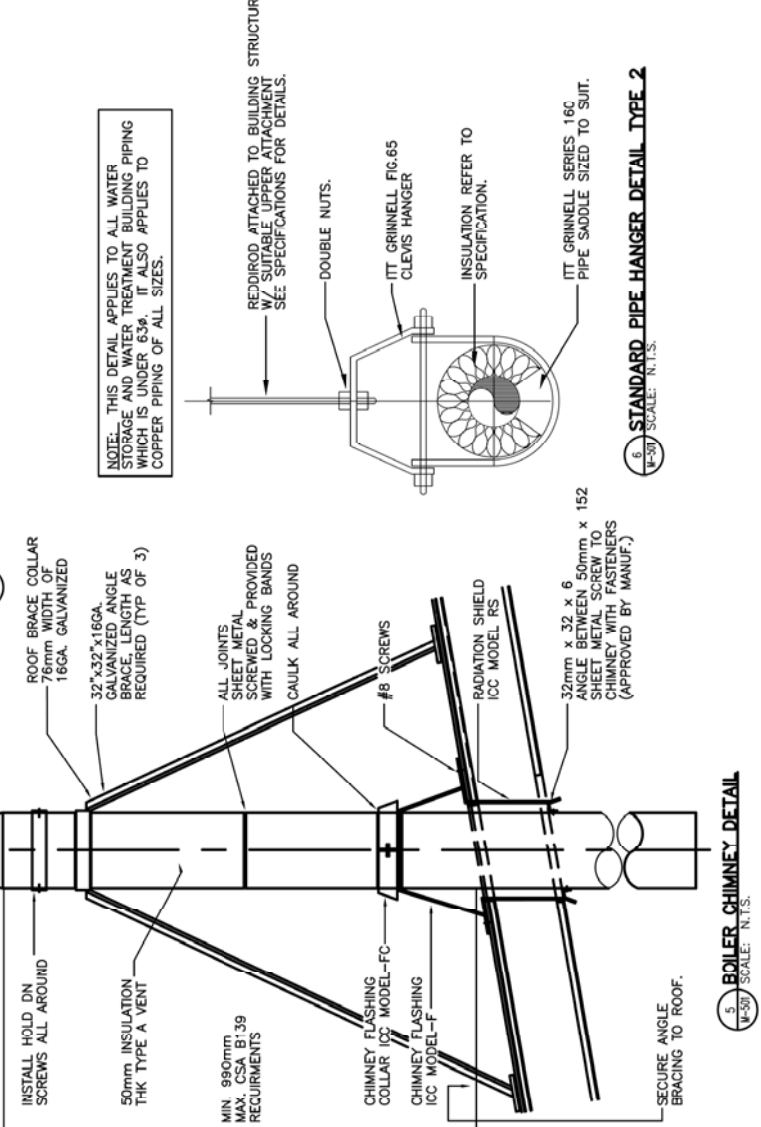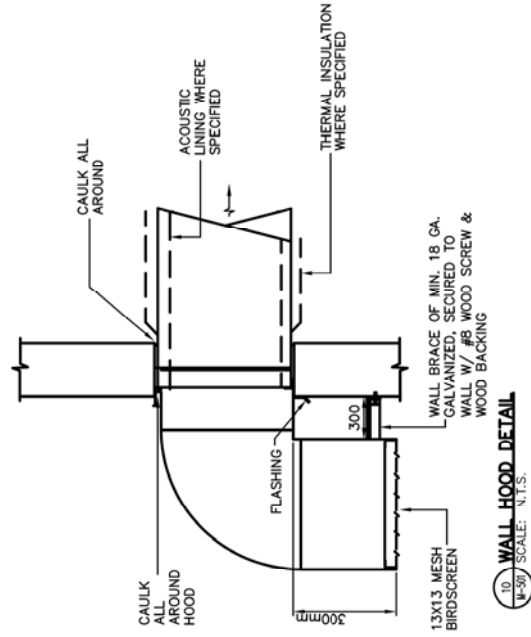



Stantec
4910 53rd Street
Yellowknife, NT
X1A 2P4
Tel. (867) 920-2882
Fax. (867) 920-4319
www.stantec.com

Stantec


Copyright Reserved

The Contractor shall verify and be responsible for all dimensions. DO NOT scale the drawing - any errors or omissions shall be reported to Stantec immediately.
The Contractor shall verify and be responsible for all dimensions. DO NOT scale the drawing - any errors or omissions shall be reported to Stantec immediately.
The Contractor shall verify and be responsible for all dimensions. DO NOT scale the drawing - any errors or omissions shall be reported to Stantec immediately.

Consultants

Legend

Notes

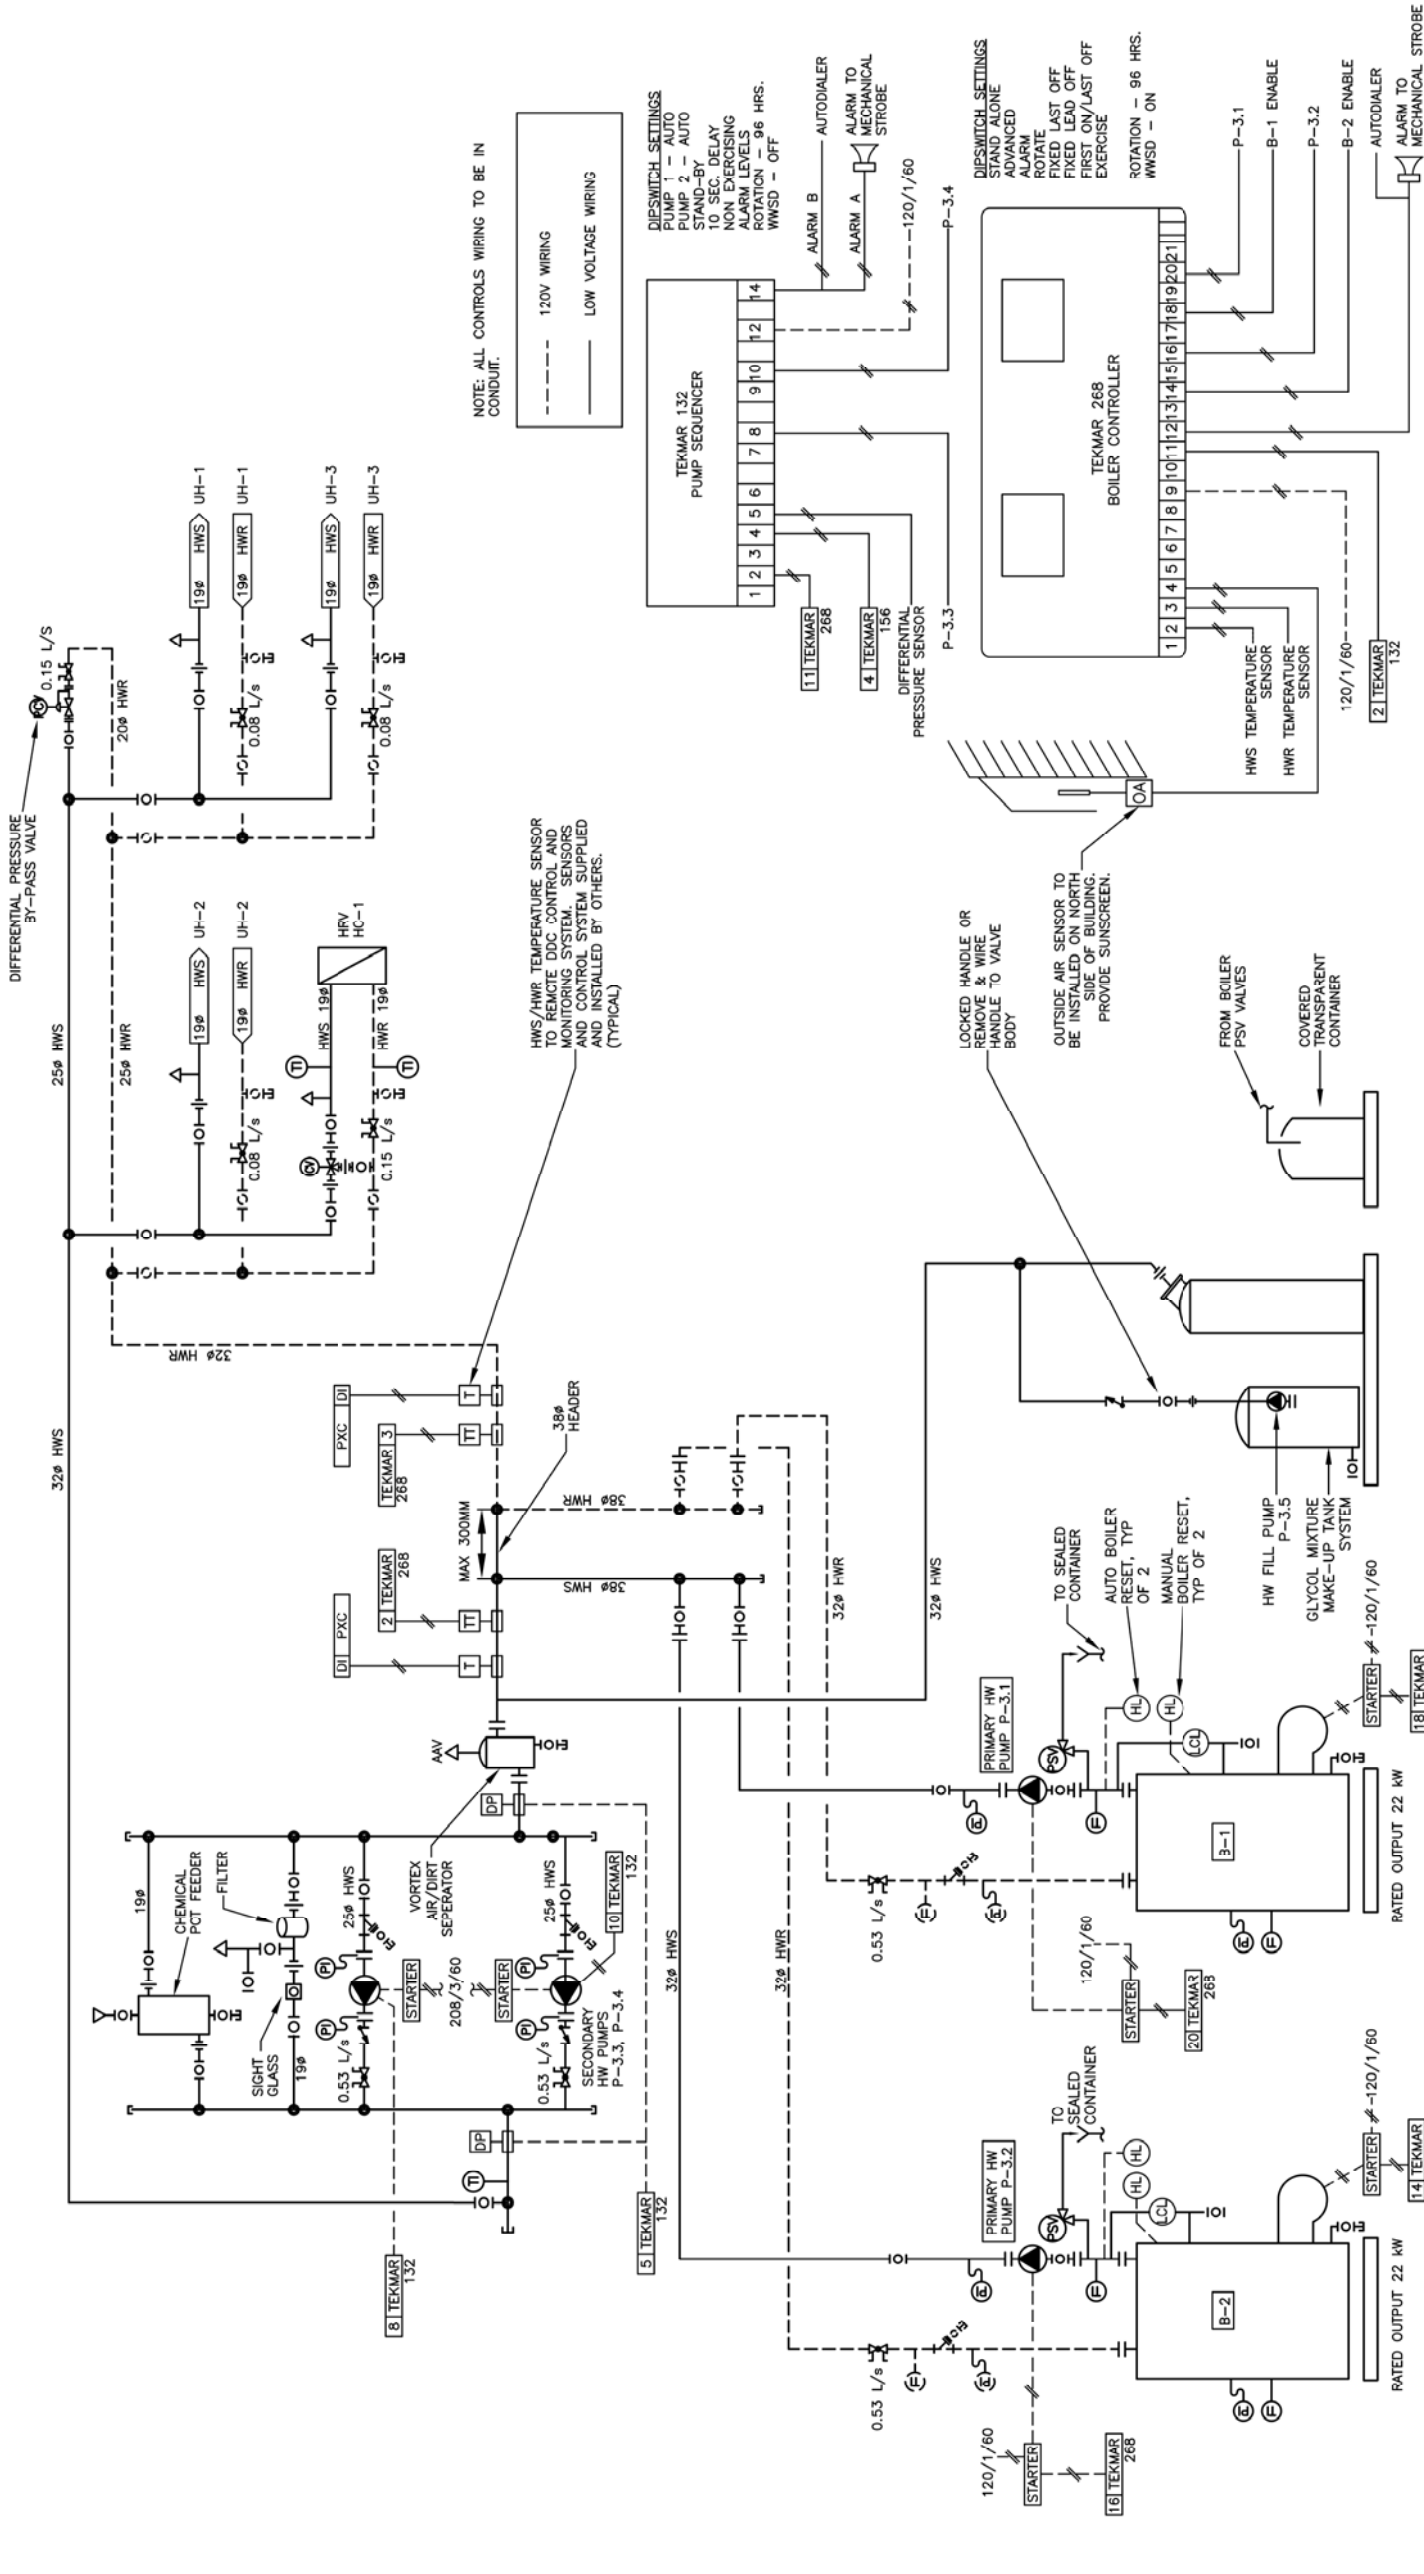

Client/Project

GOVERNMENT OF NUNAVUT

POTABLE WATER SYSTEM
PHASE I

Cambridge Bay, NU

HEATING
SCHEMATIC

Project No.

1449-01252

Drawing No.

M-601

Sheet

5 of 6

Revision

0

1 HEATING SCHEMATIC
P-801 SCALE: N.T.S.

ORIGINAL SHEET - AWS 0

