

 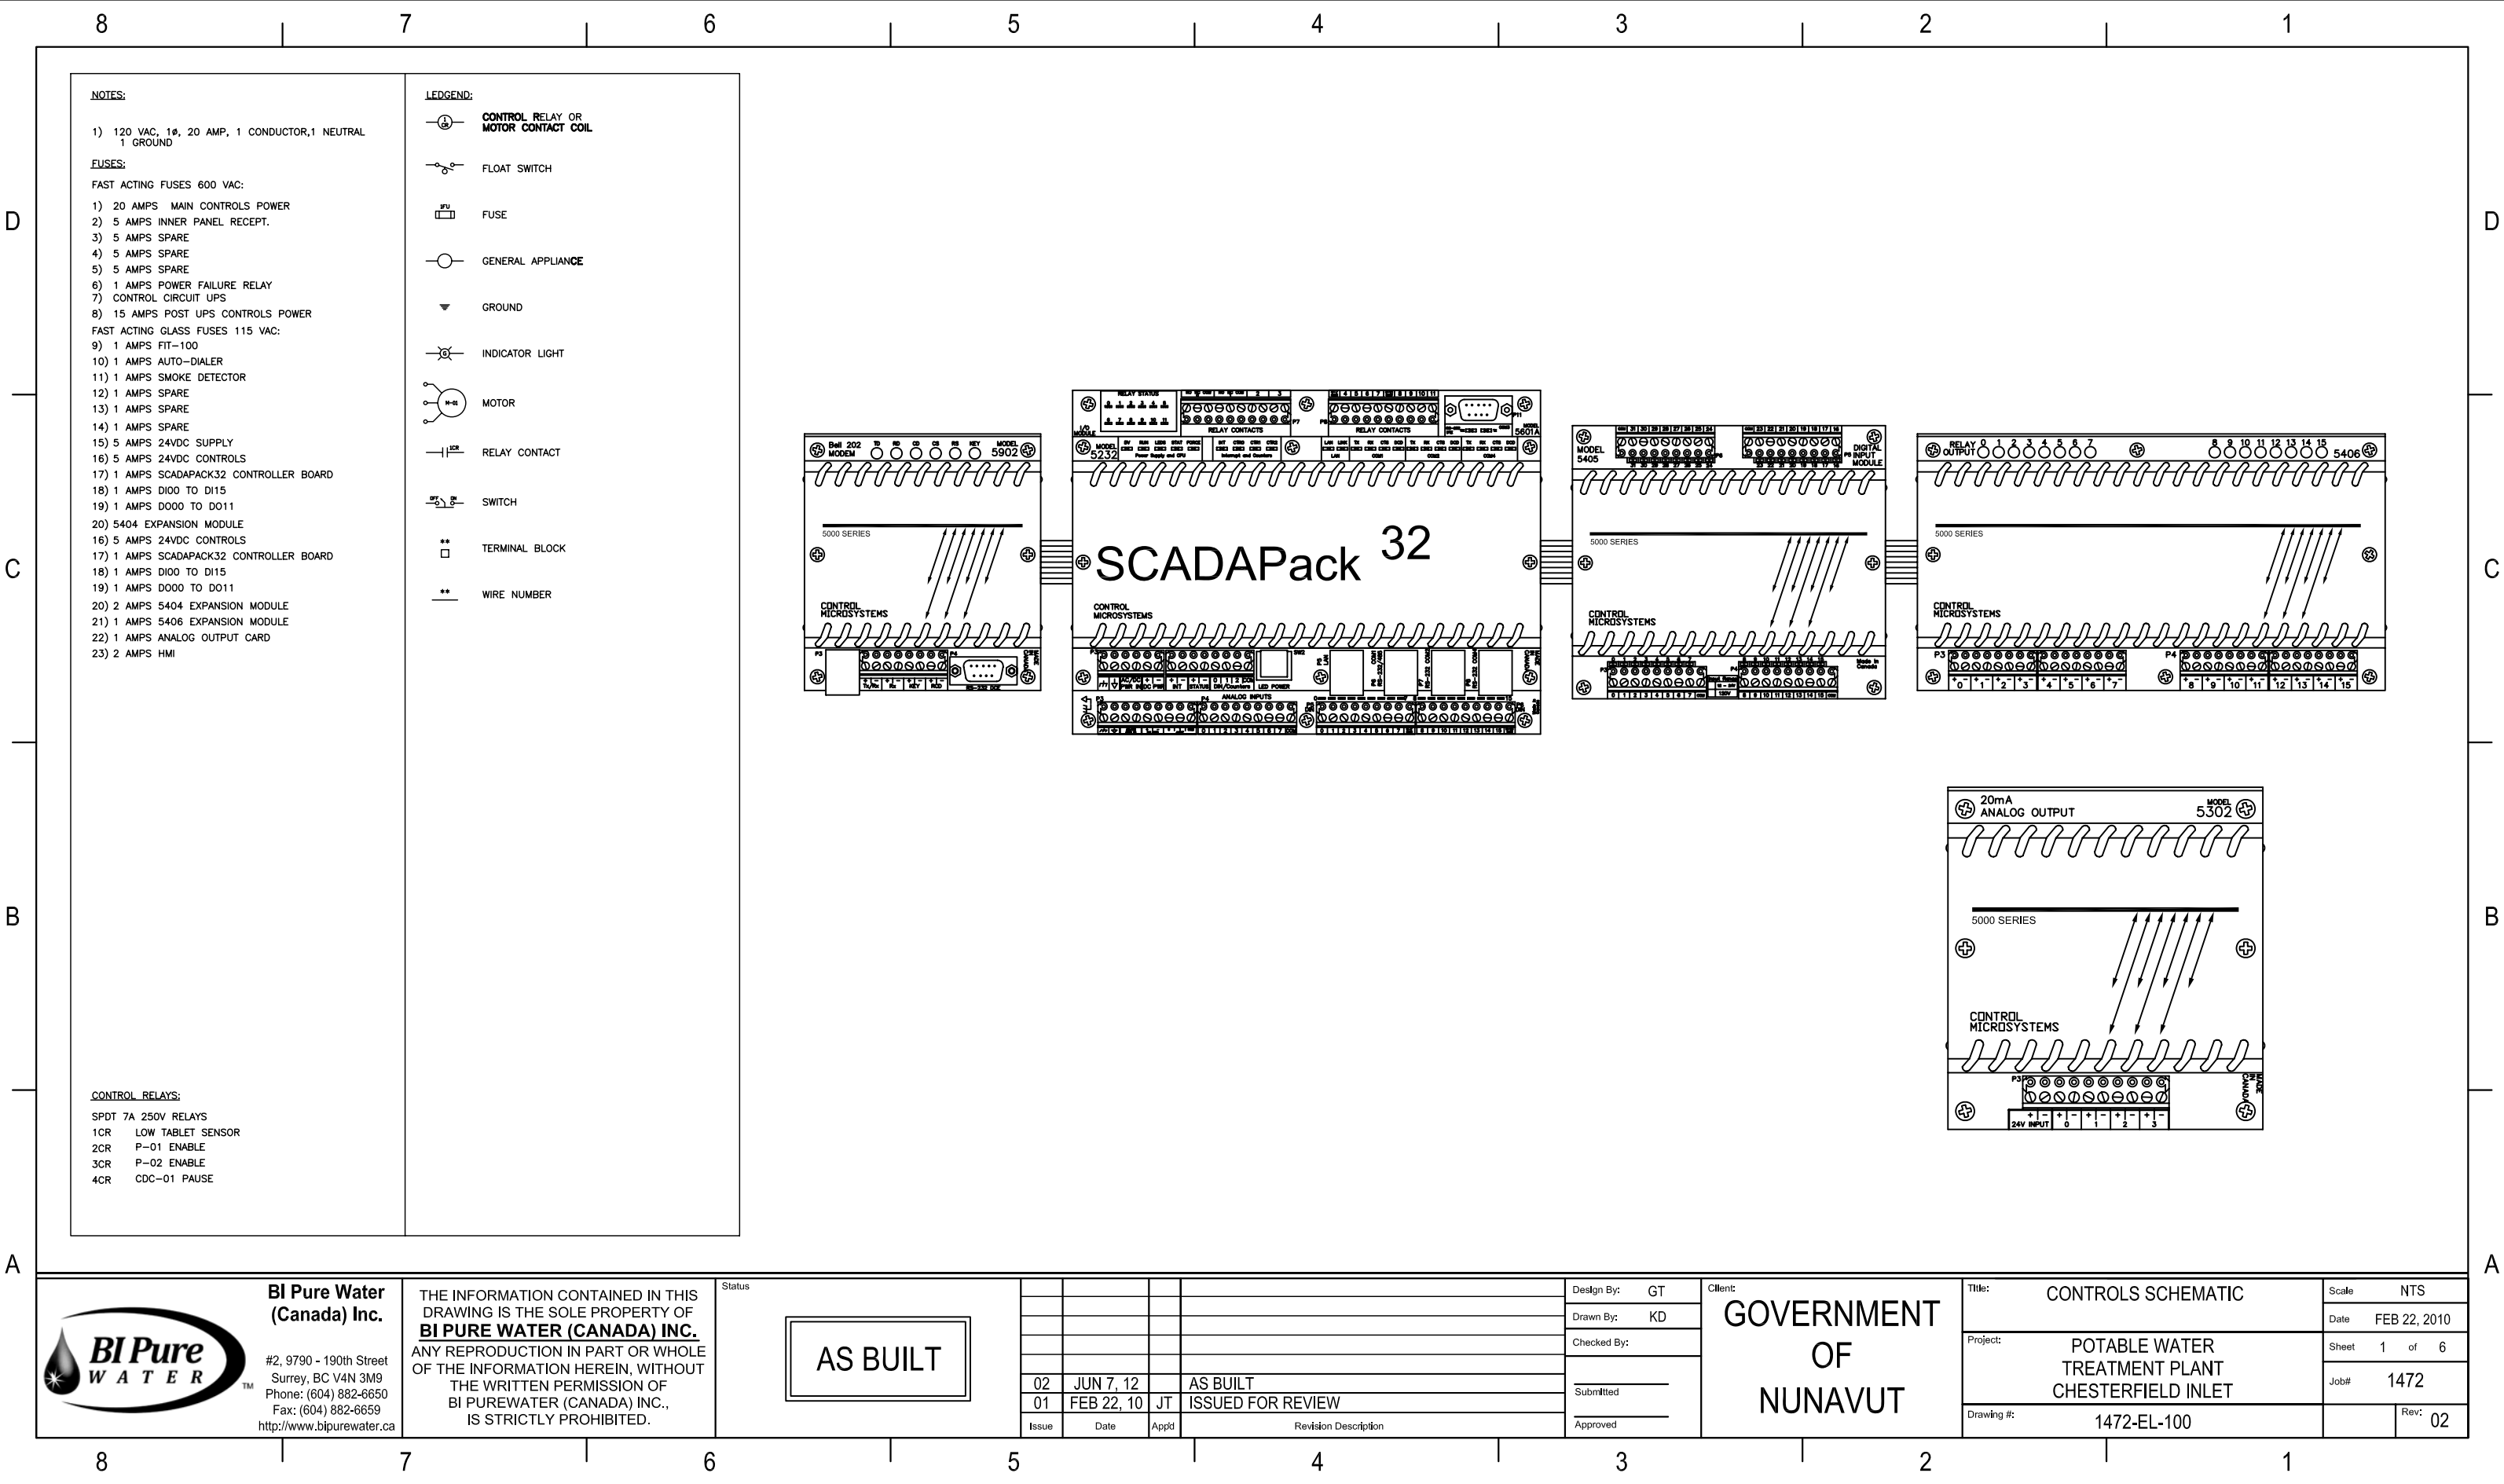


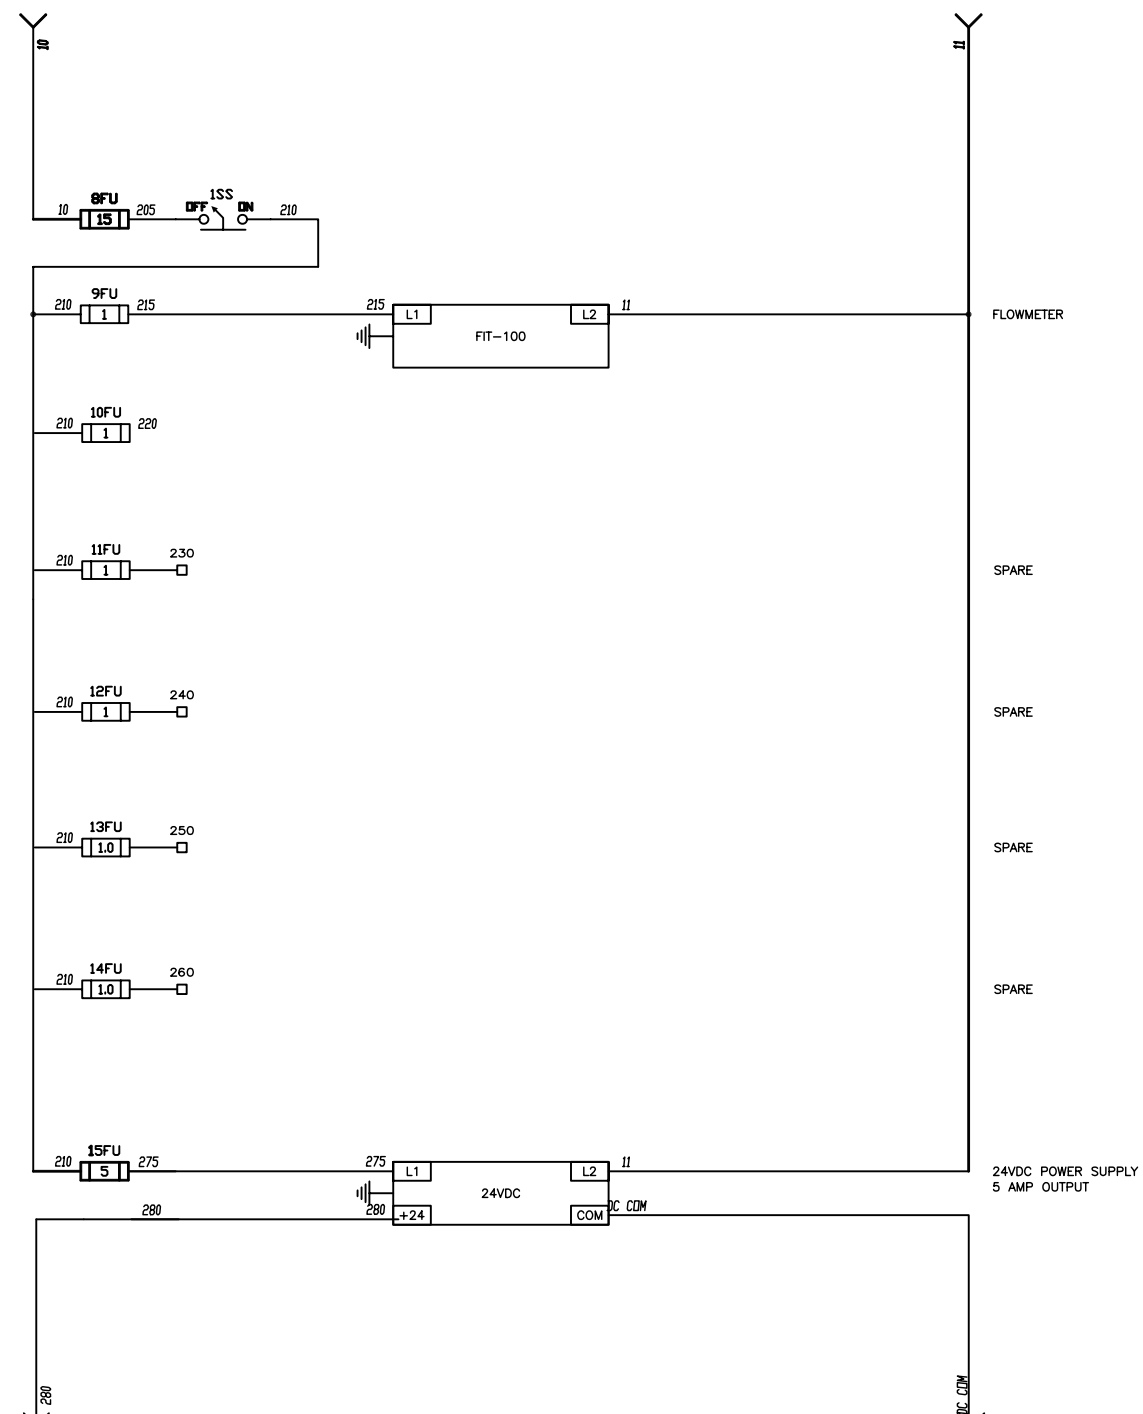



 BI Pure Water (Canada) Inc. #2, 9790 - 190th Street Surrey, BC V4N 3M9 Phone: (604) 882-6650 Fax: (604) 882-6659 http://www.bipurewater.ca	THE INFORMATION CONTAINED IN THIS DRAWING IS THE SOLE PROPERTY OF BI PURE WATER (CANADA) INC. ANY REPRODUCTION IN PART OR WHOLE OF THE INFORMATION HEREIN, WITHOUT THE WRITTEN PERMISSION OF BI PURE WATER (CANADA) INC., IS STRICTLY PROHIBITED.	AS BUILT	Status				Design By: GT	Client: GOVERNMENT OF NUNAVUT	Title: CONTROLS SCHEMATIC	Scale: NTS	
							Drawn By: KD			Date: FEB 22, 2010	
							Checked By:			Sheet: 2 of 6	
							Submitted			Job#: 1472	
				02 JUN 7, 12		AS BUILT	Approved			Drawing #: 1472-EL-100	Rev: 02
				01 FEB 22, 10	JT	ISSUED FOR REVIEW					
	Issue	Date	App'd	Revision Description							

D

C

B


A

D


C

B

A

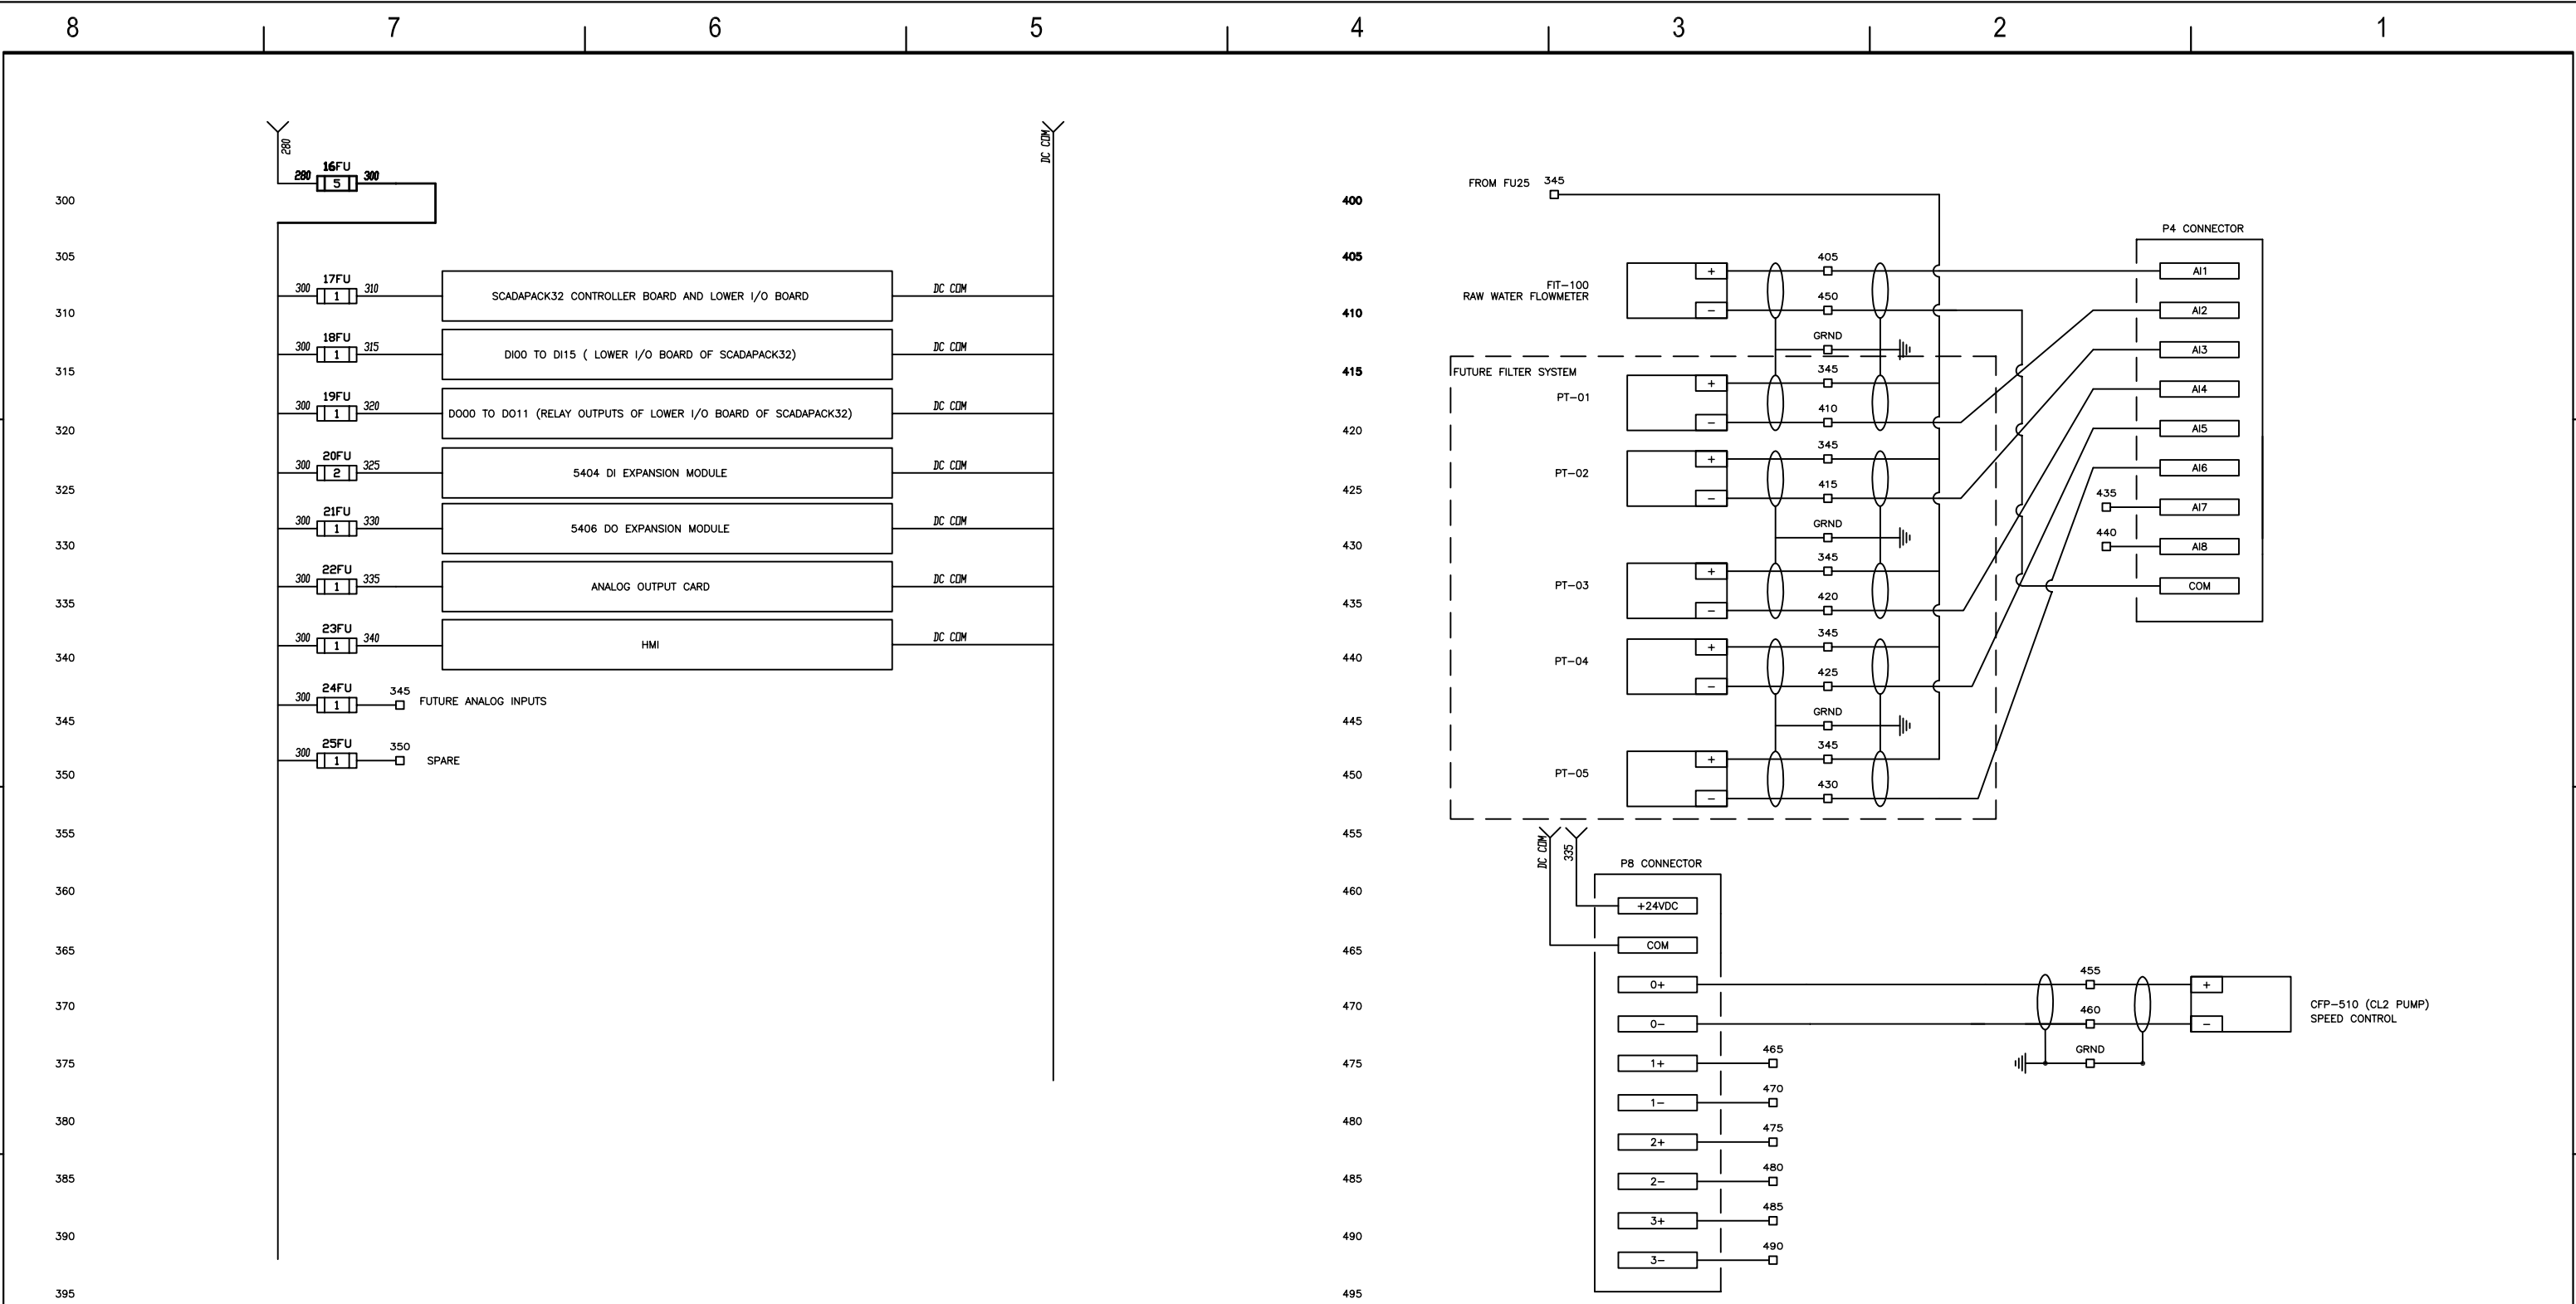

	BI Pure Water (Canada) Inc. #2, 9790 - 190th Street Surrey, BC V4N 3M9 Phone: (604) 882-6650 Fax: (604) 882-6659 http://www.bipurewater.ca	THE INFORMATION CONTAINED IN THIS DRAWING IS THE SOLE PROPERTY OF BI PURE WATER (CANADA) INC. ANY REPRODUCTION IN PART OR WHOLE OF THE INFORMATION HEREIN, WITHOUT THE WRITTEN PERMISSION OF BI PUREWATER (CANADA) INC., IS STRICTLY PROHIBITED.	AS BUILT	Status			
02	JUN 7, 12		AS BUILT	Design By: GT	GOVERNMENT OF NUNAVUT	Title: CONTROLS SCHEMATIC	Scale: NTS
01	FEB 22, 10	JT	ISSUED FOR REVIEW	Drawn By: KD		Project: POTABLE WATER TREATMENT PLANT CHESTERFIELD INLET	Date: FEB 22, 2010
				Checked By:			Sheet 3 of 6
				Submitted			Job# 1472
				Approved			Drawing #: 1472-EL-100

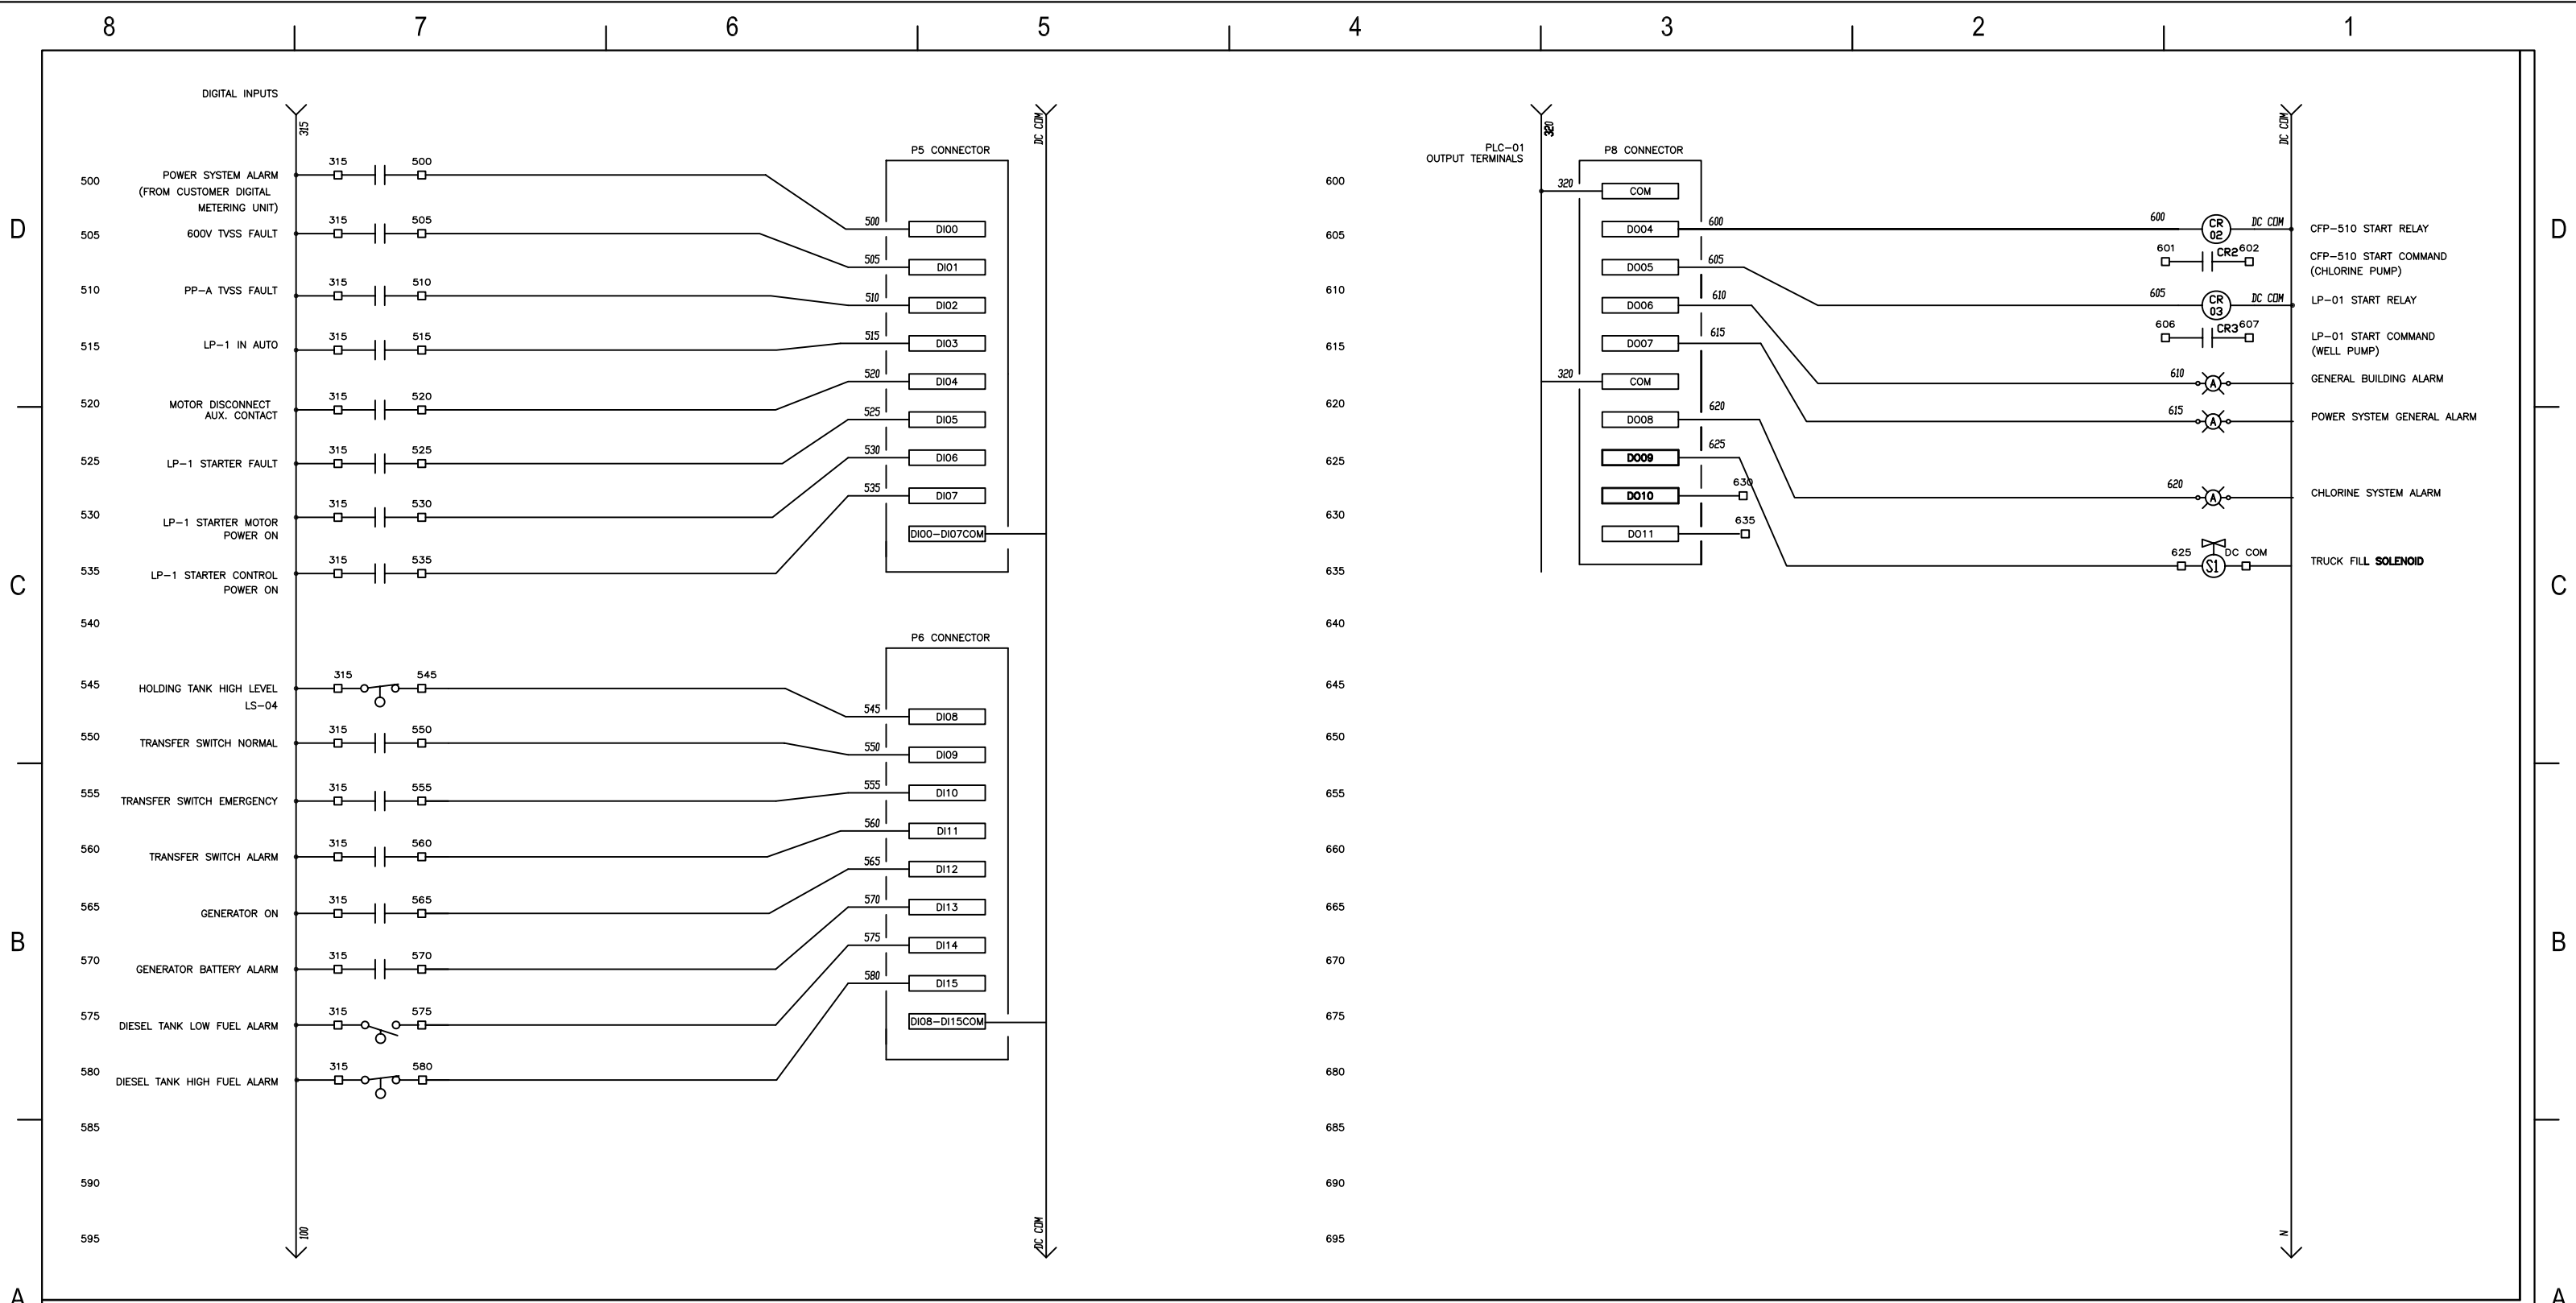



**BI Pure Water
(Canada) Inc.**
#2, 9790 - 190th Street
Surrey, BC V4N 3M9
Phone: (604) 882-6650
Fax: (604) 882-6659
<http://www.bipurewater.ca>

THE INFORMATION CONTAINED IN THIS DRAWING IS THE SOLE PROPERTY OF **BI PURE WATER (CANADA) INC.** ANY REPRODUCTION IN PART OR WHOLE OF THE INFORMATION HEREIN, WITHOUT THE WRITTEN PERMISSION OF BI PUREWATER (CANADA) INC., IS STRICTLY PROHIBITED.

Status

AS BUILT

Issue	Date	Appld	Revision Description
02	JUN 7, 12		AS BUILT
01	FEB 22, 10	JT	ISSUED FOR REVIEW

Design By: GT
Drawn By: KD
Checked By:

Submitted

Approved

Client:

GOVERNMENT OF NUNAVUT

Title:	Scale
CONTROLS SCHEMATIC	NTS

Project:	Sheet	of
POTABLE WATER TREATMENT PLANT CHESTERFIELD INLET	4	6

Drawing #:	Job#	Rev.
1472-EL-100	1472	02

8

7

6

5

4

3

2

1

