



PLUMBING AND HEATING

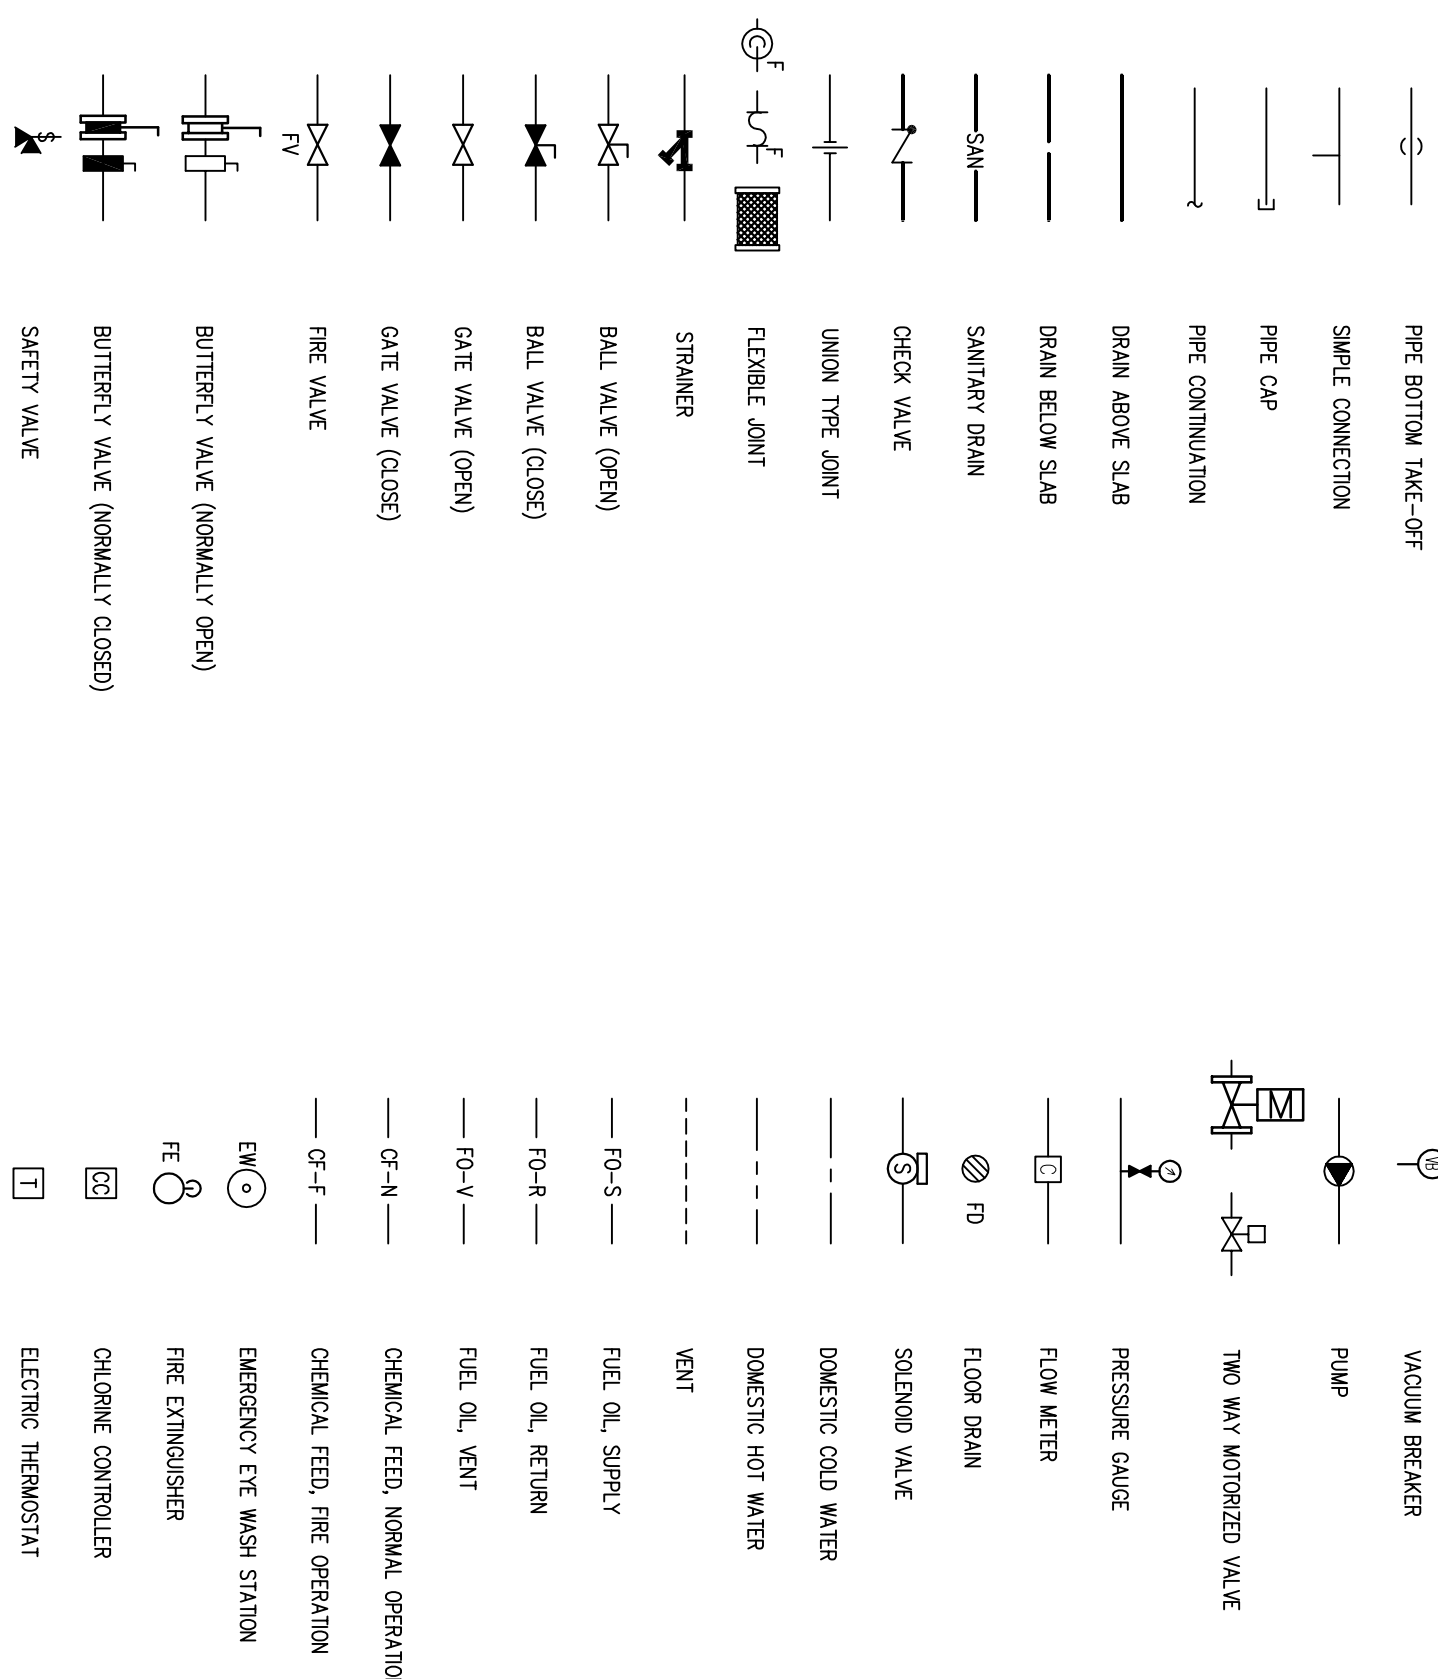


-HVAC

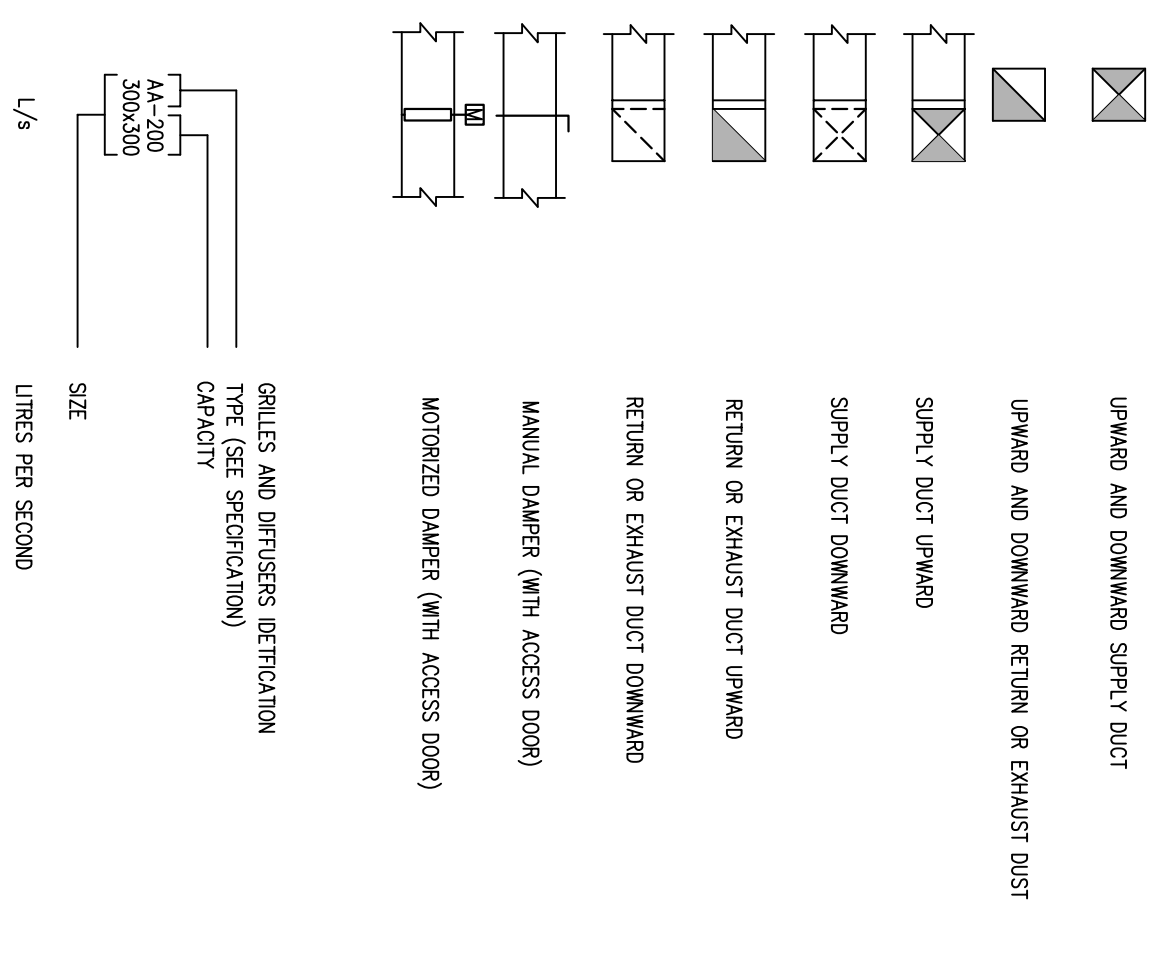


DRAWING LIST

M100	MECHANICAL – LEGEND AND DRAWING LIST
M101	MECHANICAL – DETAILS
M200	MECHANICAL – PLUMBING LAYOUT
M201	MECHANICAL – PLUMBING SCHEMATIC
M300	MECHANICAL – FUEL SYSTEM LAYOUT
M301	MECHANICAL – FUEL SYSTEM SCHEMATIC
M500	MECHANICAL – VENTILATION LAYOUT
M600	MECHANICAL – CONTROL SCHEMATICS

GENERAL

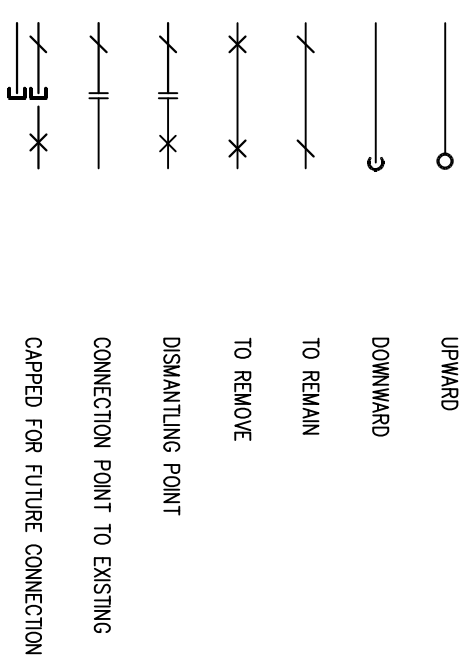


-CONTROLS LEGEND

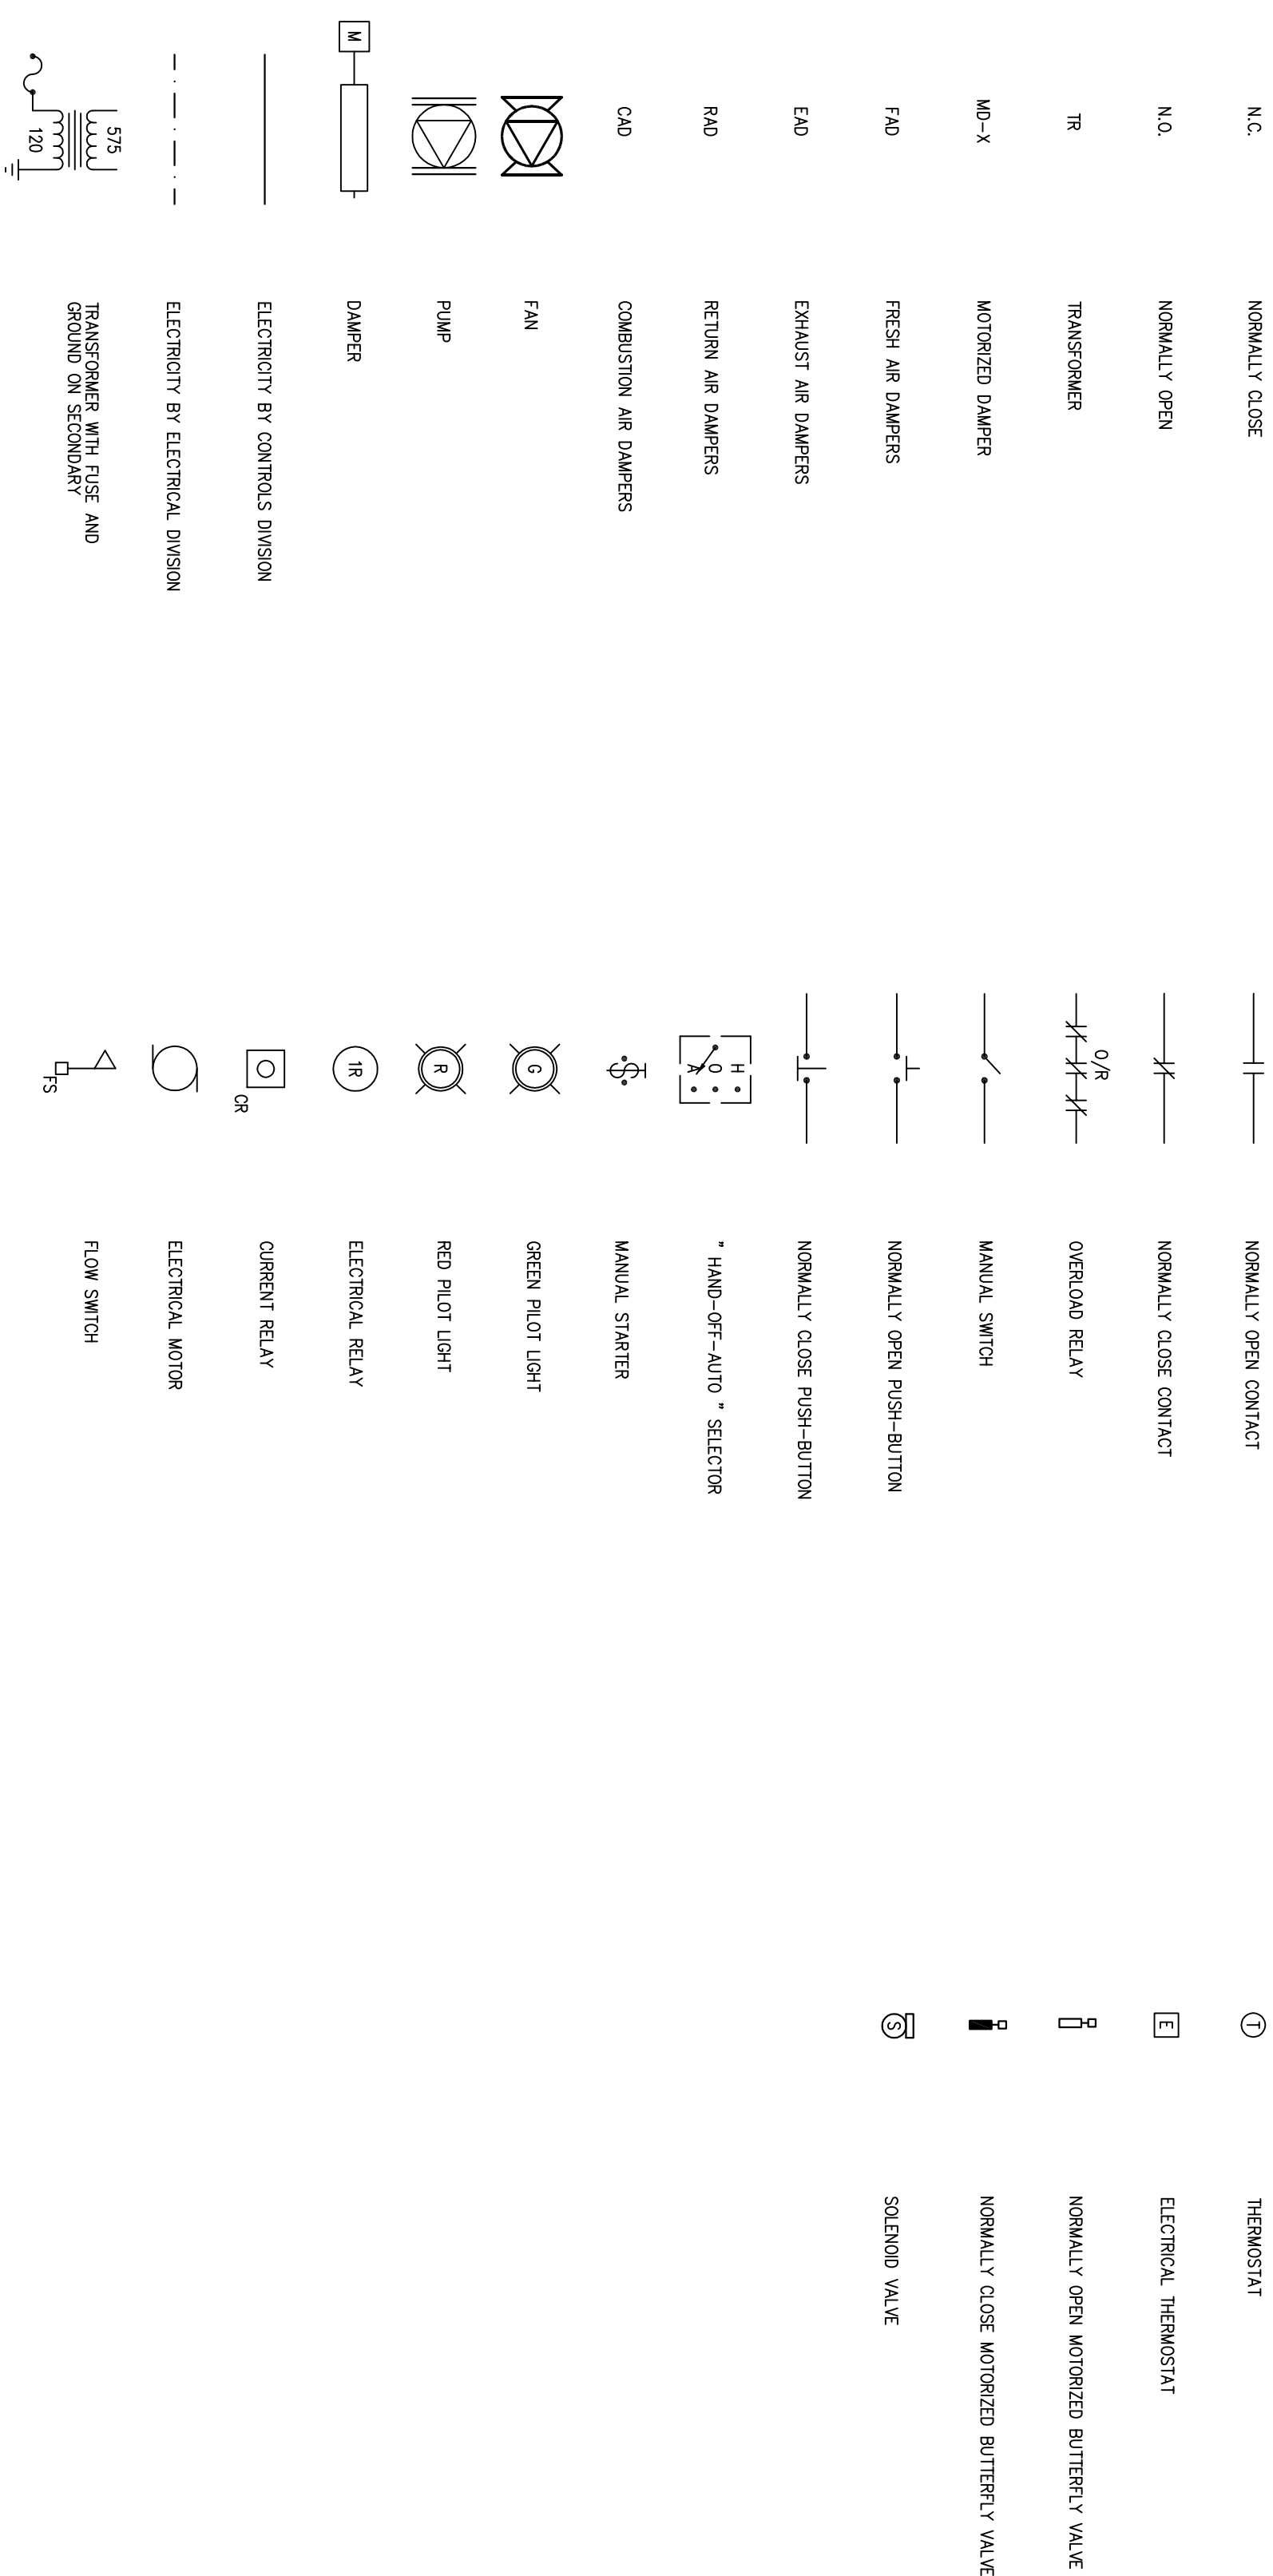

CORAL HARBOUR, NUNAVUT
NEW PUMPING STATION

MECHANICAL LEGEND AND DRAWING LIST

designed by	J.C.S.	project no.	8011-116
drawn by	J.C.S.	drawing no.	M100
checked by	P.C.		
date	DECEMBER 2013		
	N.T.S.		

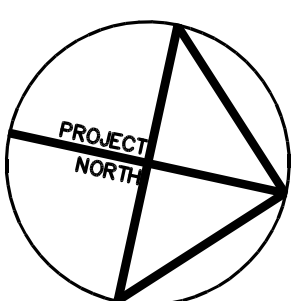

NOTES: GENERAL CONTRACTOR TO VERIFY ALL DIMENSIONS WITH FINAL ARCHITECTURAL AND MECHANICAL DRAWINGS. NOTIFY THE ENGINEERS OF ANY ERRORS AND/OR OMISSIONS PRIOR TO CONSTRUCTION FOR DIRECTION. DO NOT SCALE THIS DRAWING.

3	ISSUED FOR 90% REVIEW	06/12/2013			
2	ISSUED FOR 75% REVIEW	22/03/2013			
1	ISSUED FOR REVIEW	03/01/2013			
No.	DESCRIPTION	DATE	BY	APP'D	
R E V I S I O N S					

Ottawa :
100-1960 Robertson Road, Suite 100, K2H 5B9
T.(613) 596.6454 F.(613) 596.3346
www.bpp.co

 Gallinau :
430, de l'hôpital bid., suite 210, J8Y 1T7
T.(819) 778.2448 F.(819) 778.5031

-bpp

Consulting Engineers



CLIENT
GOVERNMENT OF NUNAVUT
DEPARTMENT OF COMMUNITY
AND GOVERNMENT SERVICES

designed by	J.C.S.	project no.	8011-116
drawn by	J.C.S.	drawing no.	M100
checked by	P.C.		
date	DECEMBER 2013		