



GRISE FIORD TANK #1 REPAIRS

GRISE FIORD

NUNAVUT

LOCATION PLAN

SCALE: NTS



PROJECT NO.: 20220-00658

ISSUED FOR CONSTRUCTION


LIST OF DRAWINGS

YGZ04-M010 LOCATION PLAN AND DRAWINGS LIST

MECHANICAL:

ISSUED FOR CONSTRUCTION

YGZ04-M100	LEGEND AND SYMBOLS	REV.1	JUNE/22
YGZ04-M150	MECHANICAL DEMOLITION P.&I.D.	REV.1	JUNE/22
YGZ04-M200	MECHANICAL P.&I.D.	REV.1	JUNE/22
YGZ04-M300	MECHANICAL EQUIPMENT LIST	REV.1	JUNE/22

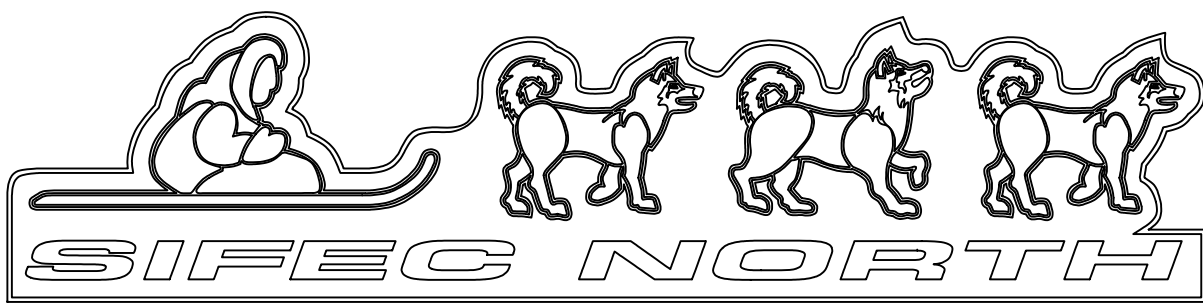

P.O. Box 556
Rankin Inlet, Nunavut
X0C 0G0
Tel: 855-437-4001
E-Mail: info@sifec.ca


LIST OF REFERENCE DRAWINGS

MECHANICAL:


ELECTRICAL:

COVER NO.	REV.	REV. DATE
YGZ04-M010	1	JUNE 2022


STANDARD LINE ACCESSORIES

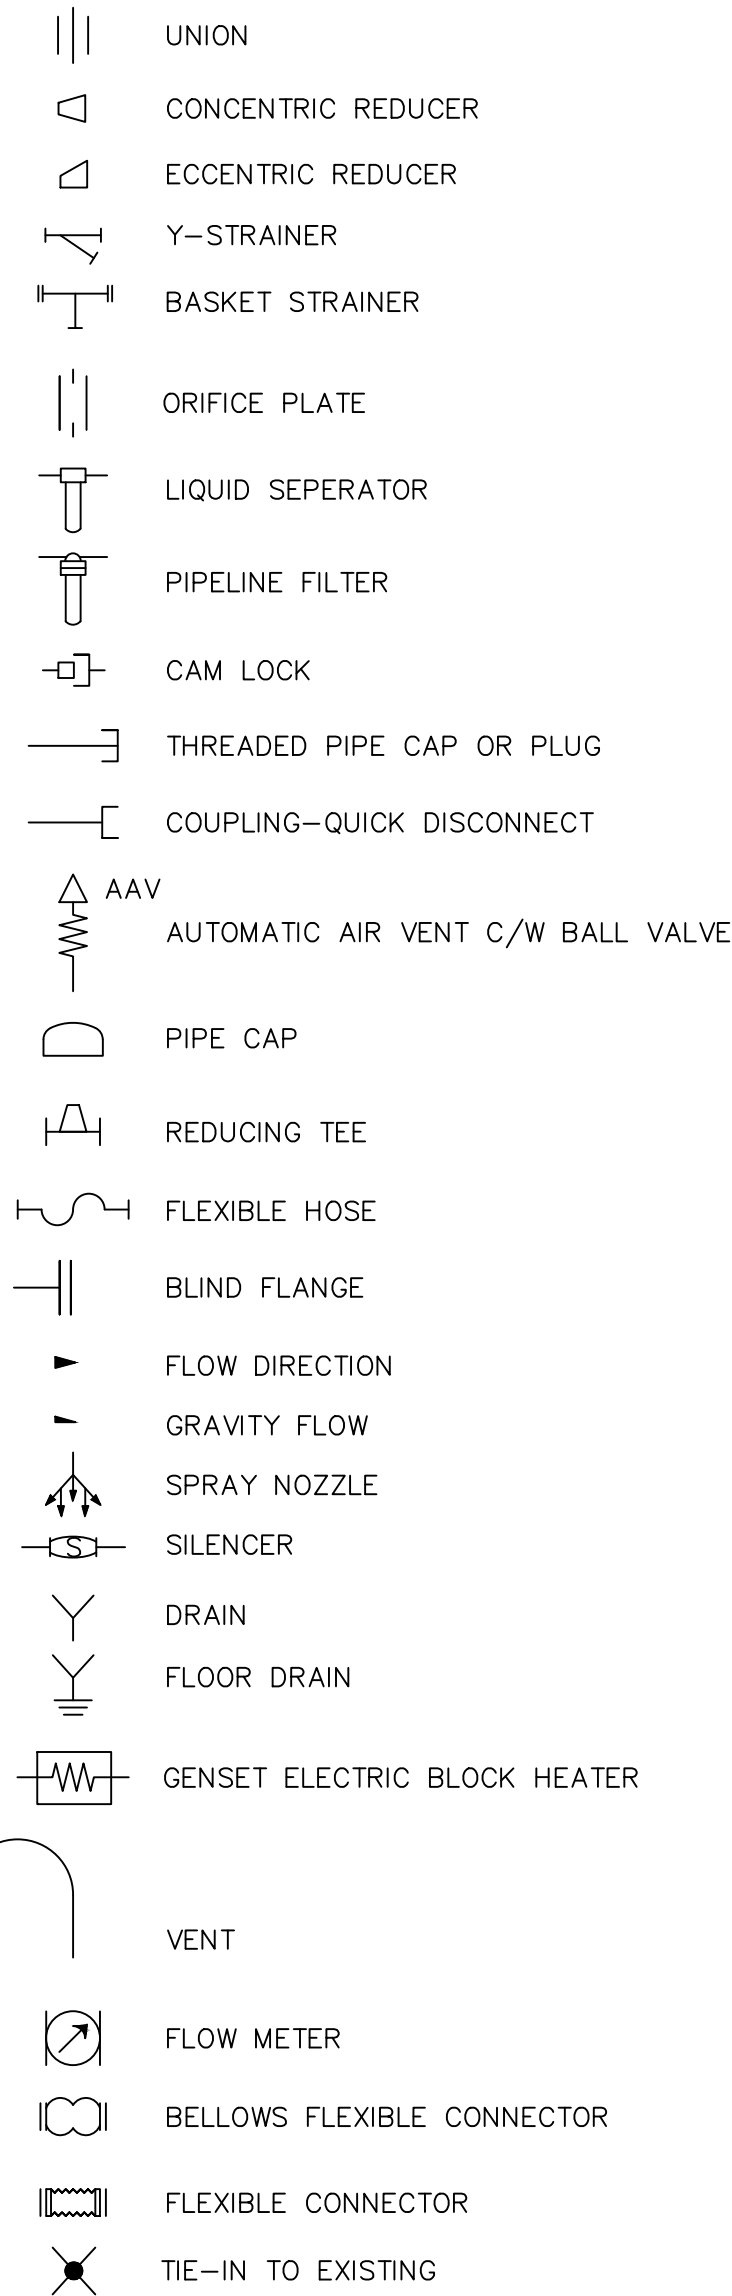


STANDARD VALVE ACTUATOR SYMBOLS

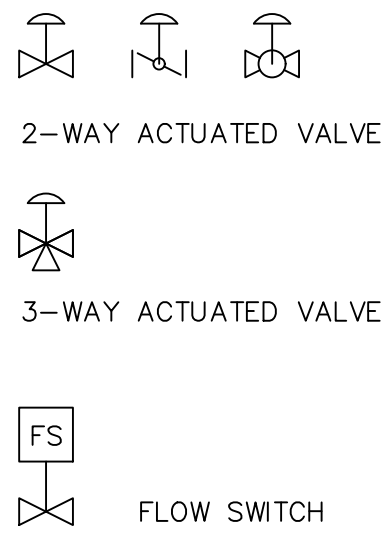


STANDARD VALVE BODY

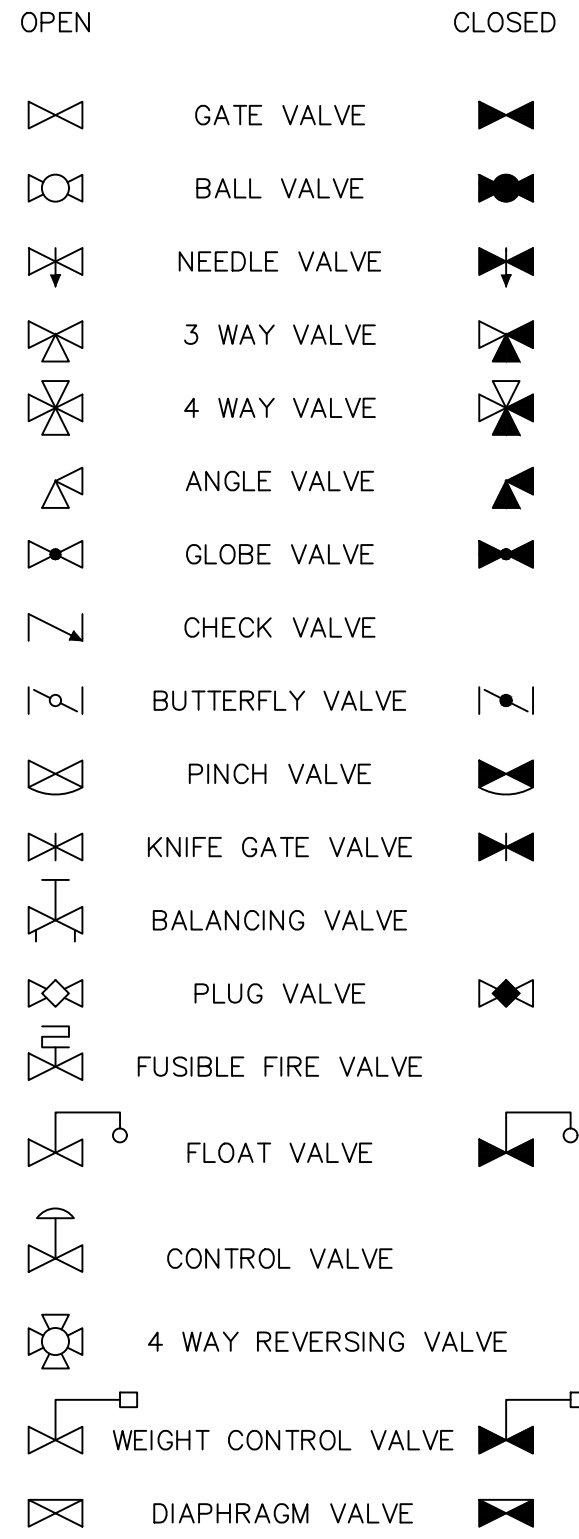


VALVE NUMBERING CONVENTION

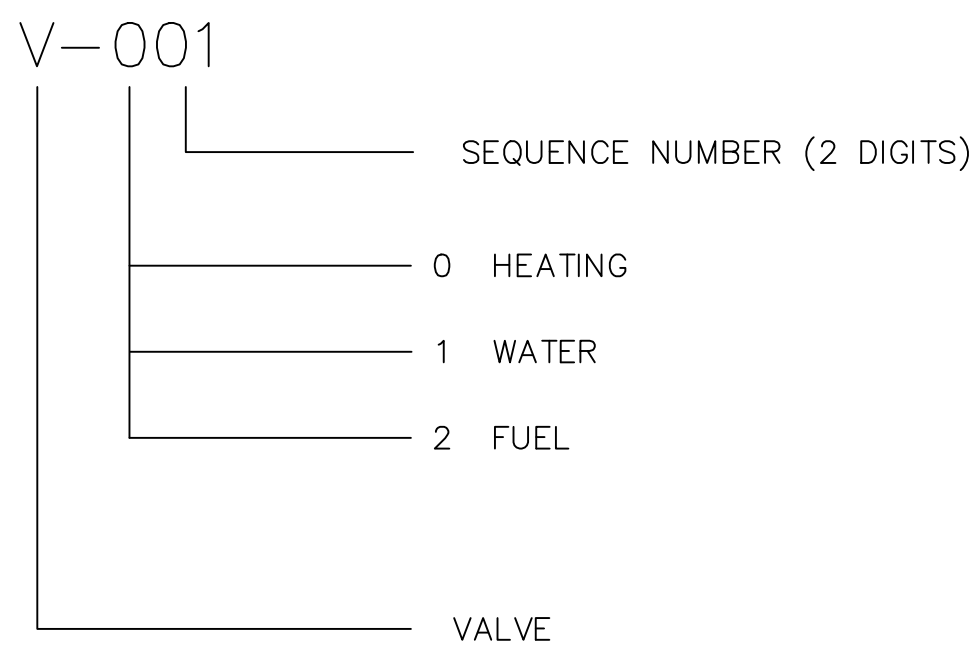


MISC. LINES AND SYMBOLS

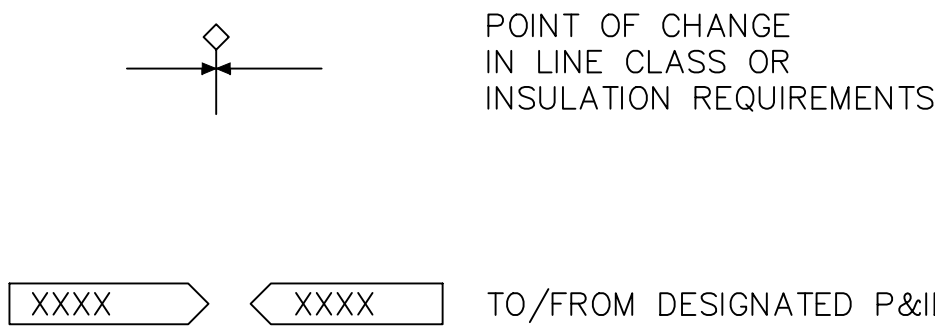


GAUGE & INSTRUMENTATION

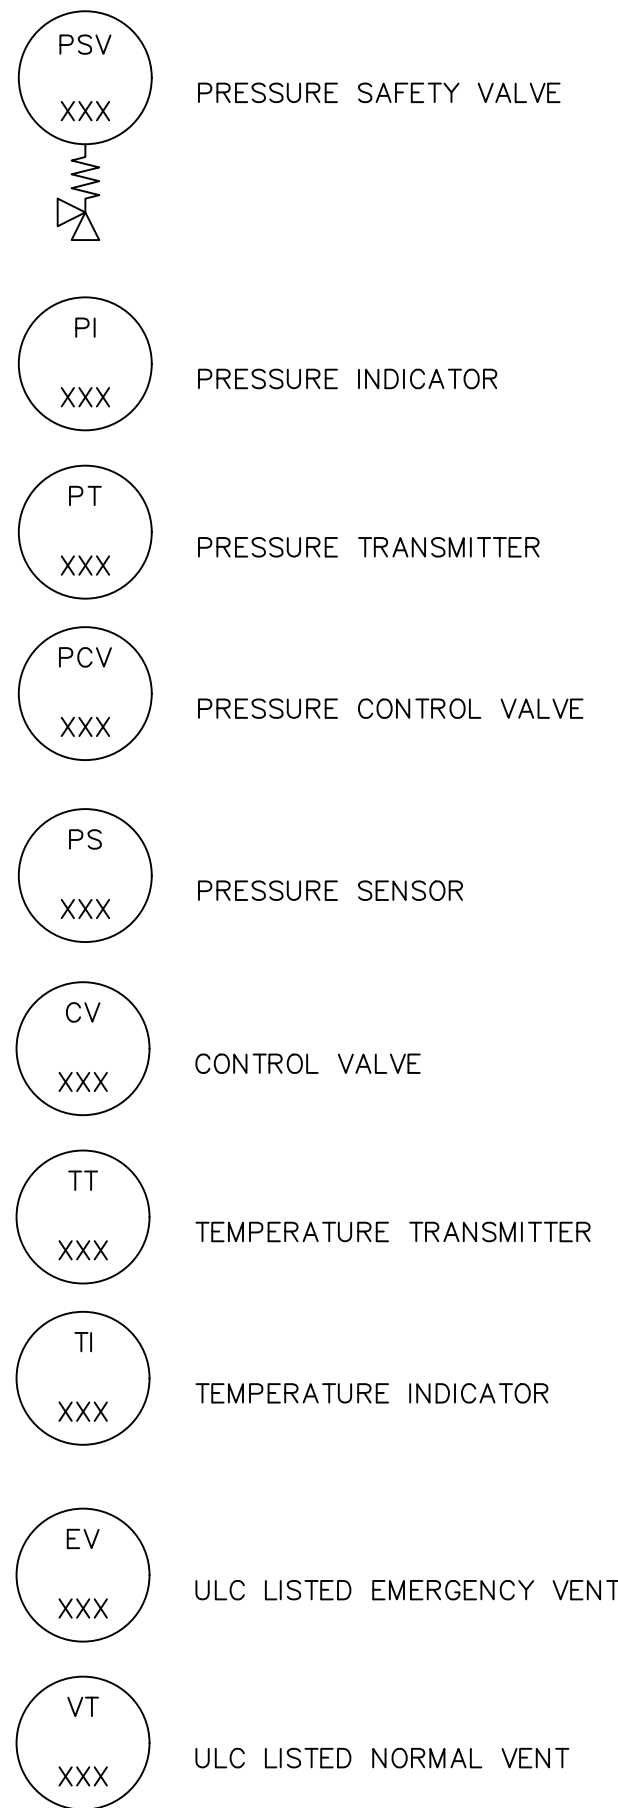

PLUMBING AND DRAINAGE SYMBOLS

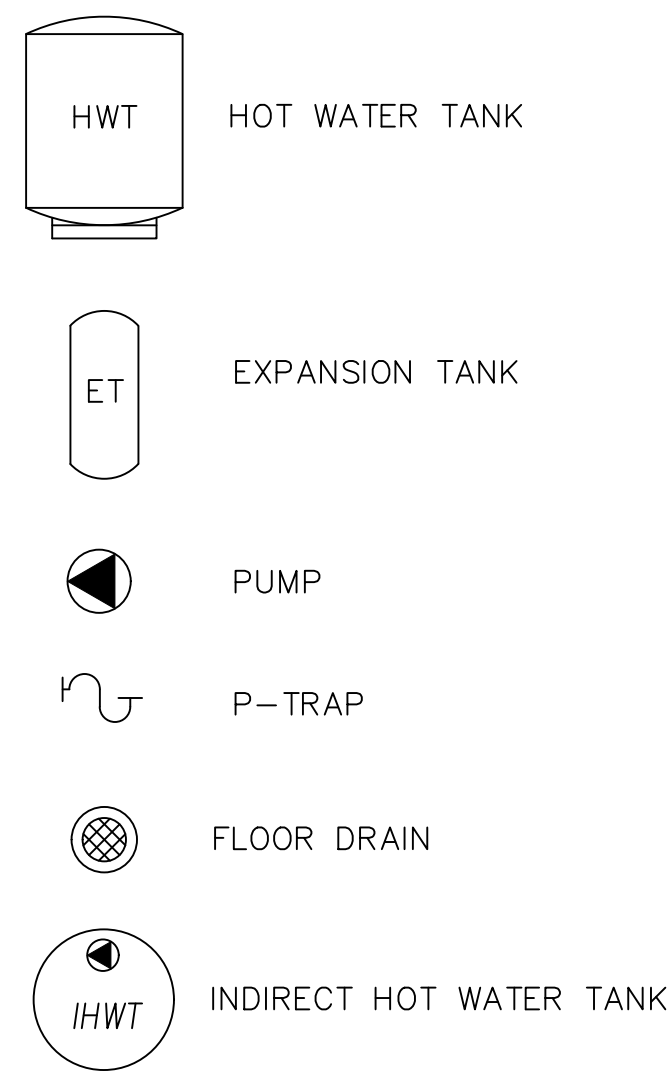

HVAC SYMBOLS

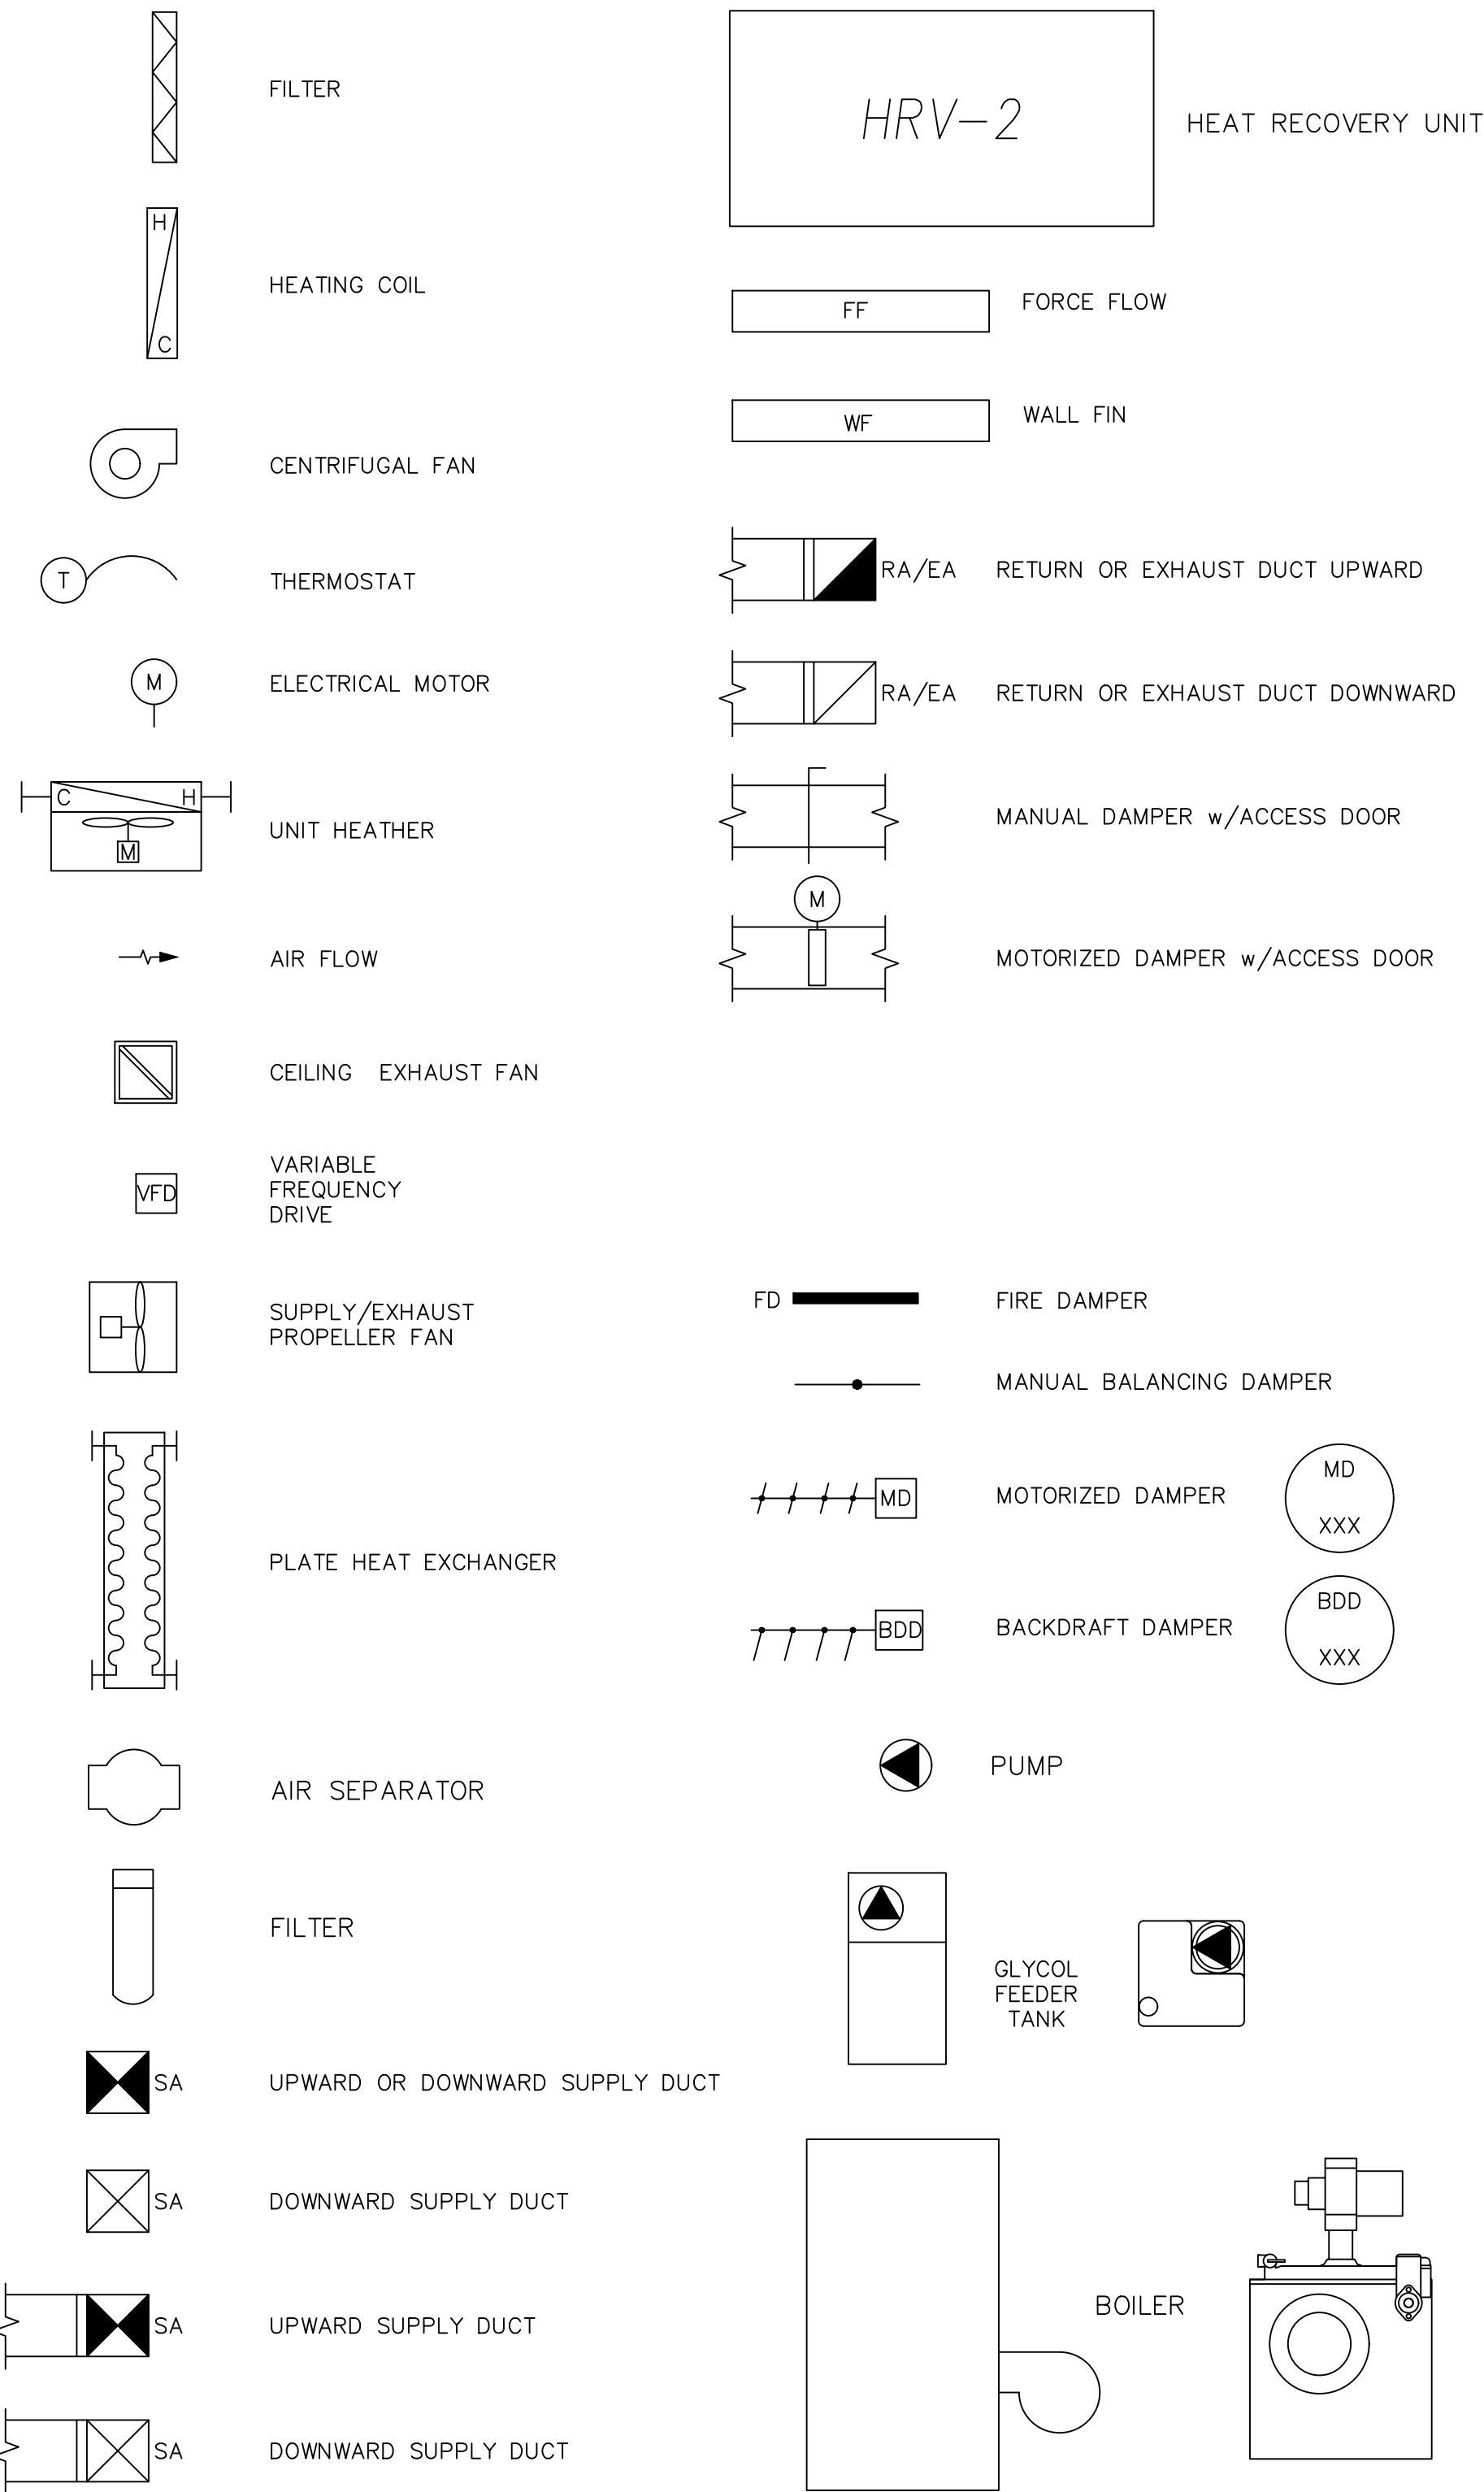


REVISION LETTER	REVISION	PROJECT NUMBER	NAME	DATE	CHECKED BY	DESIGNED BY
1	NEW SYMBOL ADDITION	20220-00658	MH	MAY/22	RF	MH/CF
0	50% DESIGN REVIEW	20220-00658	MH	MAY/22	RF	MH/CF



LOCATION GRISE FIORD NUNAVUT				
TITLE GRISE FIORD WATER TANK #1 REPAIRS LEGEND AND SYMBOLS				
SCALE N.T.S.	SHEET 1 OF 1	DRAWING NO. YG204-M100	REV. 1	REV. DATE JUNE/22

SAVE DATE: JUN/7/2022 5:12:31

FILENAME: \\72-20.0.14\PROJECT\3\FEC\Y0204 - GRISE FIORD TANK NO.1\DWG\FC\Y0204-M150-IFC-REF_07-06-2022.DWG

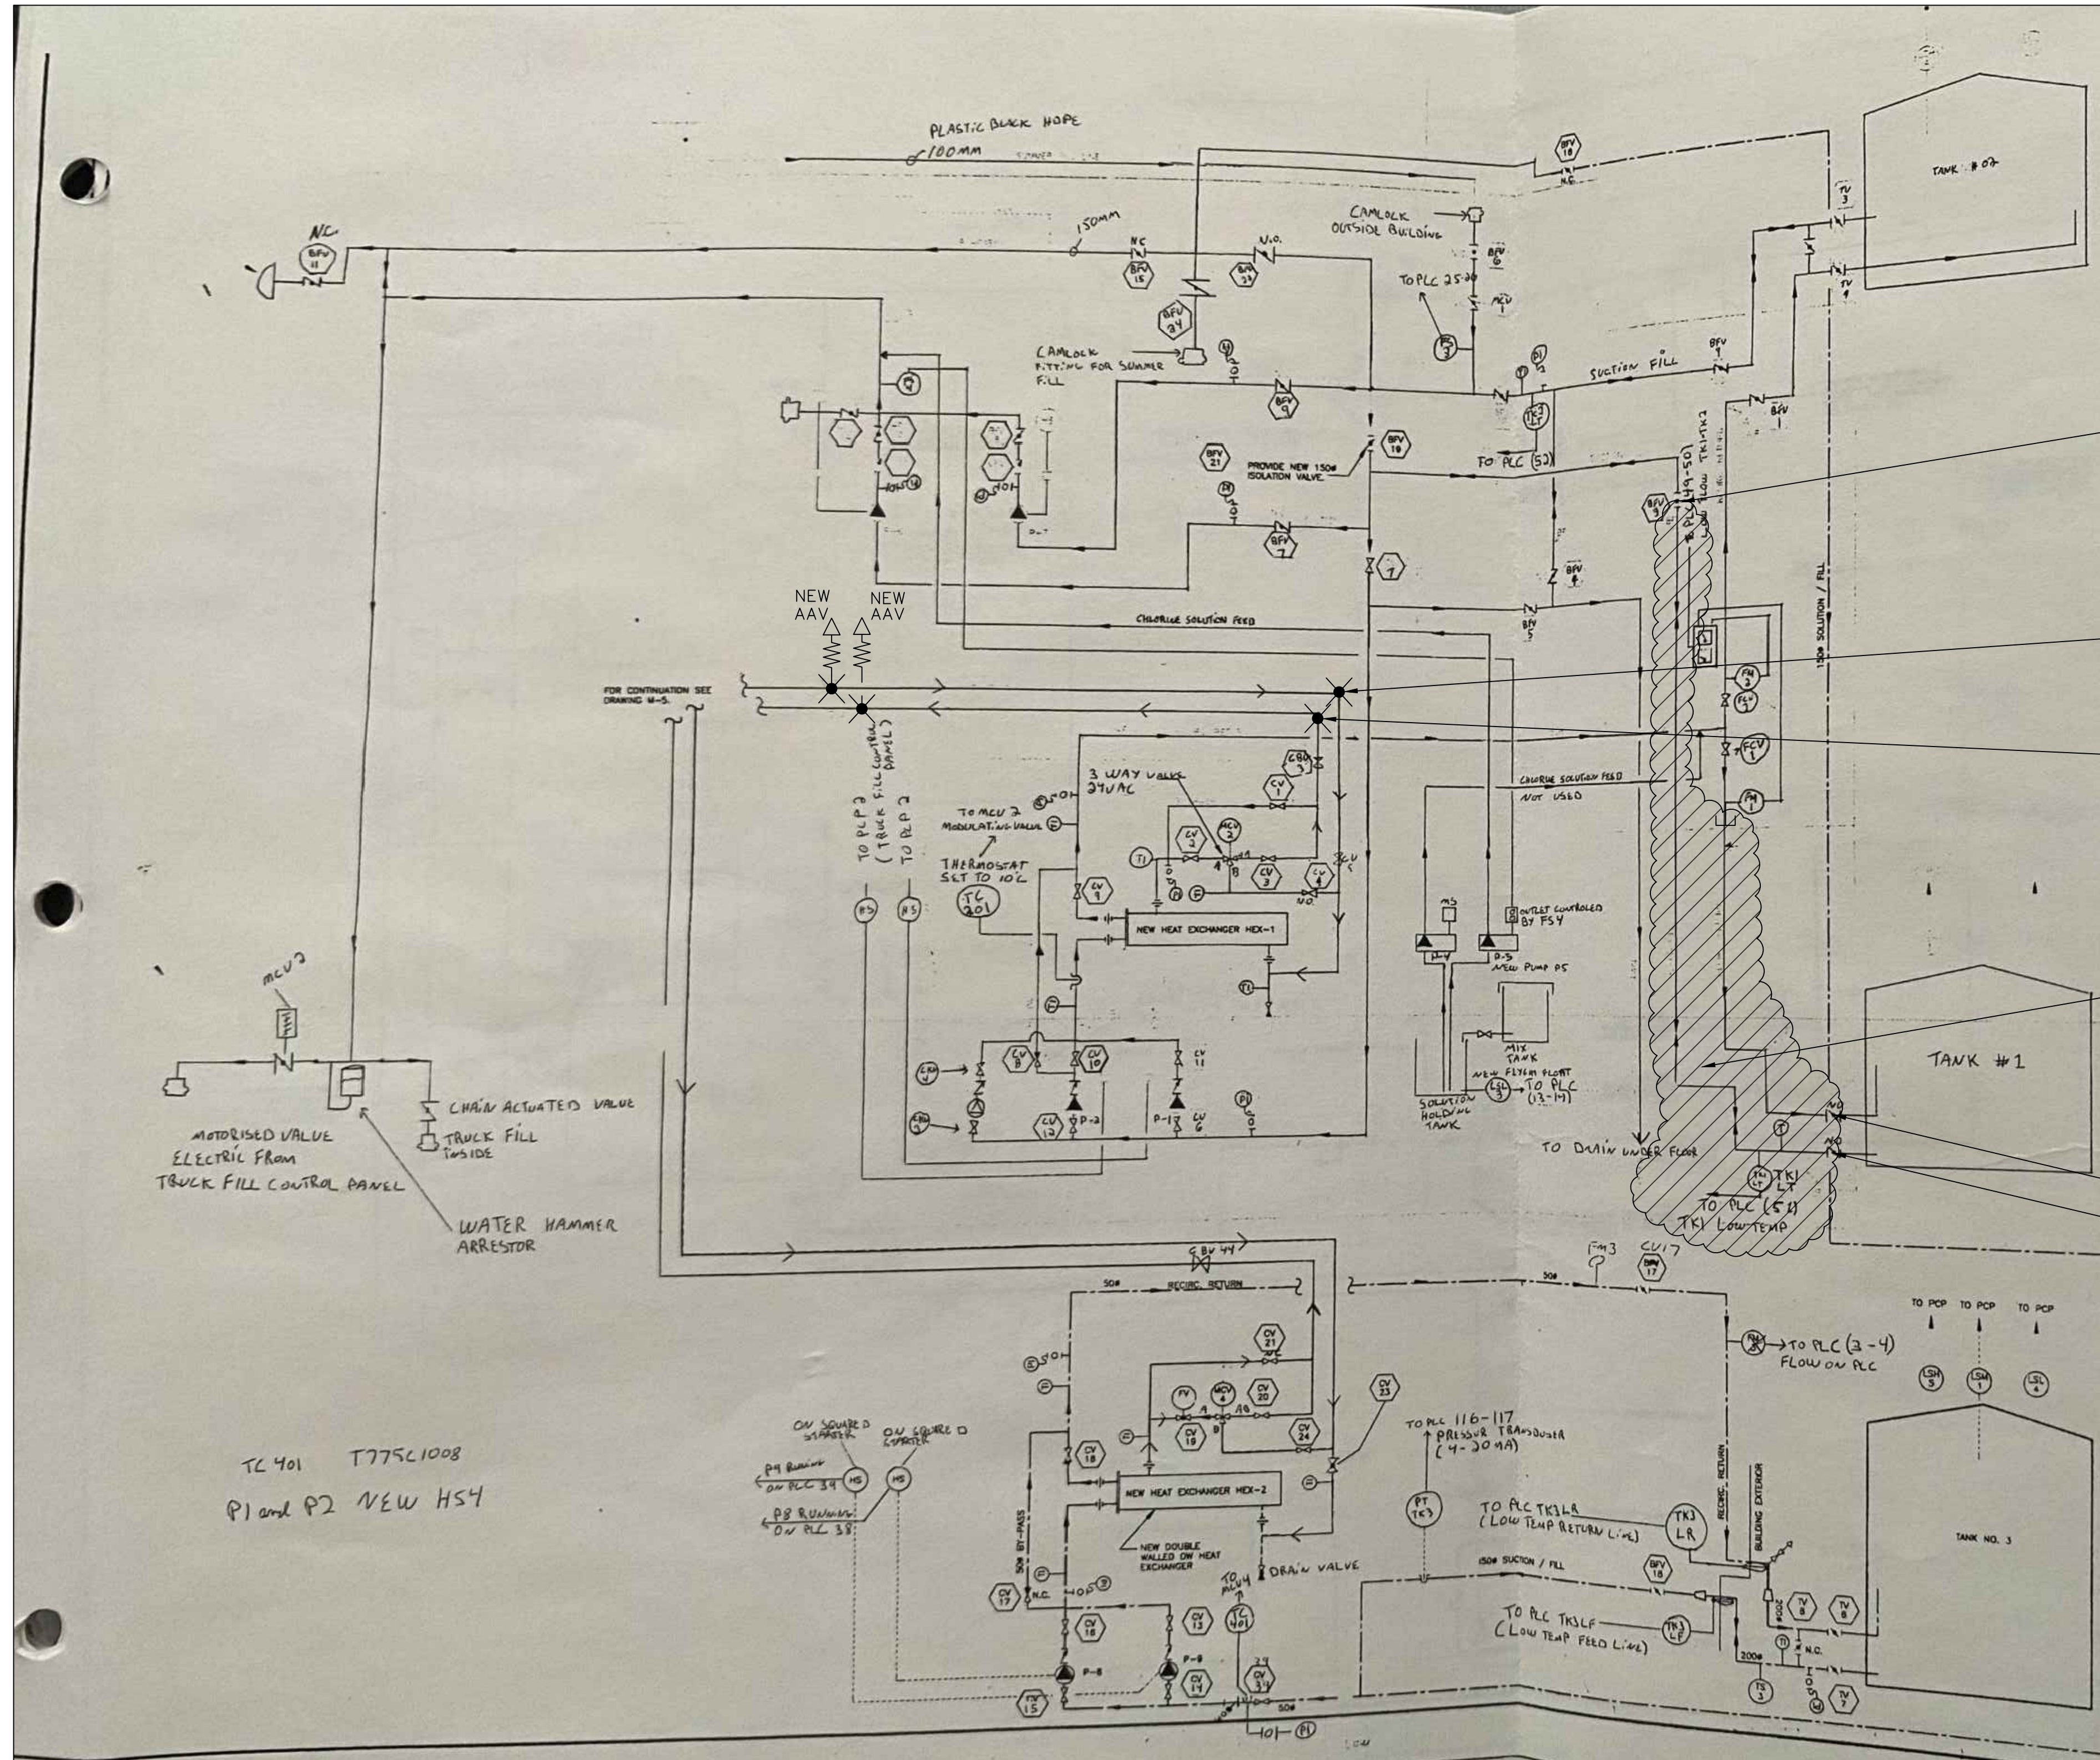

✕ TIE-IN TO EXISTING

EXISTING 4" BUTTERFLY VALVE TO REMAIN

NEW TEE HOT SIDE HYDRONIC TIE-IN REFER TO PLAN M200

NEW TEE HOT SIDE HYDRONIC TIE-IN REFER TO PLAN M200




OLD CARBON STEEL PIPE SECTION TO BE REMOVE AND REPLACED AS PER PLAN M200

NEW 2" BUTTERFLY VALVE
NEW 4" BUTTERFLY VALVE

TL 401 T775C1008
P1 and P2 NEW HS4

ON SQUARE 3
ON SQUARE 4
ON SQUARE 5
ON SQUARE 100


REVISION LETTER	REVISION	PROJECT NUMBER	NAME	DATE	CHECKED BY	DESIGNED BY
1	DEMOLITION PLAN	20220-00658	MH	JUNE/22	RF	MH/CF
0	50% DESIGN REVIEW	20220-00658	MH	MAY/22	RF	MH/CF

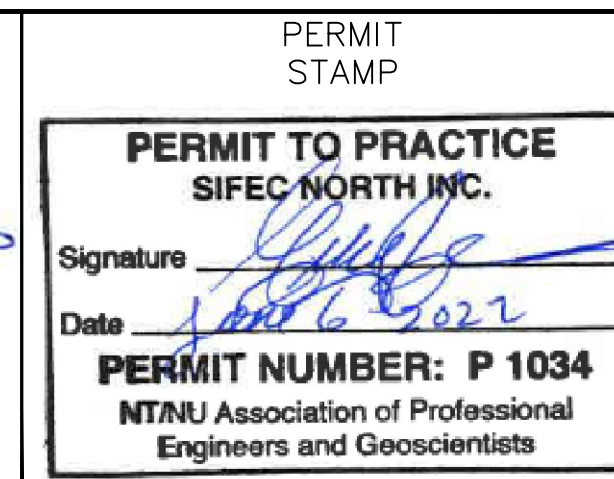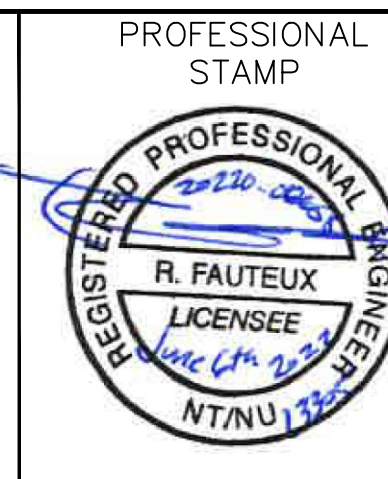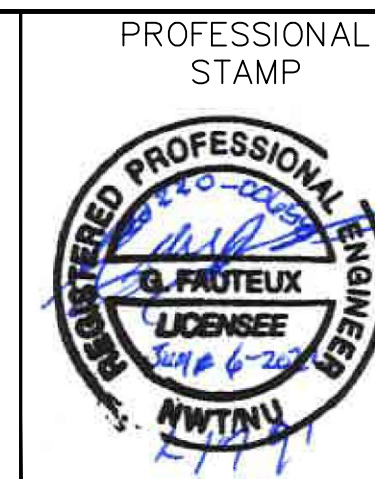

LOCATION		GRISE FIORD NUNAVUT	
TITLE		GRISE FIORD WATER TANK #1 REPAIRS DEMOLITION MECHANICAL P.&I.D.	
SCALE	SHEET	DRAWING NO.	REV.
N.T.S.	1 OF 1	YGZ04-M150	1
REV. DATE		JUNE/22	

SAVE DATE: JUN/7/2022 5:12:29

FILENAME: \\72-20.0.14\PROJECT\GISFEC\YGZ04 - GRISE FIORD TANK NO.1\DWG\FC\YGZ04-M200-IFC_RF_02-06-2022.DWG

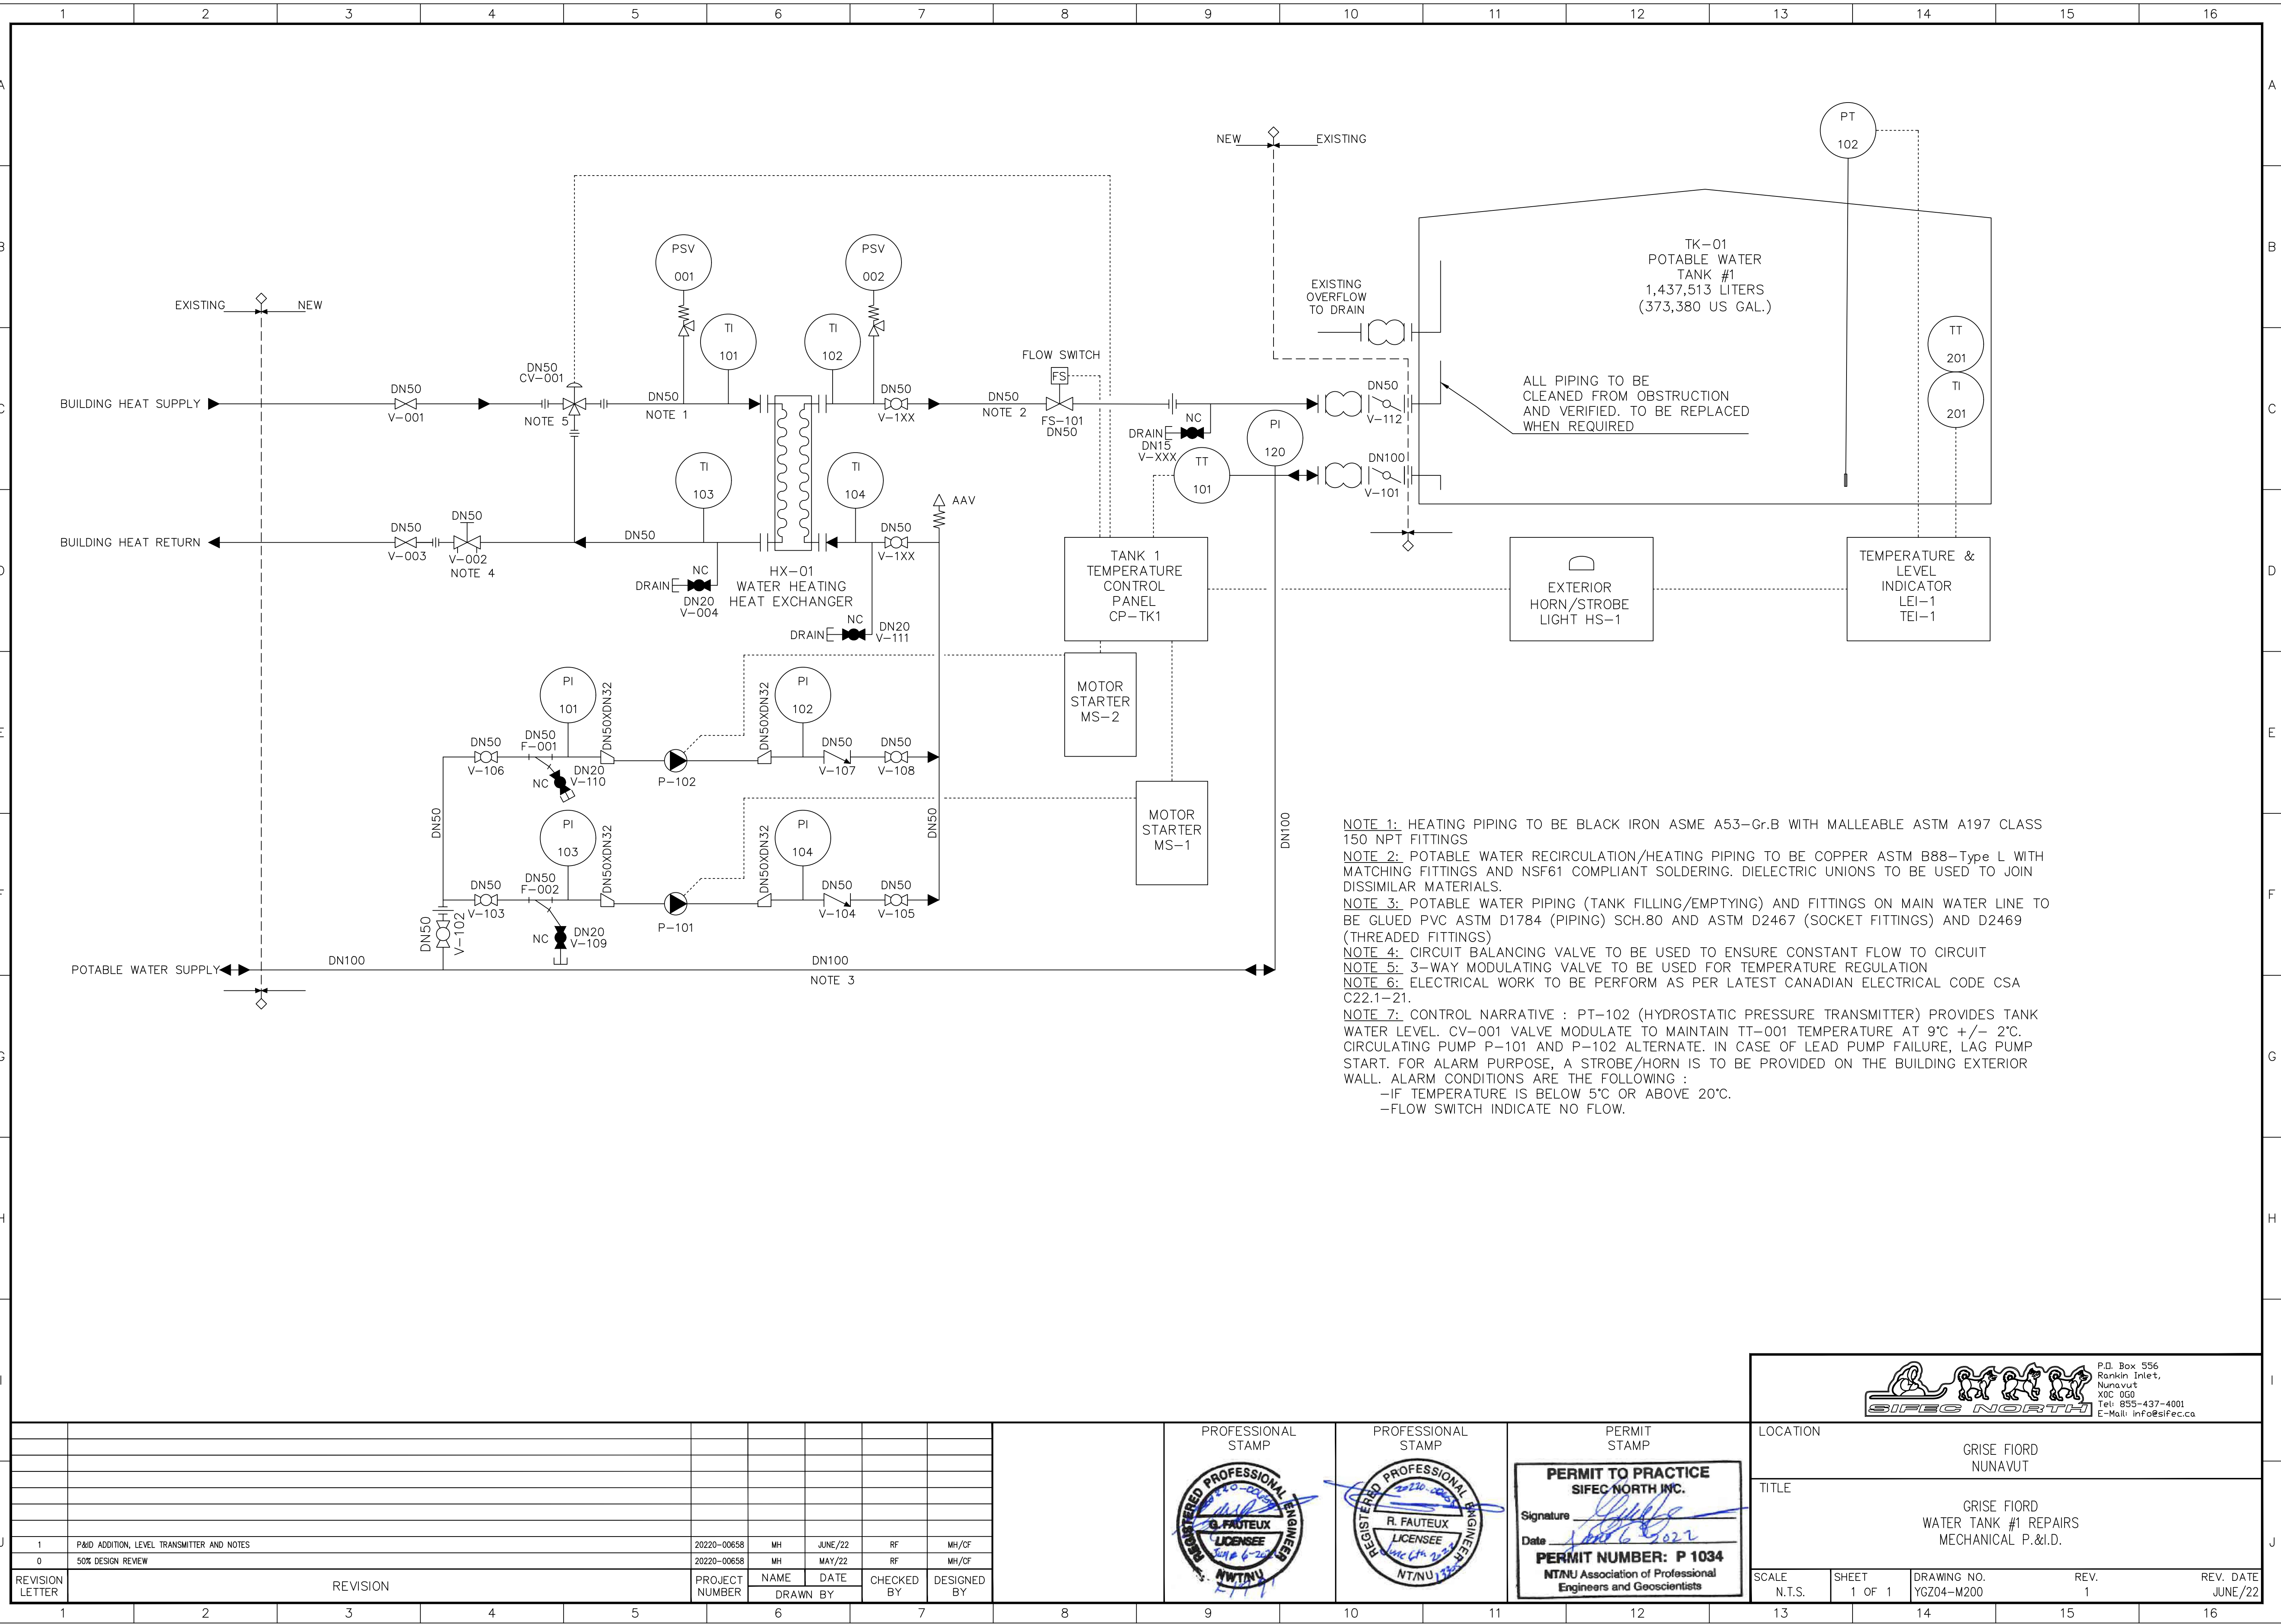

NOTE 1: HEATING PIPING TO BE BLACK IRON ASME A53-Gr.B WITH MALLEABLE ASTM A197 CLASS 150 NPT FITTINGS
NOTE 2: POTABLE WATER RECIRCULATION/HEATING PIPING TO BE COPPER ASTM B88-Type L WITH MATCHING FITTINGS AND NSF61 COMPLIANT SOLDERING. DIELECTRIC UNIONS TO BE USED TO JOIN DISSIMILAR MATERIALS.
NOTE 3: POTABLE WATER PIPING (TANK FILLING/EMPTYING) AND FITTINGS ON MAIN WATER LINE TO BE GLUED PVC ASTM D1784 (PIPING) SCH.80 AND ASTM D2467 (SOCKET FITTINGS) AND D2469 (THREADED FITTINGS)
NOTE 4: CIRCUIT BALANCING VALVE TO BE USED TO ENSURE CONSTANT FLOW TO CIRCUIT
NOTE 5: 3-WAY MODULATING VALVE TO BE USED FOR TEMPERATURE REGULATION
NOTE 6: ELECTRICAL WORK TO BE PERFORM AS PER LATEST CANADIAN ELECTRICAL CODE CSA C22.1-21.
NOTE 7: CONTROL NARRATIVE : PT-102 (HYDROSTATIC PRESSURE TRANSMITTER) PROVIDES TANK WATER LEVEL. CV-001 VALVE MODULATE TO MAINTAIN TT-001 TEMPERATURE AT 9°C +/- 2°C. CIRCULATING PUMP P-101 AND P-102 ALTERNATE. IN CASE OF LEAD PUMP FAILURE, LAG PUMP START. FOR ALARM PURPOSE, A STROBE/HORN IS TO BE PROVIDED ON THE BUILDING EXTERIOR WALL. ALARM CONDITIONS ARE THE FOLLOWING :
-IF TEMPERATURE IS BELOW 5°C OR ABOVE 20°C.
-FLOW SWITCH INDICATE NO FLOW.

REVISION LETTER	REVISION	PROJECT NUMBER	NAME	DATE	CHECKED BY	DESIGNED BY
1	P&ID ADDITION, LEVEL TRANSMITTER AND NOTES	20220-00658	MH	JUNE/22	RF	MH/CF
0	50% DESIGN REVIEW	20220-00658	MH	MAY/22	RF	MH/CF

PROFESSIONAL STAMP

PROFESSIONAL STAMP

PERMIT STAMP

PERMIT TO PRACTICE
SIFEC NORTH INC.

Signature: *[Signature]*
Date: *June 6, 2022*

PERMIT NUMBER: P 1034
NTNU Association of Professional Engineers and Geoscientists

		P.O. Box 556 Rankin Inlet, Nunavut X0C 0G0 Tel: 855-437-4001 E-Mail: info@sifec.ca	
LOCATION GRISE FIORD NUNAVUT			
TITLE GRISE FIORD WATER TANK #1 REPAIRS MECHANICAL P.&I.D.			
SCALE N.T.S.	SHEET 1 OF 1	DRAWING NO. YGZ04-M200	REV. 1
REV. DATE JUNE/22			

[illegible]