


GOVERNMENT OF NUNAVUT

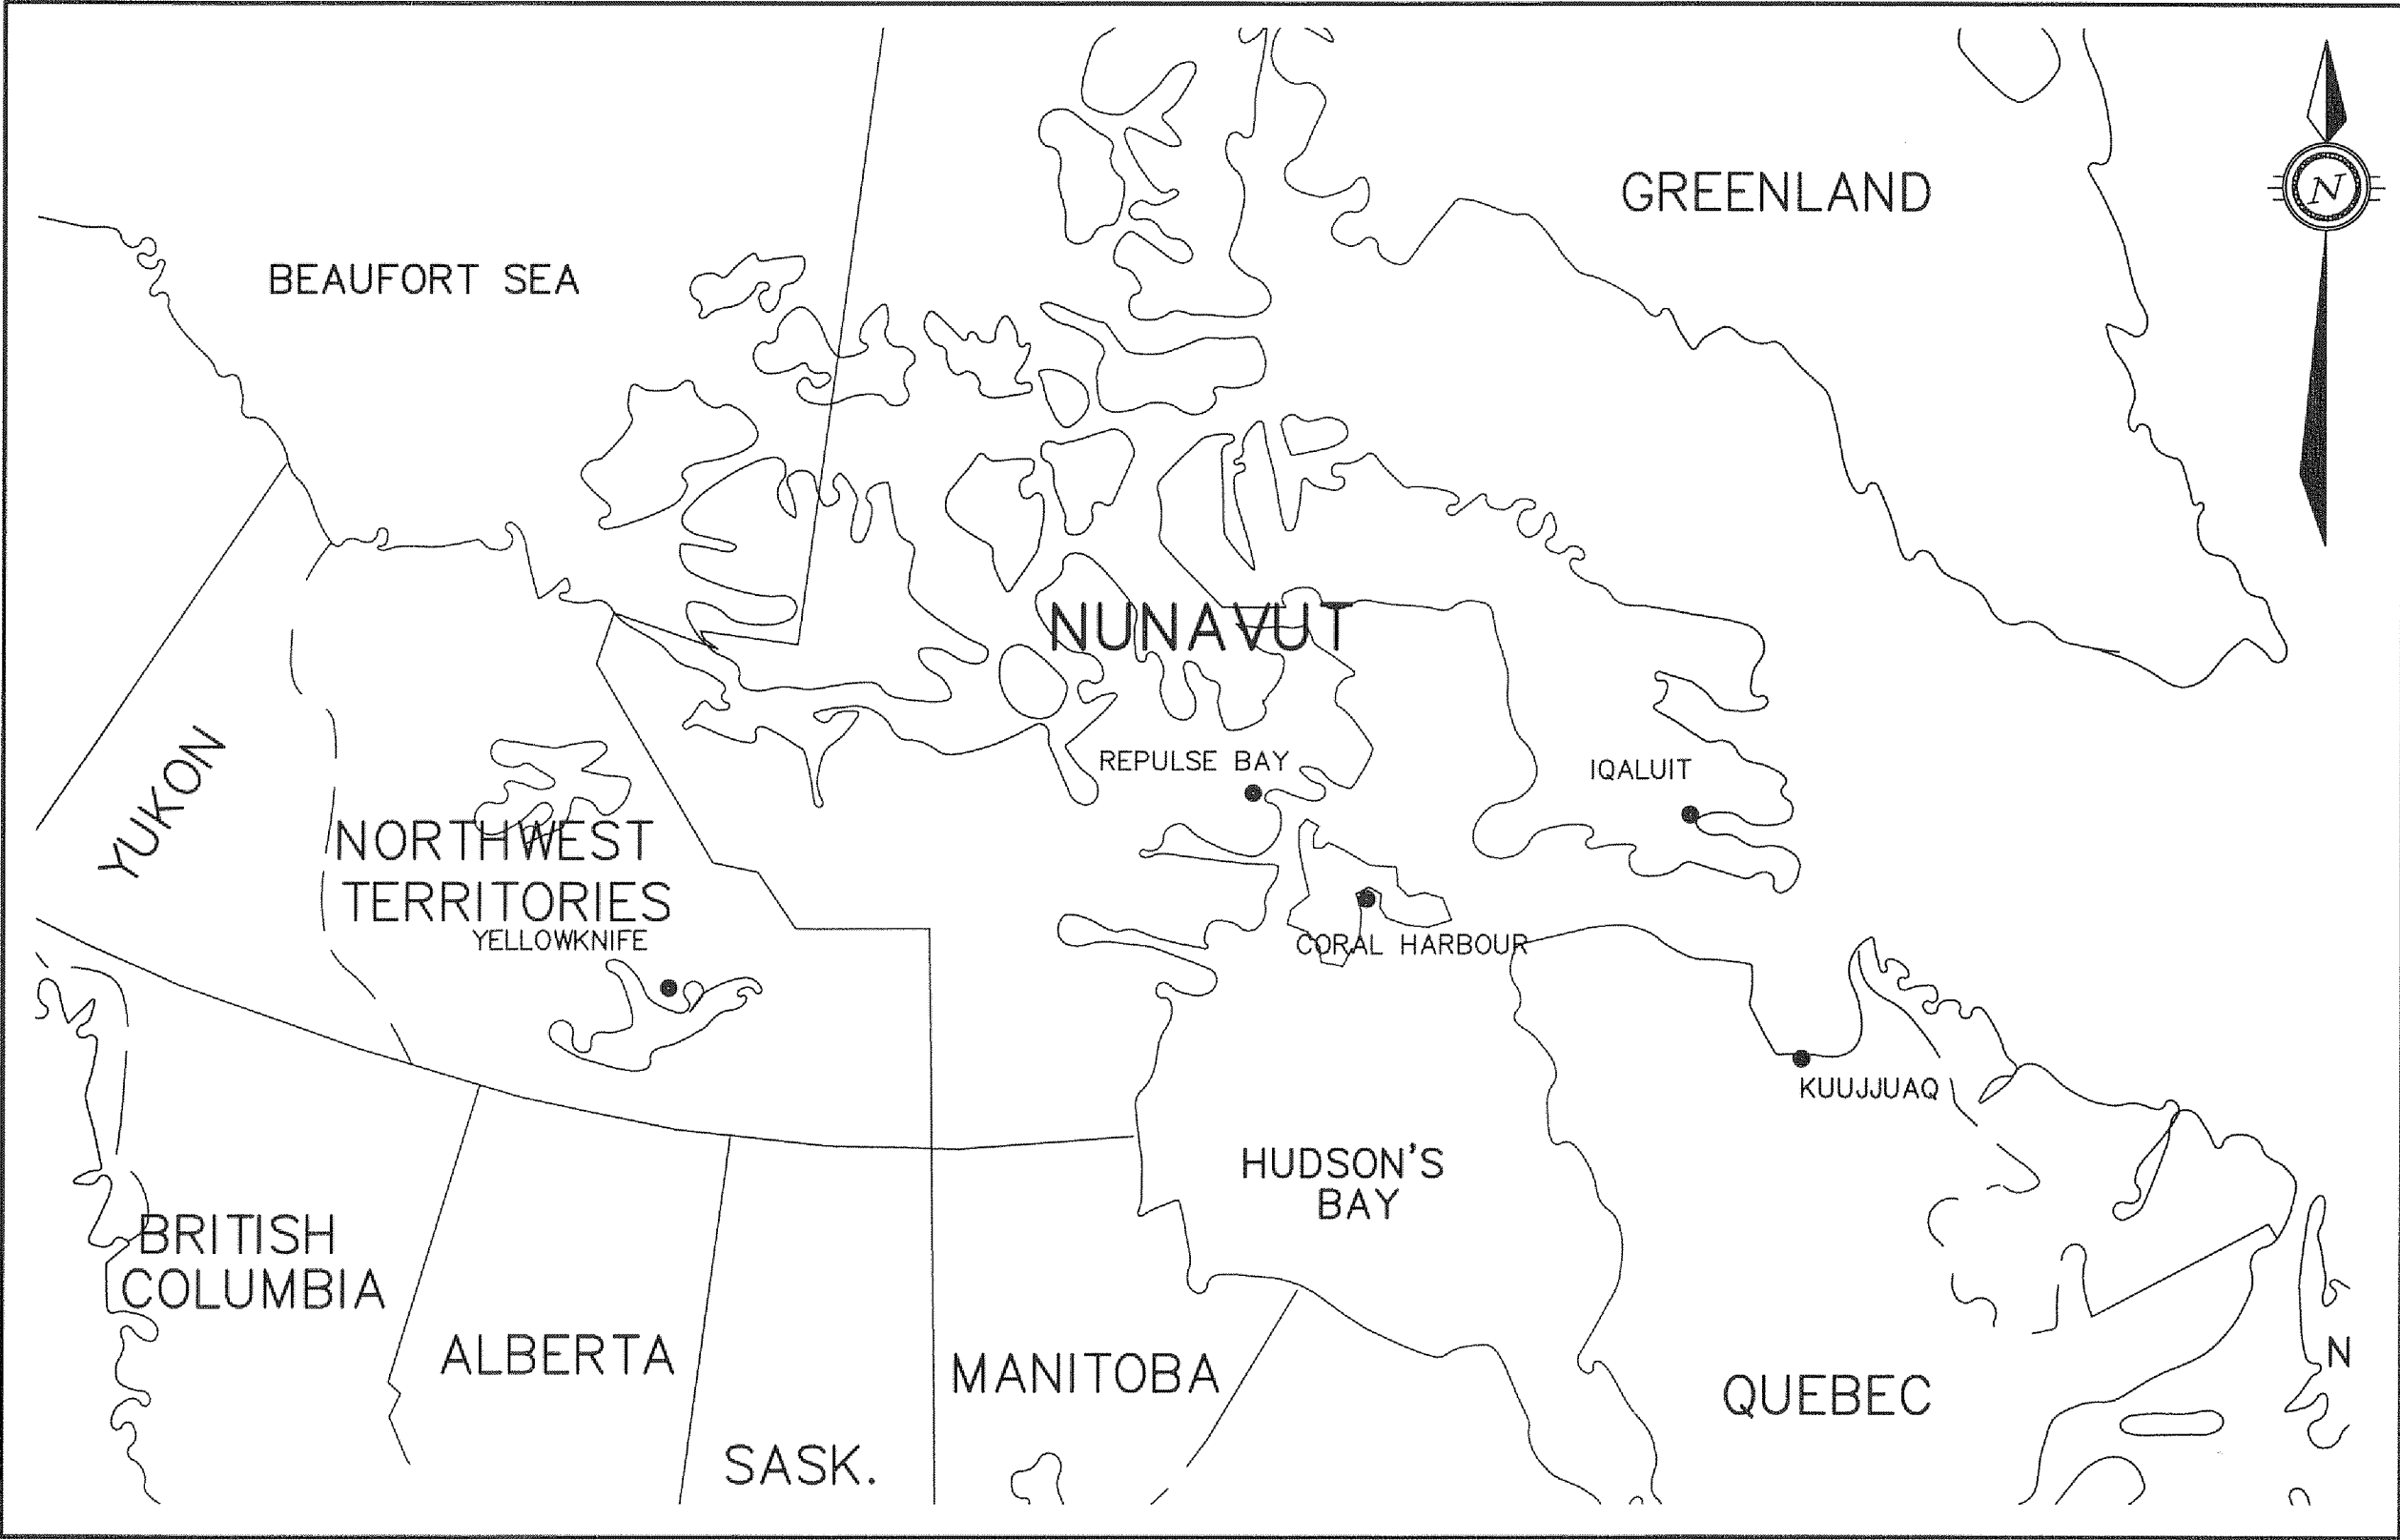

INDEX OF INCLUDED DRAWINGS

DRAWING NO.	REVISION	DESCRIPTION
COVER		
OTT-00208308A-C1	REV 0	SITE LOCATION PLAN
OTT-00208308A-C2	REV 0	PLAN & PROFILE
OTT-00208308A-C3	REV 0	DETAIL SHEET 1
OTT-00208308A-C4	REV 0	DETAIL SHEET 2
OTT-00208308A-S1	REV 0	GROUND FLOOR PLAN AND GENERAL NOTES
OTT-00208308A-S2	REV 0	FOUNDATION PLAN ROOF PLAN AND DETAILS
OTT-00208308A-S3	REV 0	BUILDING ELEVATIONS AND FILL PIPE DETAILS
OTT-00208308A-S4	REV 0	SECTIONS
OTT-00208308A-S5	REV 0	SECTIONS
OTT-00208308A-S6	REV 0	FUEL STORAGE TANK PLAN AND SECTIONS
8011-116-M100	REV 0	MECHANICAL LEGEND AND DRAWING LIST
8011-116-M101	REV 0	MECHANICAL DETAILS
8011-116-M200	REV 0	MECHANICAL PLUMBING LAYOUT
8011-116-M201	REV 0	MECHANICAL PLUMBING SCHEMATIC
8011-116-M300	REV 0	MECHANICAL FUEL SYSTEM LAYOUT
8011-116-M301	REV 0	MECHANICAL FUEL SYSTEM SCHEMATIC
8011-116-M500	REV 0	MECHANICAL VENTILATION LAYOUT
8011-116-M600	REV 0	MECHANICAL CONTROLS SCHEMATIC
8011-116-E1	REV 0	ELECTRICAL NEW POWER AND LIGHTING LAYOUT
8011-116-E2	REV 0	ELECTRICAL SINGLE LINE DIAGRAM

TENDER ISSUE

DATE: FEBRUARY 10, 2014

REPULSE BAY NEW WATER PUMP HOUSE PROJECT 12-3002



exp Services Inc.
t: +1.613.688.1899 | f: +1.613.225.7337
2650 Queensview Drive, Suite 100
Ottawa, ON K2B 8H6
Canada

www.exp.com

• BUILDINGS • EARTH & ENVIRONMENT • ENERGY •
• INDUSTRIAL • INFRASTRUCTURE • SUSTAINABILITY •