
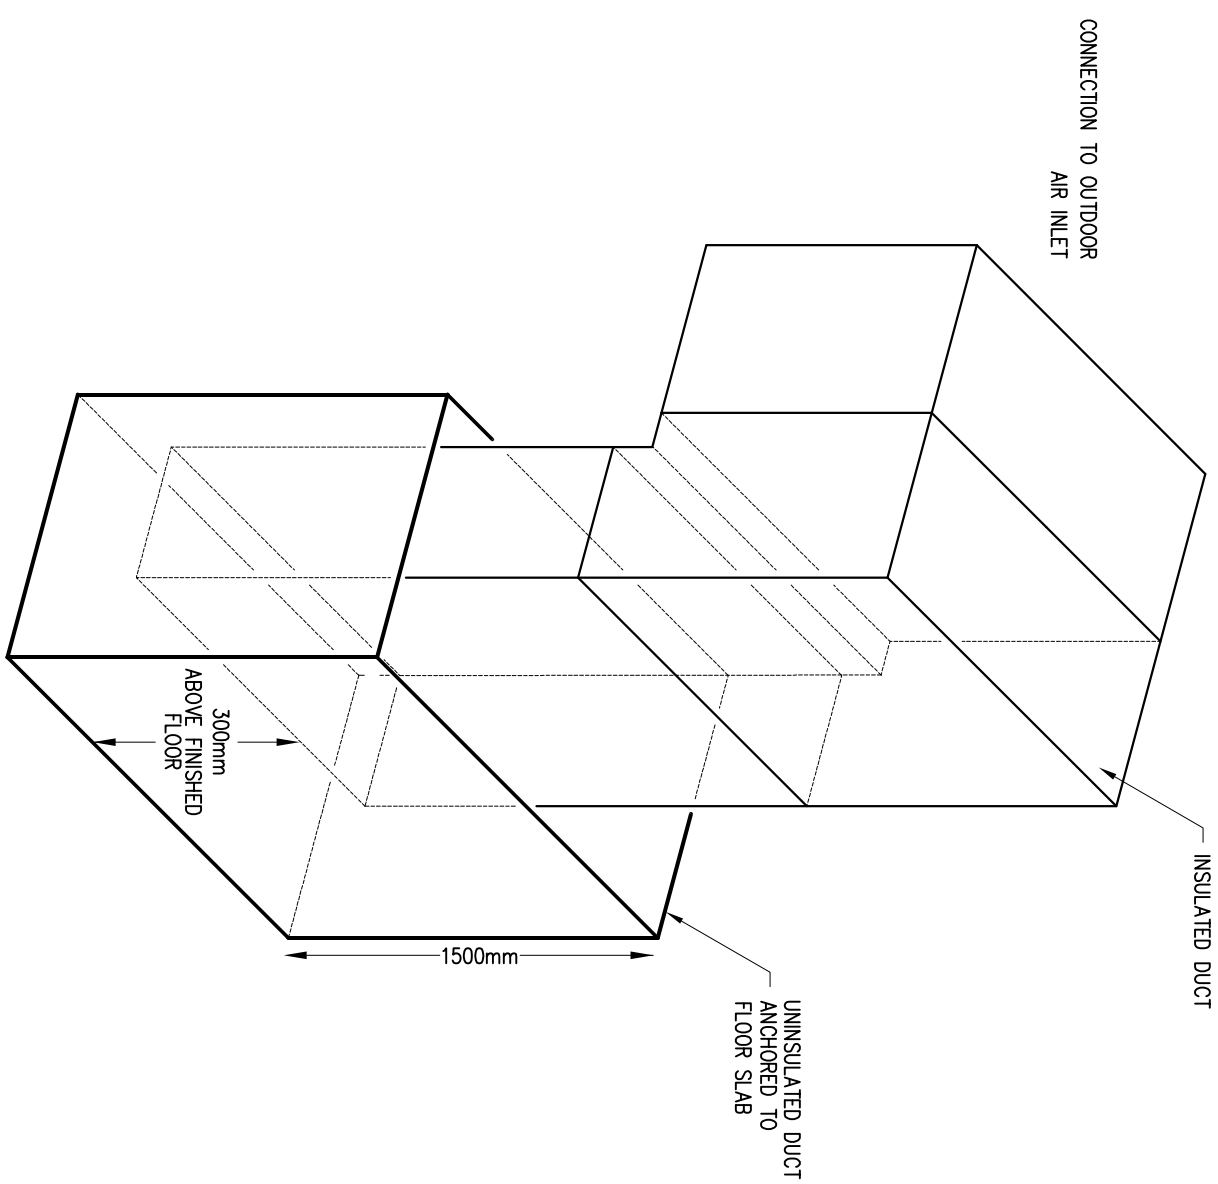
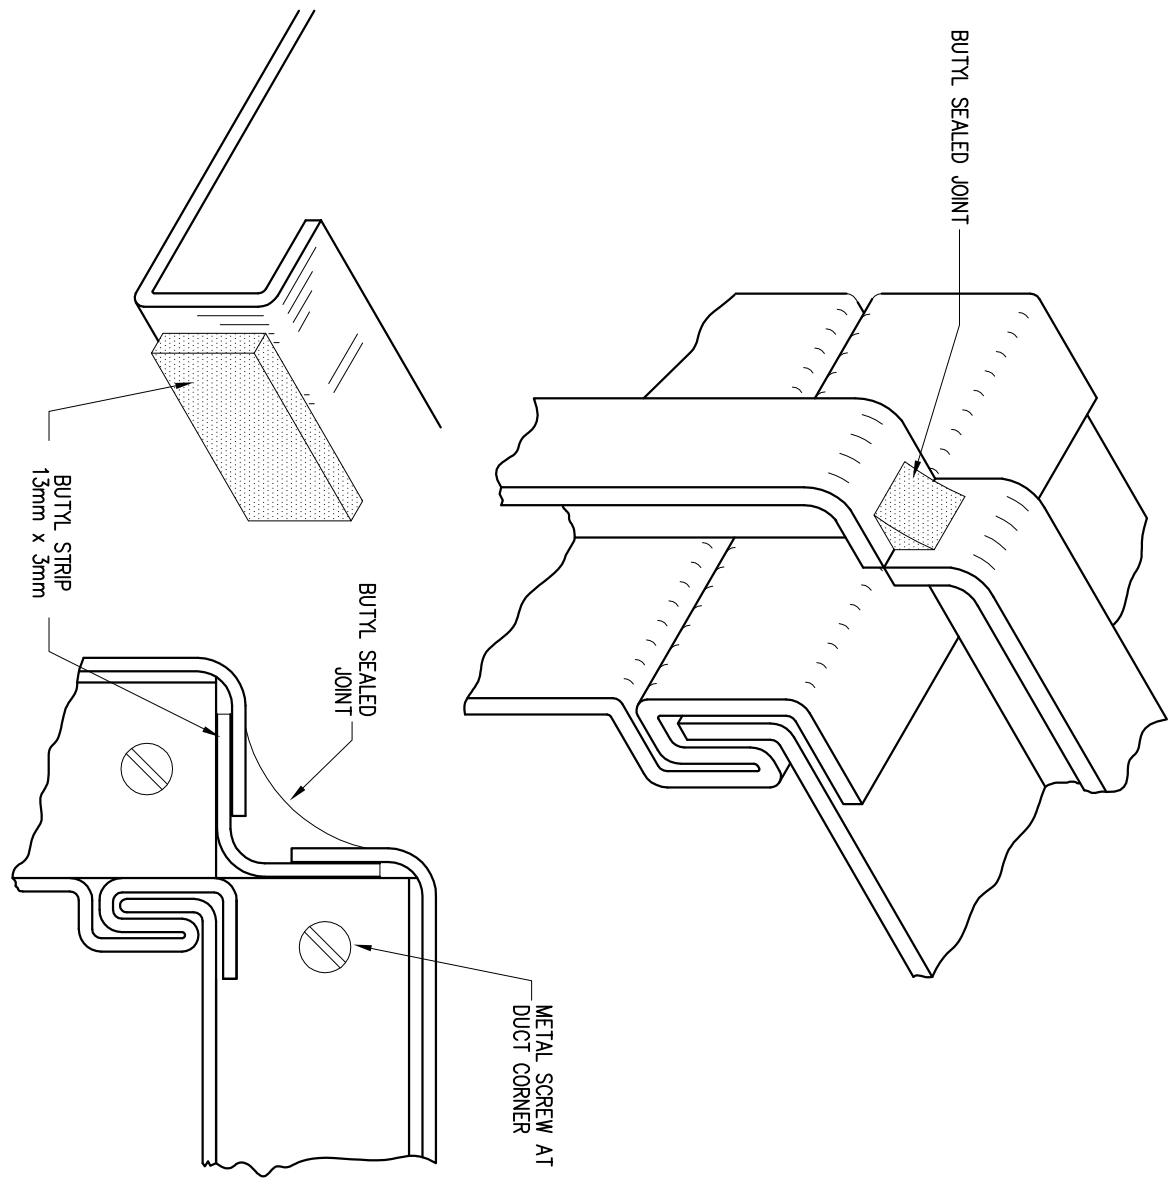





CROSS JOINT AND REINFORCEMENT FOR LOW PRESSURE RECTANGULAR DUCT ^(NTS)

TYPICAL COMBUSTION AIR INLET DETAIL
(N15)

SEALED JOINT FOR LOW PRESSURE RECTANGULAR DUCT (N15)

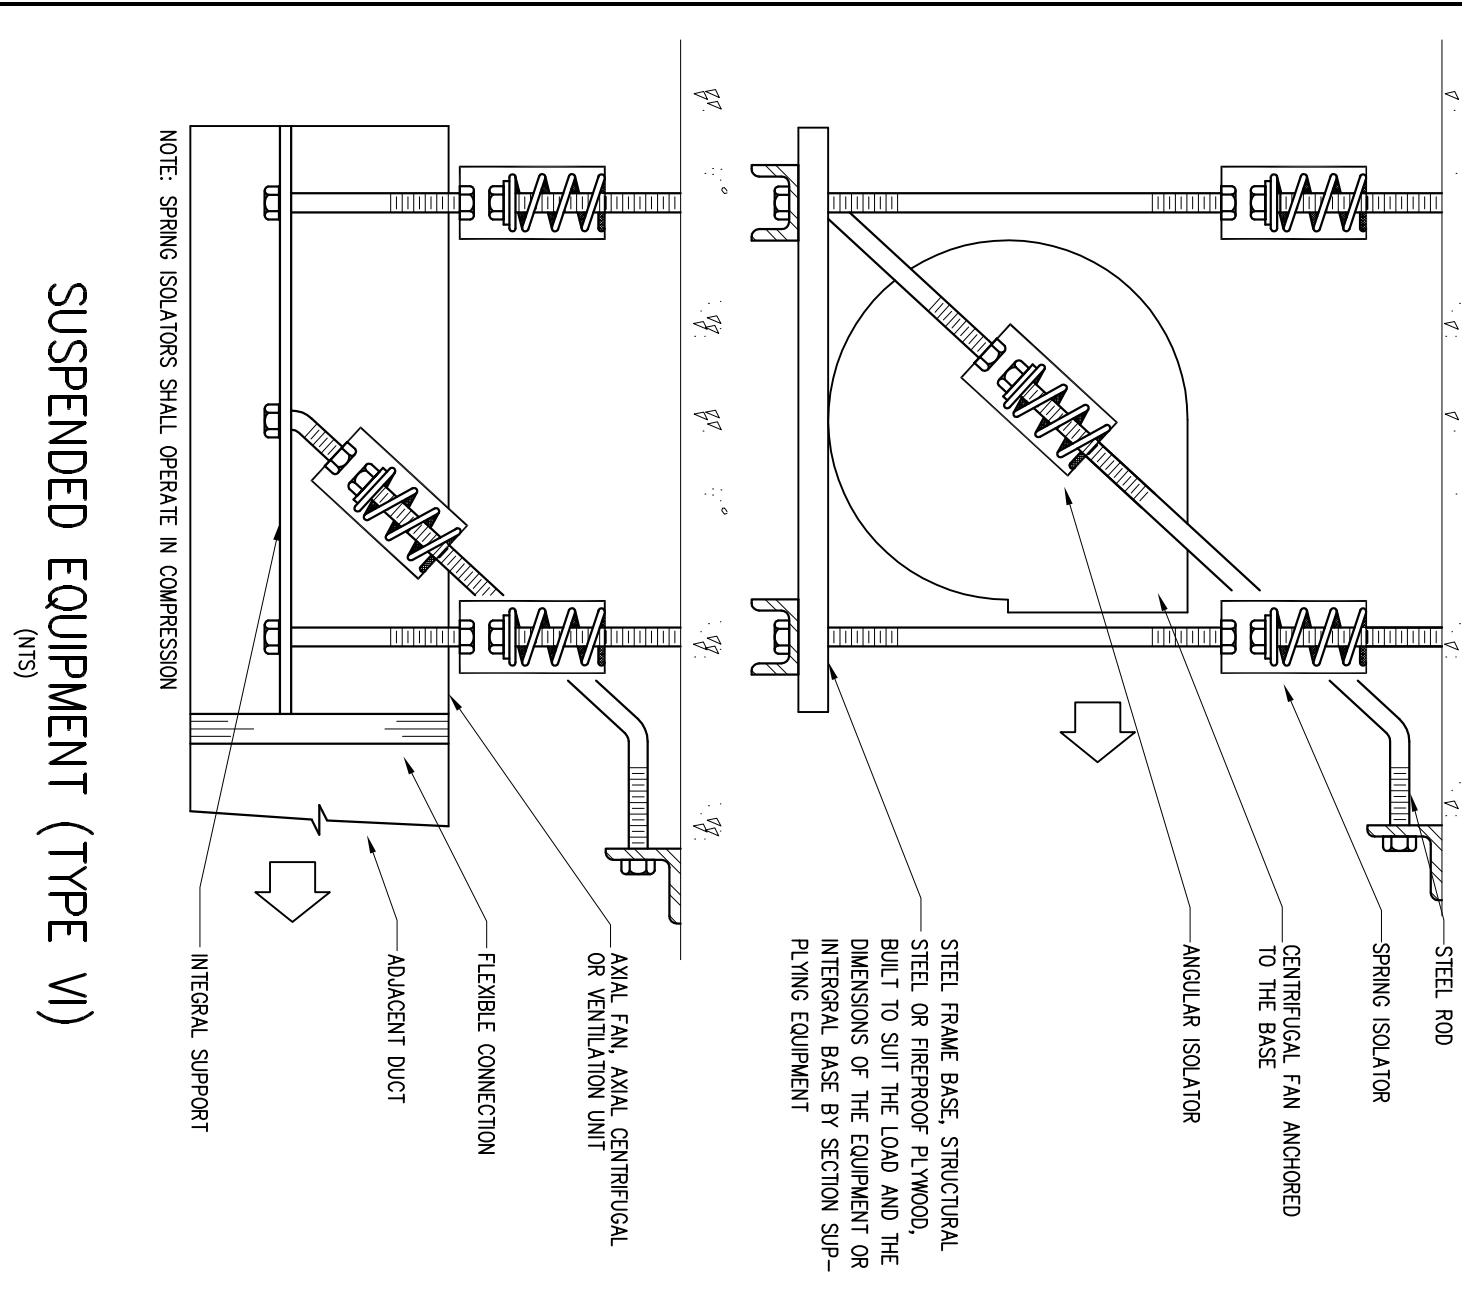


SUSPENDED EQUIPMENT (TYPE VI)
(N15)

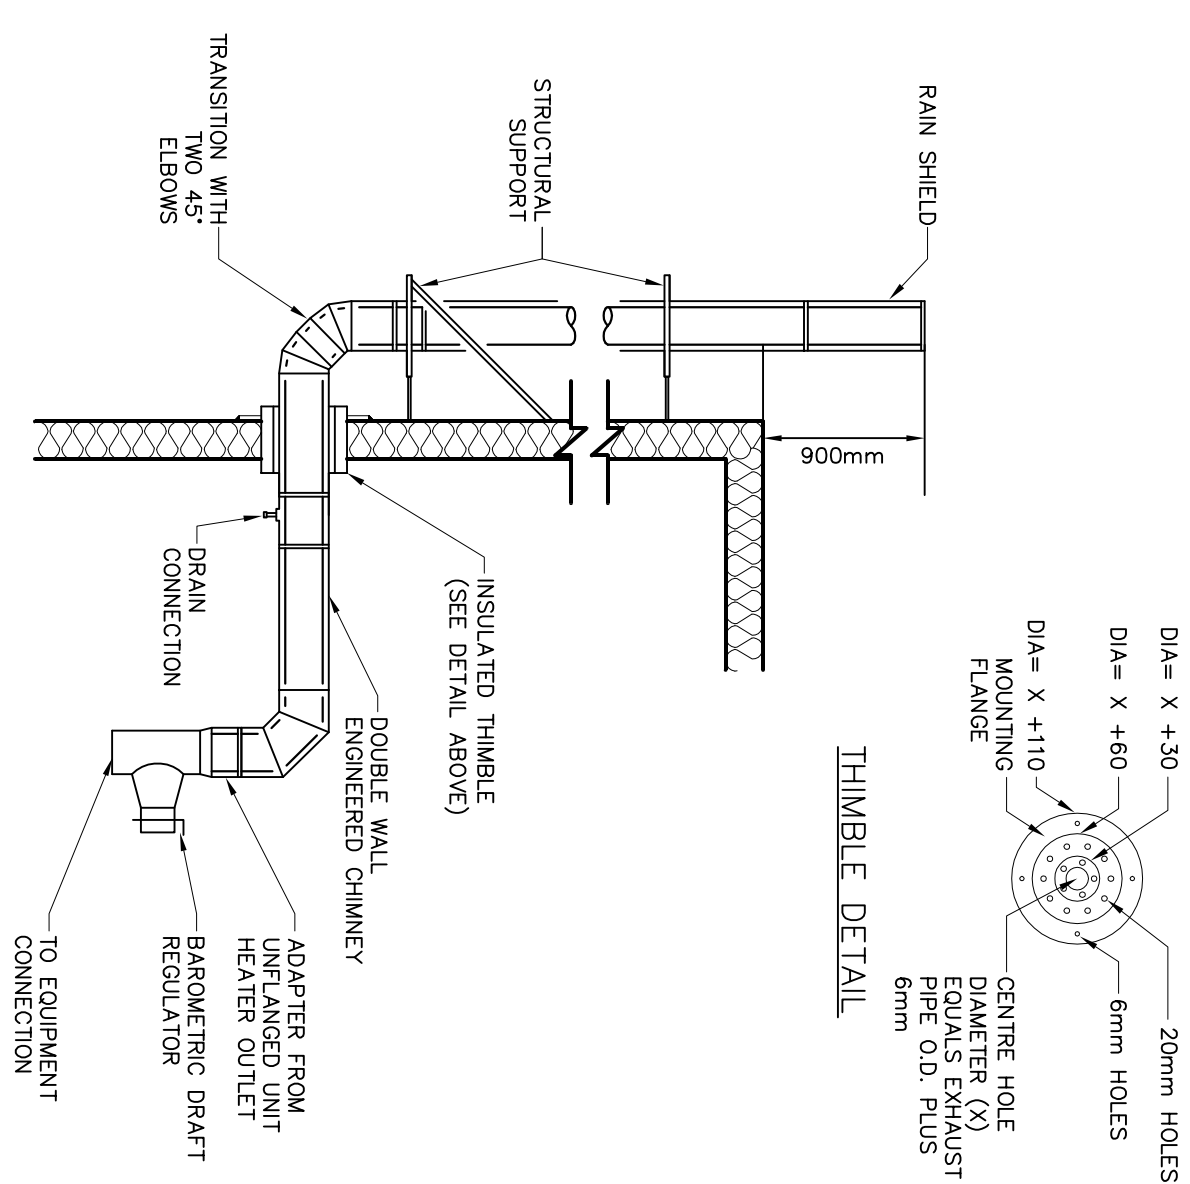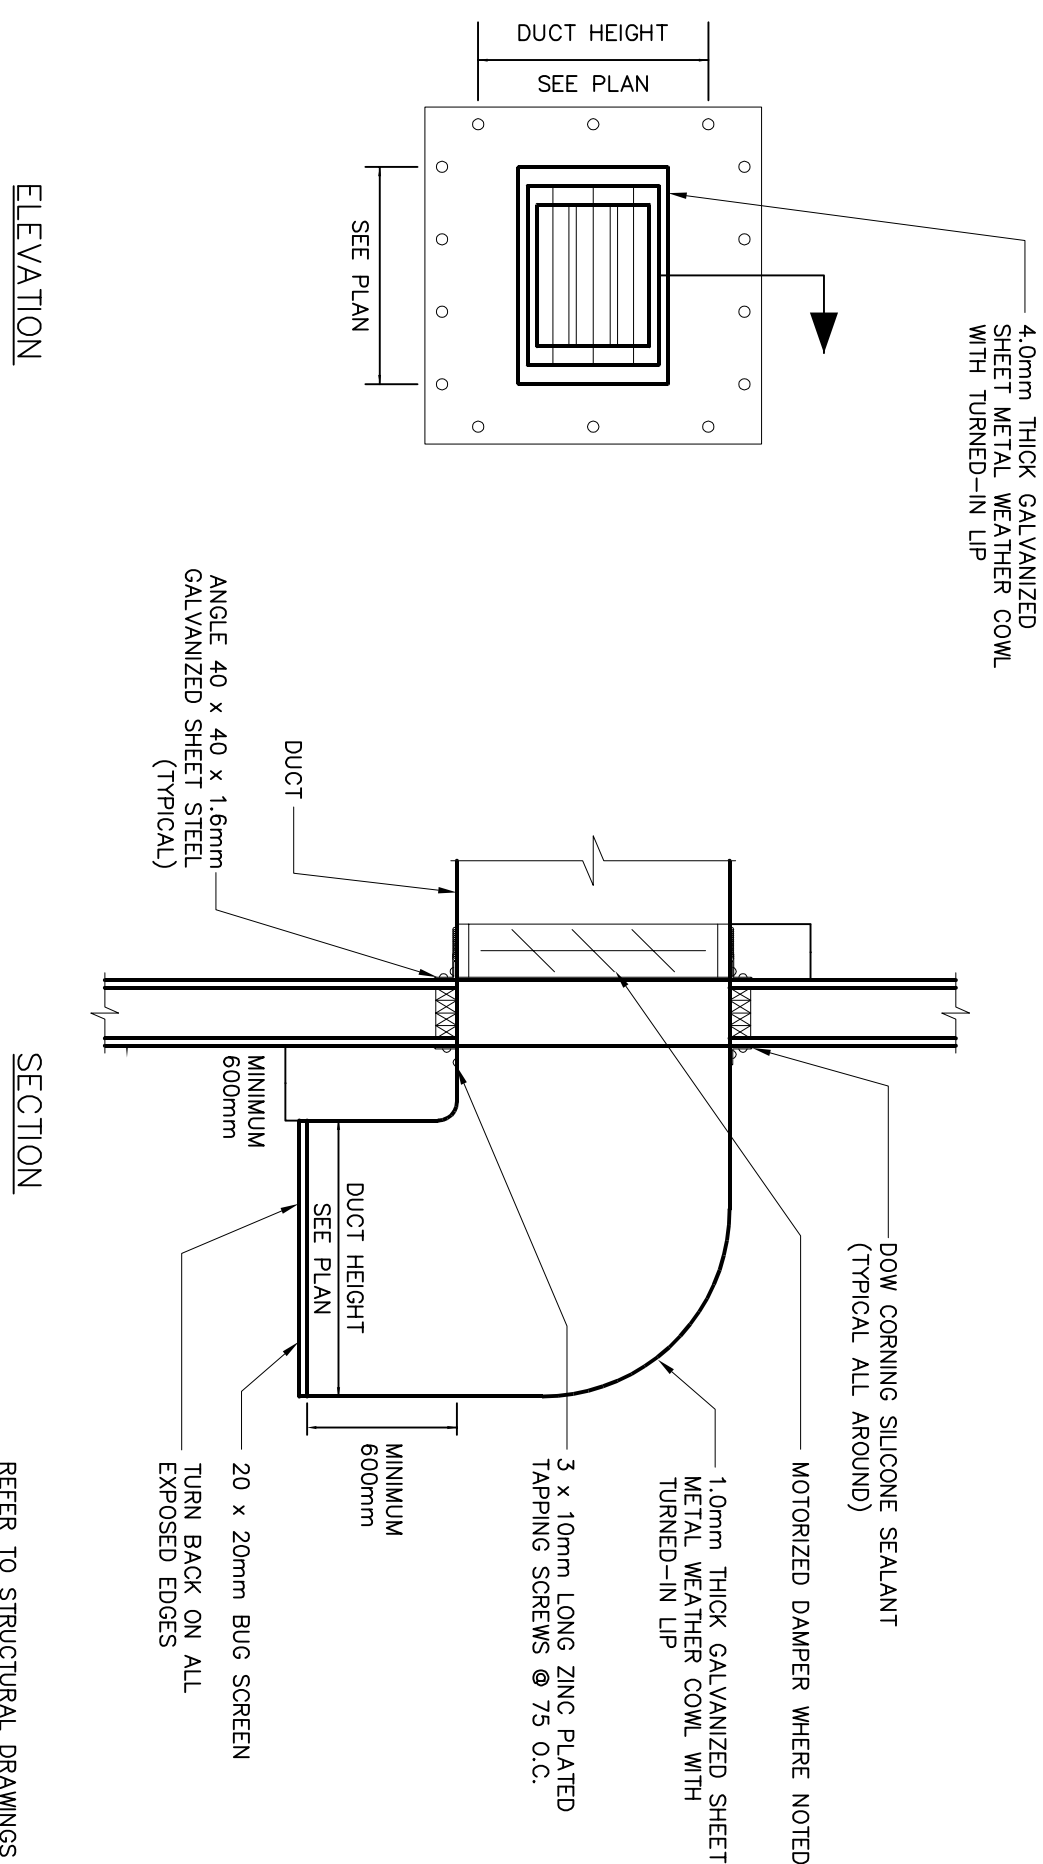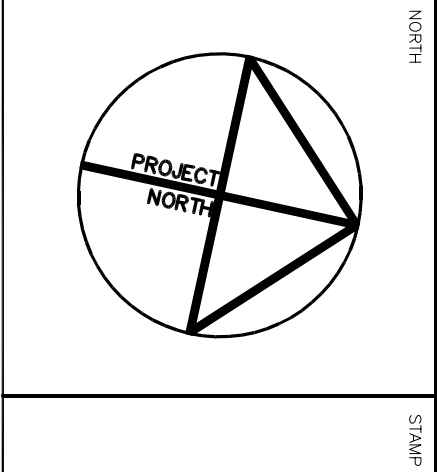UNIT HEATER CHIMNEY DETAIL
(NTS)TYPICAL WEATHER COWL DETAIL
(NTS)

NOTES: GENERAL CONTRACTOR TO VERIFY ALL DIMENSIONS WITH FINAL ARCHITECTURAL AND MECHANICAL DRAWINGS. NOTIFY THE ENGINEERS OF ANY ERRORS AND /OR OMISSIONS PRIOR TO CONSTRUCTION FOR DIRECTION. DO NOT SCALE THIS DRAWING.

R E V I S I O N S				
No.	DESCRIPTION	DATE	BY	APP'D
3	ISSUED FOR 90% REVIEW	06/12/2013		
2	ISSUED FOR 75% REVIEW	22/03/2013		
1	ISSUED FOR REVIEW	03/01/2013		

 **bpa**
Oltawa : 100-1360 Robertson Road, Suite 100, K2H 5B5
T.(613) 596.6454 F.(613) 596.3346
www.bpa.ca
Gatineau :
430 de l'hôpital Bld, suite 210, J8Y 1T7
T.(819) 778.2448 F.(819) 778.5031
Consulting Engineers



CLIENT
GOVERNMENT OF NUNAVUT
DEPARTMENT OF COMMUNITY
AND GOVERNMENT SERVICES

REPULSE BAY, NUNAVUT
NEW PUMPING STATION

TITLE	
MECHANICAL DETAILS	
designed by	J.C.S.
drawn by	J.C.S.
checked by	P.C.
date	DECEMBER 2013
	N.T.S.
project no.	8072-0089
drawing no.	M101