


# GOVERNMENT OF NUNAVUT

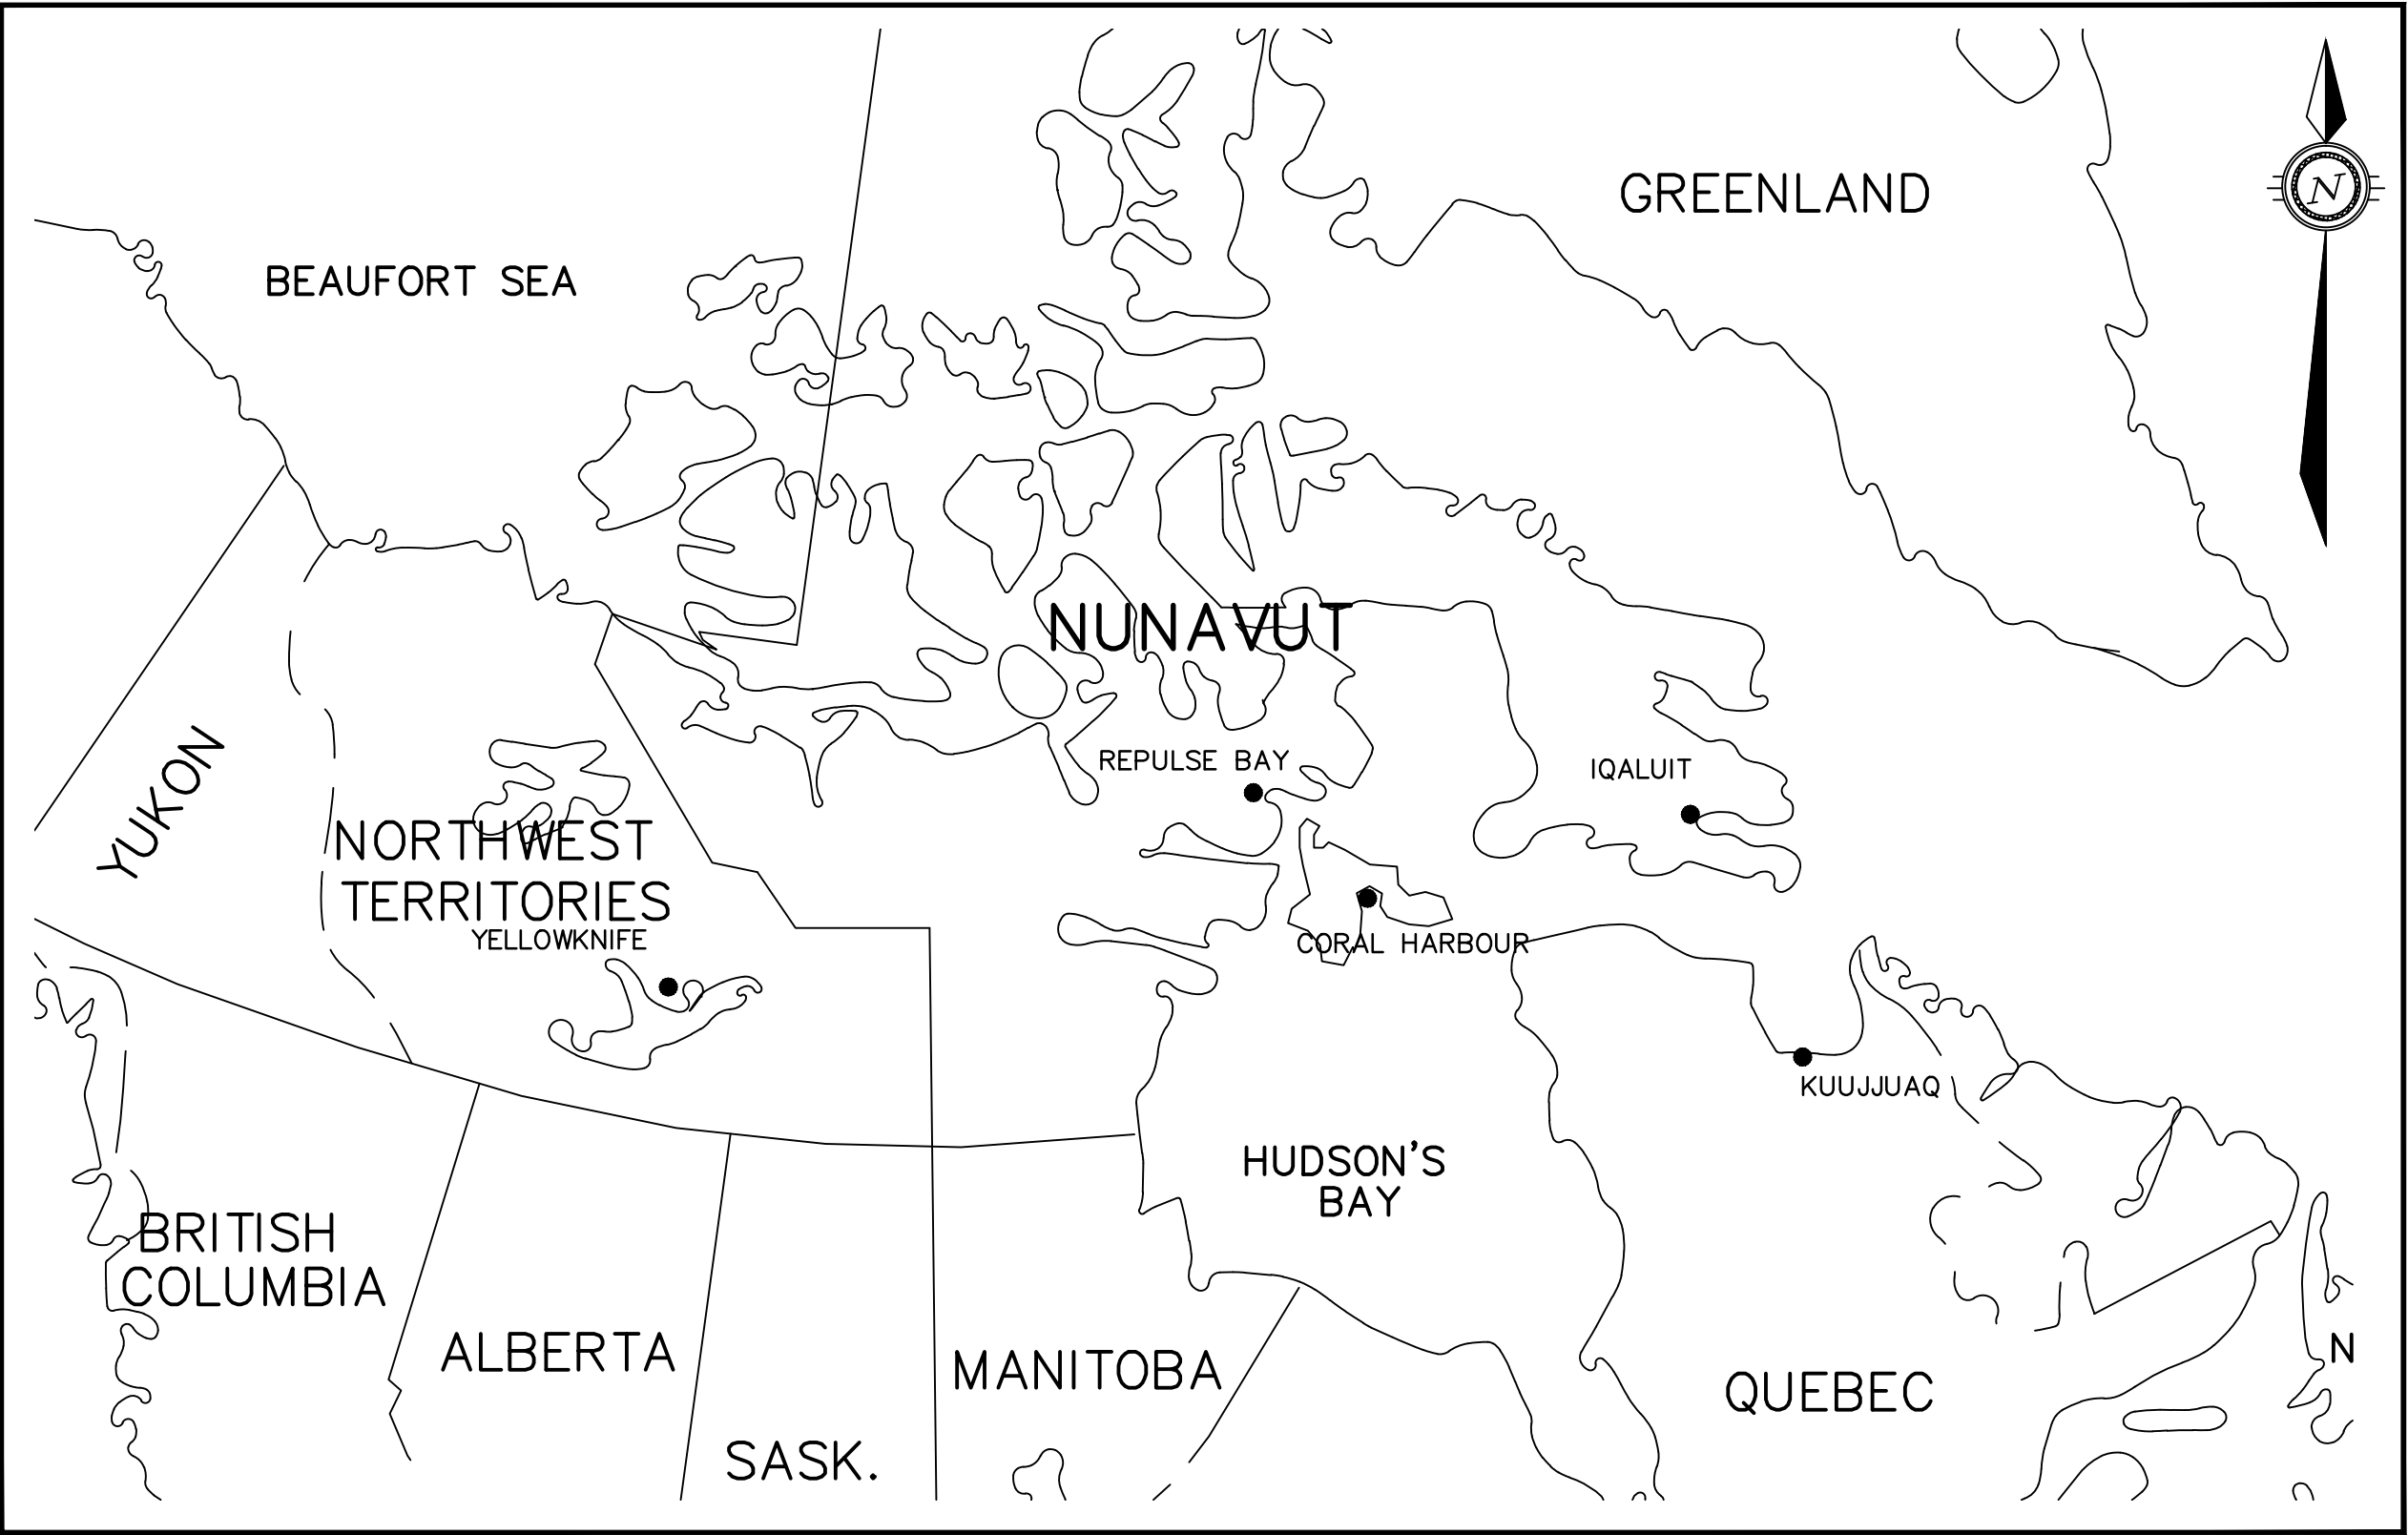

## INDEX OF INCLUDED DRAWINGS

| DRAWING NO.      | REVISION | DESCRIPTION                               |
|------------------|----------|-------------------------------------------|
|                  |          | COVER                                     |
| OTT-00208308A-C1 | REV 3    | SITE LOCATION PLAN                        |
| OTT-00208308A-C2 | REV 3    | PLAN & PROFILE                            |
| OTT-00208308A-C3 | REV 3    | DETAIL SHEET 1                            |
| OTT-00208308A-C4 | REV 3    | DETAIL SHEET 2                            |
| OTT-00208308A-S1 | REV 3    | GROUND FLOOR PLAN AND GENERAL NOTES       |
| OTT-00208308A-S2 | REV 3    | FOUNDATION PLAN ROOF PLAN AND DETAILS     |
| OTT-00208308A-S3 | REV 3    | BUILDING ELEVATIONS AND FILL PIPE DETAILS |
| OTT-00208308A-S4 | REV 3    | SECTIONS                                  |
| OTT-00208308A-S5 | REV 3    | SECTIONS                                  |
| OTT-00208308A-S6 | REV 3    | FUEL STORAGE TANK PLAN AND SECTIONS       |
| 8011-116-M100    | REV 1    | MECHANICAL LEGEND AND DRAWING LIST        |
| 8011-116-M101    | REV 1    | MECHANICAL DETAILS                        |
| 8011-116-M200    | REV 1    | MECHANICAL PLUMBING LAYOUT                |
| 8011-116-M201    | REV 1    | MECHANICAL PLUMBING LAYOUT                |
| 8011-116-M202    | REV 1    | MECHANICAL PLUMBING SCHEMATIC             |
| 8011-116-M300    | REV 1    | MECHANICAL FUEL SYSTEM LAYOUT             |
| 8011-116-M301    | REV 1    | MECHANICAL FUEL SYSTEM SCHEMATIC          |
| 8011-116-M500    | REV 1    | MECHANICAL VENTILATION LAYOUT             |
| 8011-116-M600    | REV 1    | MECHANICAL CONTROLS SCHEMATICS            |
| 8011-116-M601    | REV 1    | MECHANICAL CONTROLS SCHEMATICS            |
| 8011-116-E1      | REV 1    | ELECTRICAL NEW POWER AND LIGHTING LAYOUT  |
| 8011-116-E2      | REV 1    | ELECTRICAL SINGLE LINE DIAGRAM            |
| 8011-116-E3      | REV 1    | ELECTRICAL GROUNDING LAYOUT AND DETAILS   |

## REPULSE BAY NEW WATER PUMP HOUSE PROJECT 12-3002

ISSUED FOR  
CONSTRUCTION

DATE: MAY 16, 2016



exp Services Inc.  
t: +1.613.688.1899 | f: +1.613.225.7337  
2650 Queensview Drive, Suite 100  
Ottawa, ON K2B 8H6  
Canada

[www.exp.com](http://www.exp.com)

• BUILDINGS • EARTH & ENVIRONMENT • ENERGY •  
• INDUSTRIAL • INFRASTRUCTURE • SUSTAINABILITY •