



- WATER SYSTEM - CONTROL SCHEMATICS

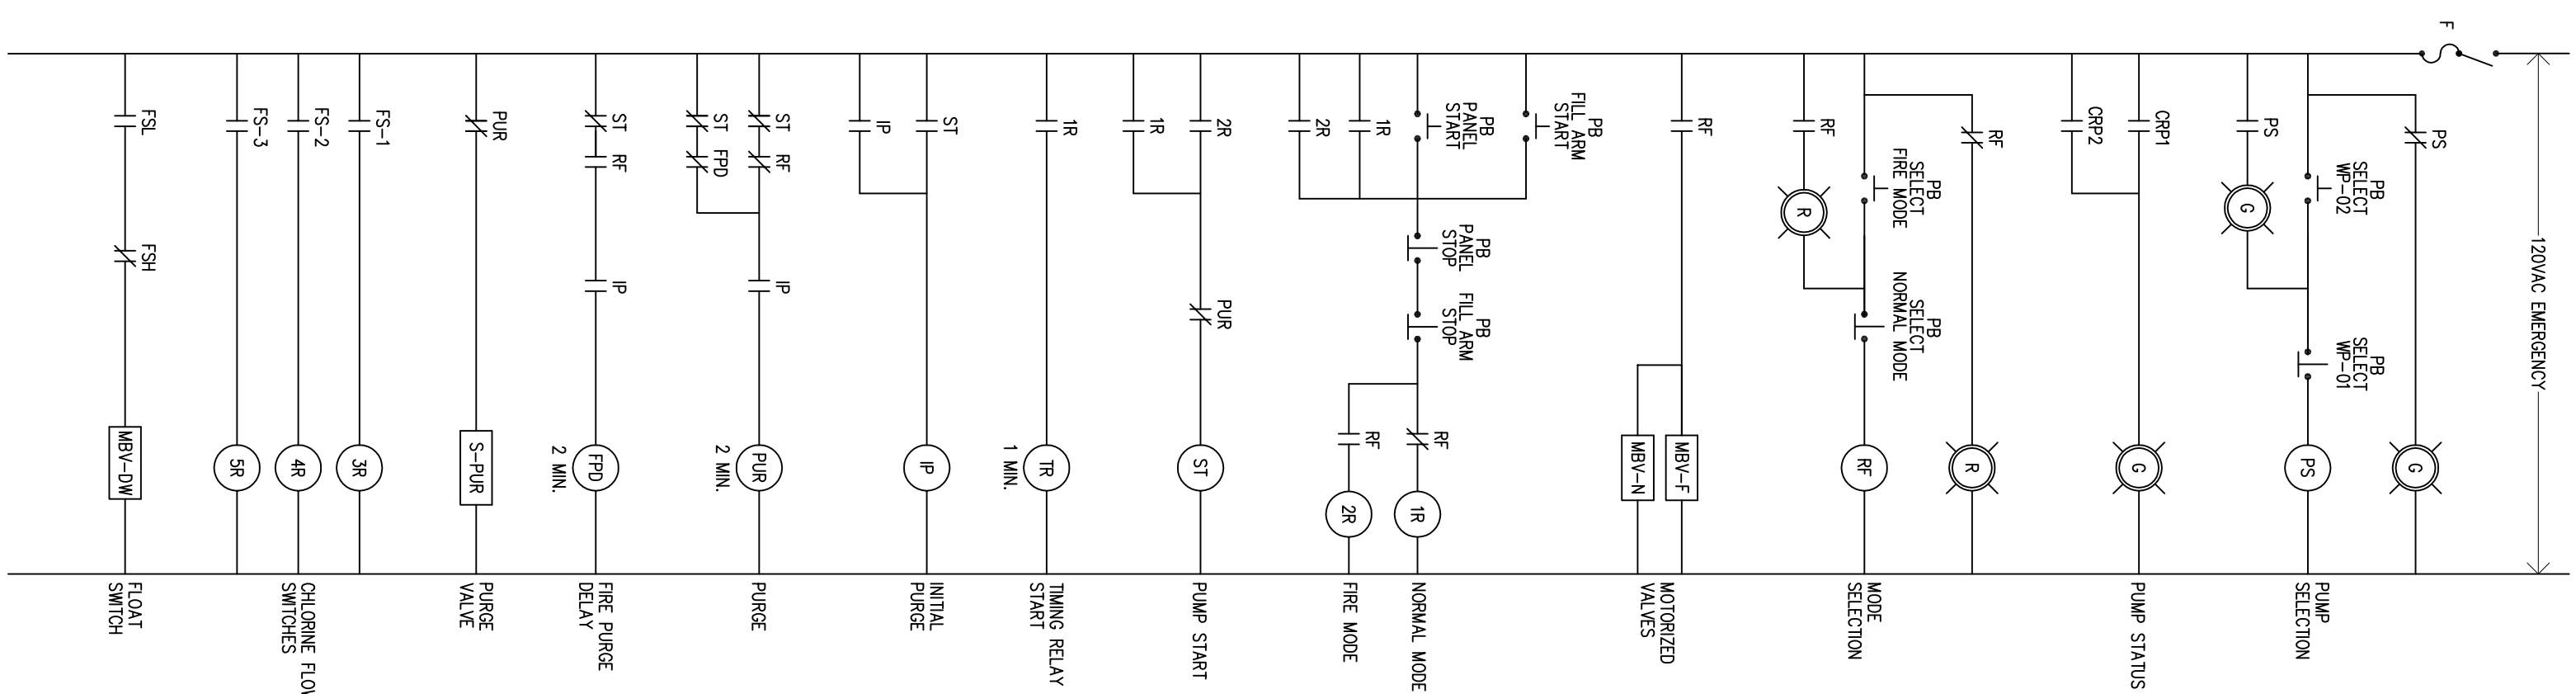


PANEL CP-01


—CONTROLS - WATER PUMPS

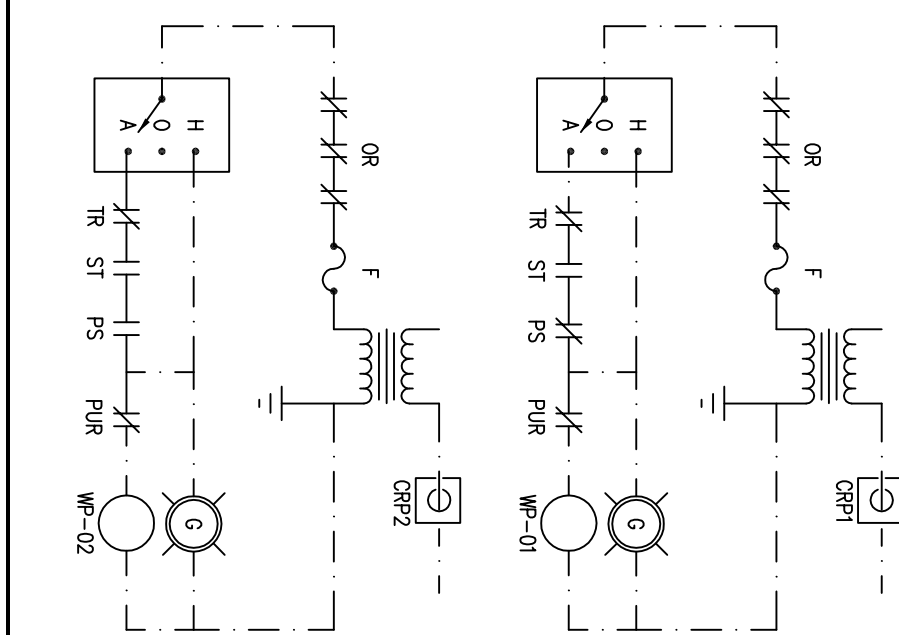

—CHLORINE CONTROLLERS

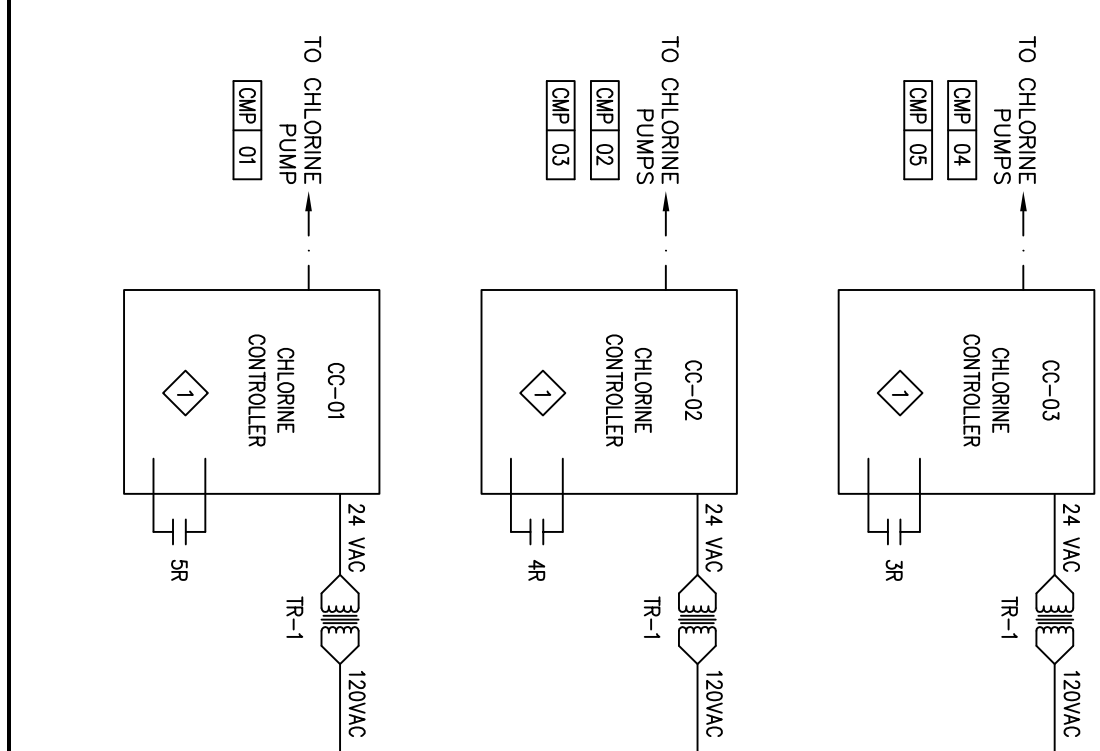


—CONTROLS – DOM. WATER TANK

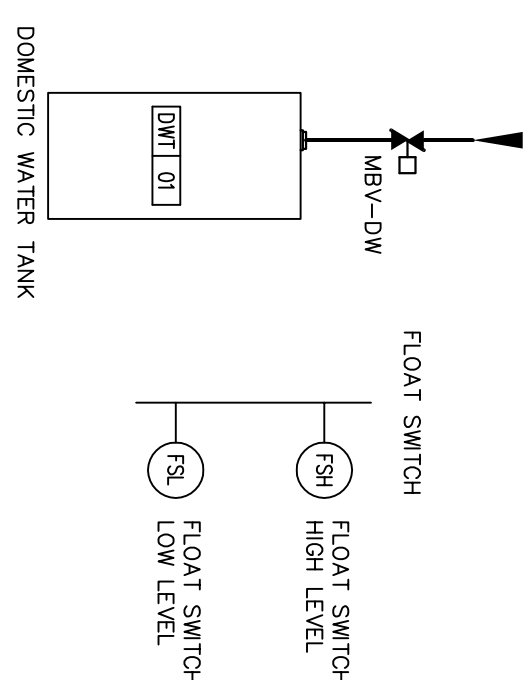

1 CHLORINE CONTROLLER BY DIVISION 23. DIVISION 25 TO PROVIDE 24V POWER SUPPLY AND START/STOP CONTACT TO CONTROLLER.


MECHANICAL & CHLORINE ROOM – VENTILATION

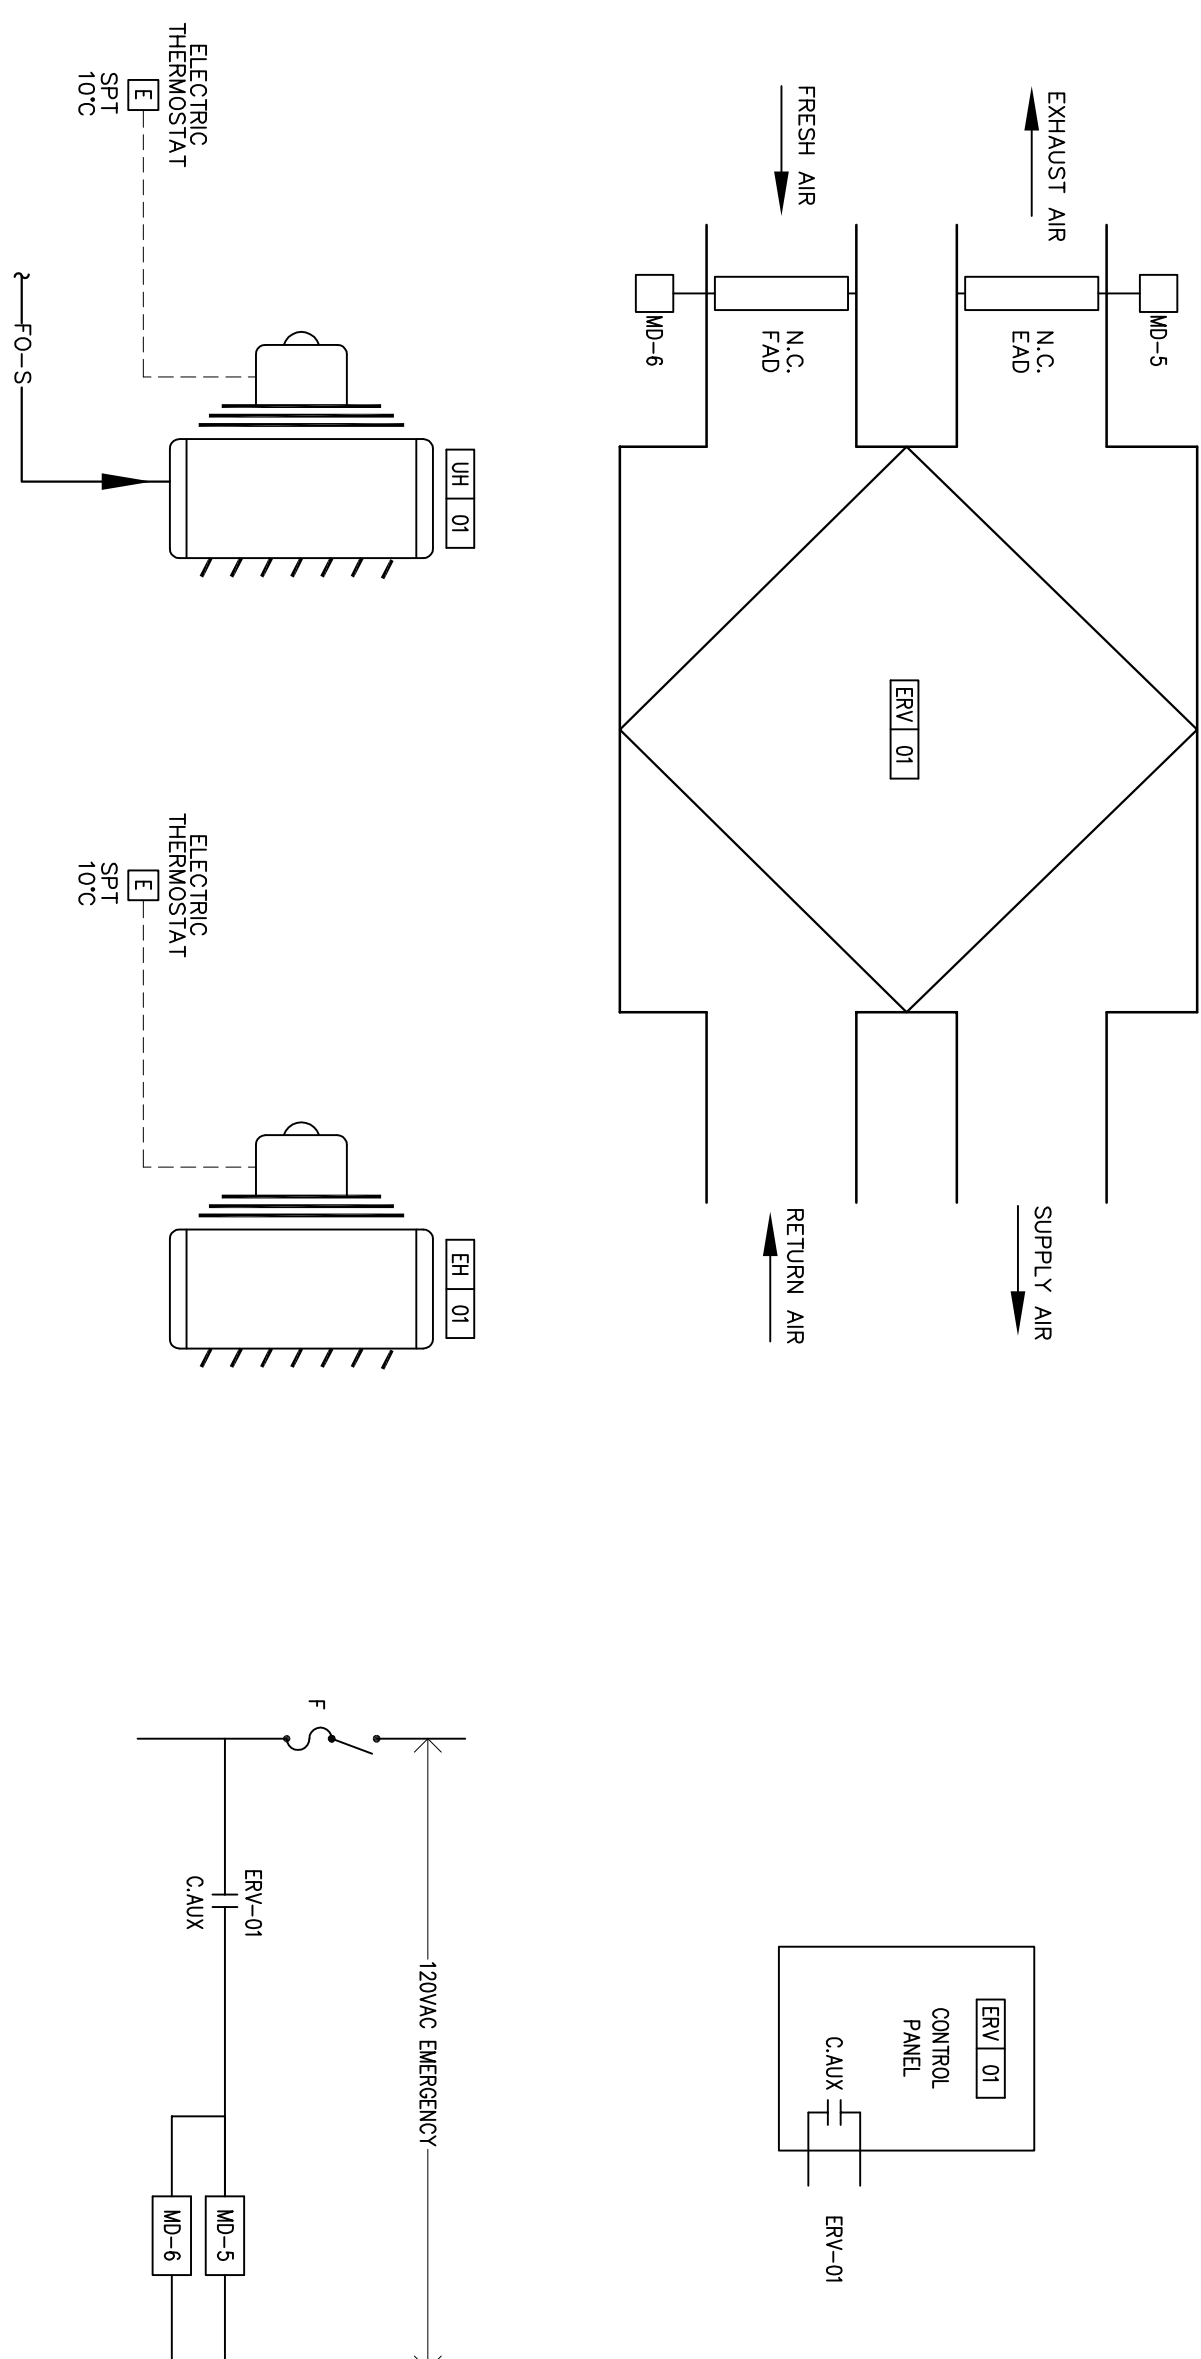

MECHANICAL ROOM – UNIT HEATER
REFER TO MECHANICAL DRAWINGS FOR LOCATION.



CHLORINE ROOM – UNIT HEATER
REFER TO ELECTRICAL DRAWINGS FOR LOCATION

-GENERATOR ROOM - VENTILATION

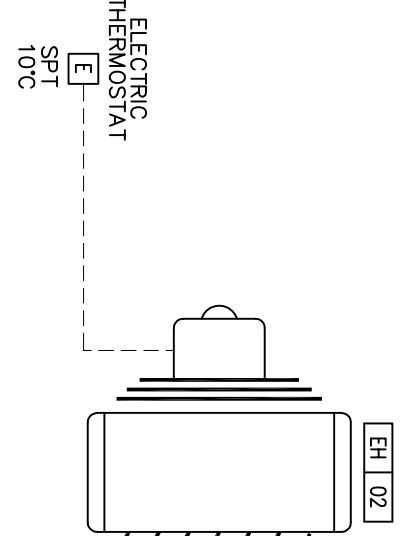


GENERATOR ROOM – UNIT HEATER
REFER TO ELECTRICAL DRAWINGS FOR LOCATION.


NOT

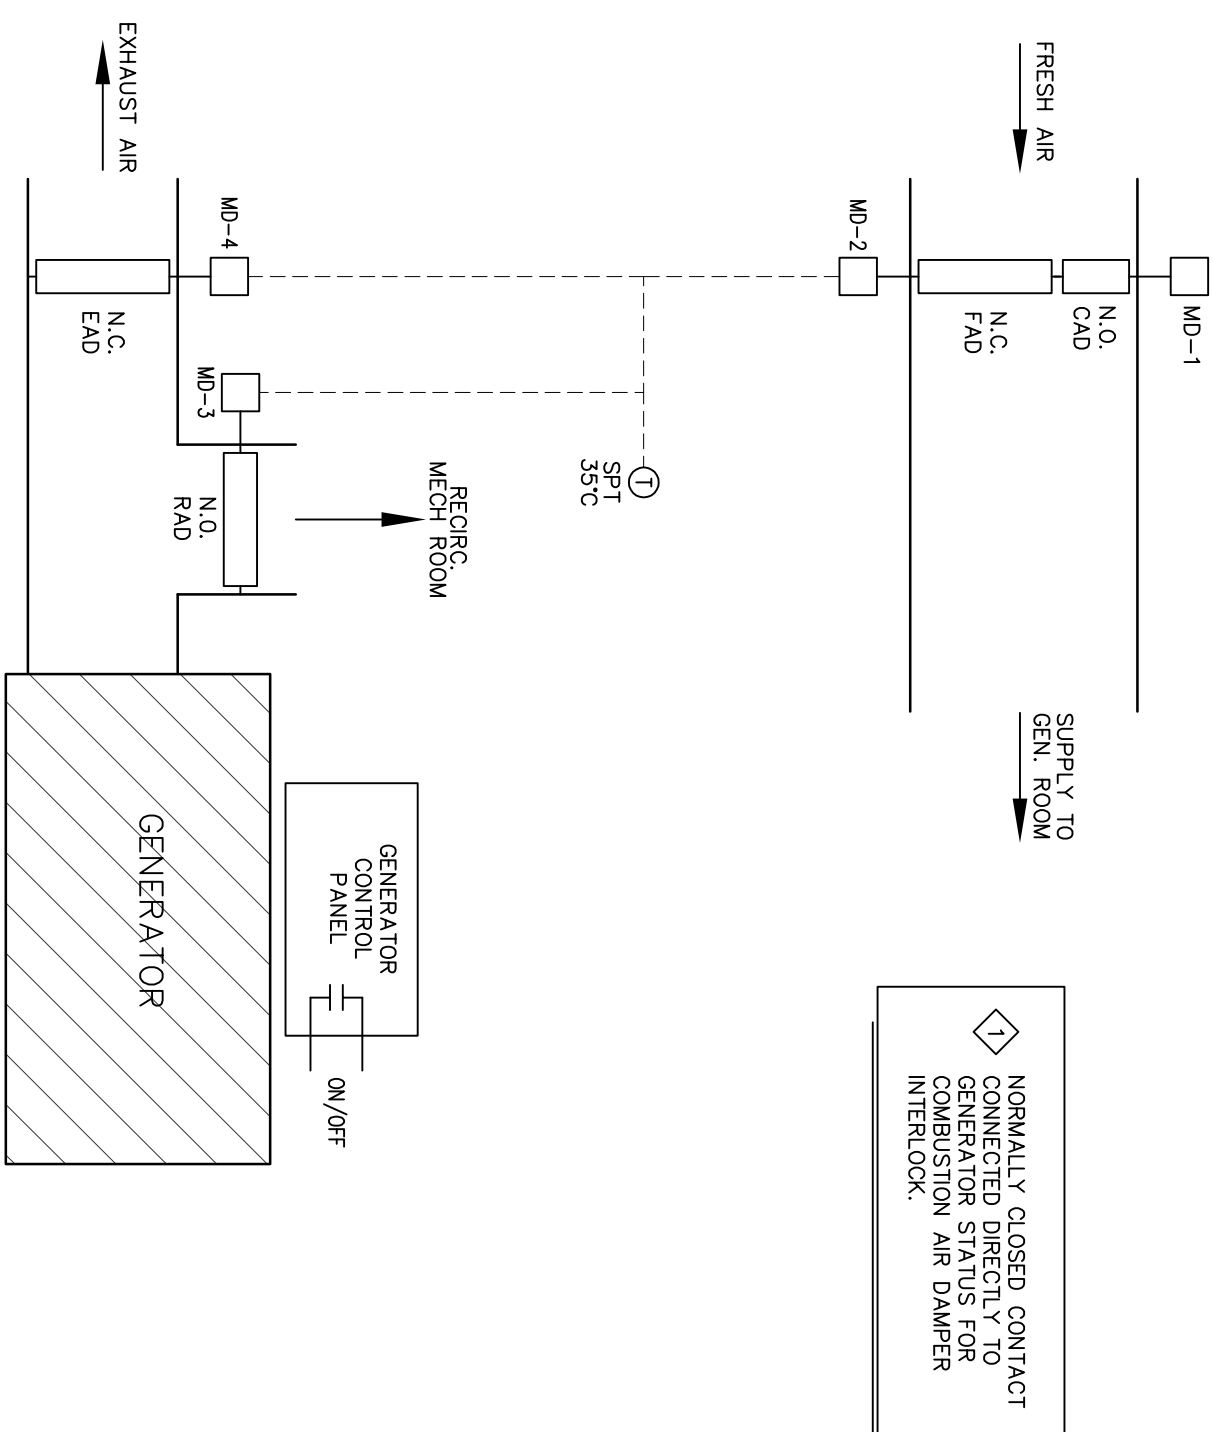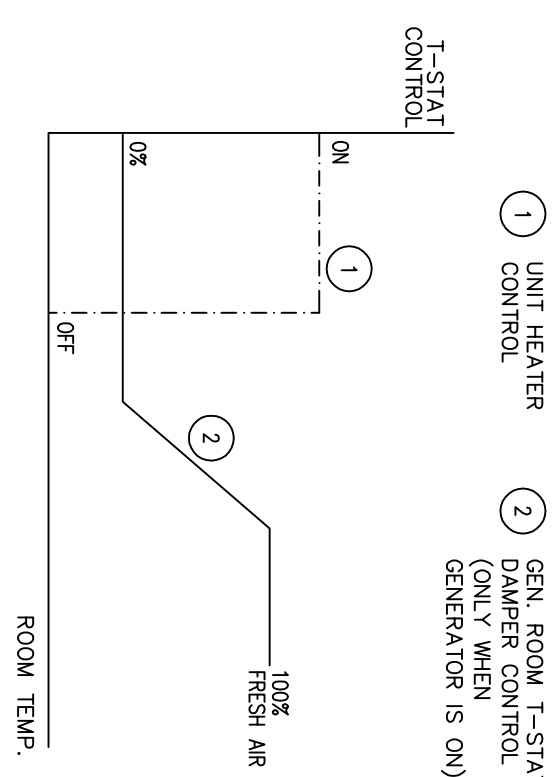

1 NORMALLY CLOSED CONTACT CONNECTED DIRECTLY TO GENERATOR STATUS FOR COMBUSTION AIR DAMPER INTERLOCK

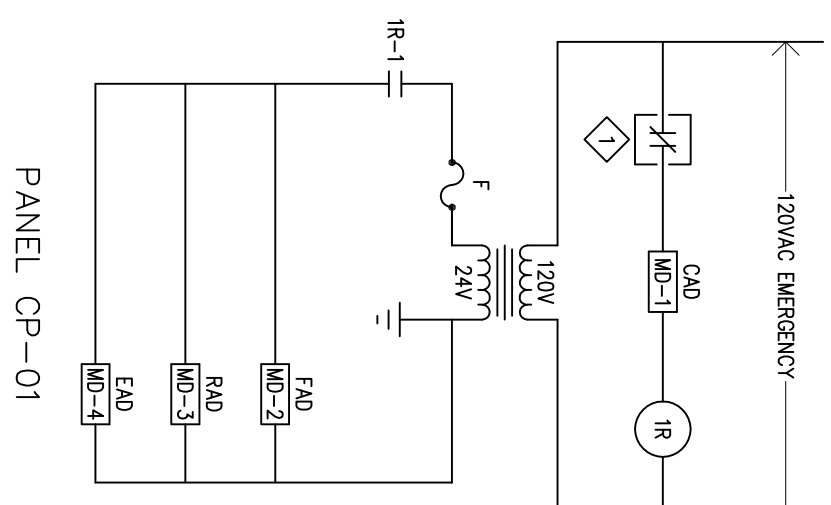

PANEL CP-07

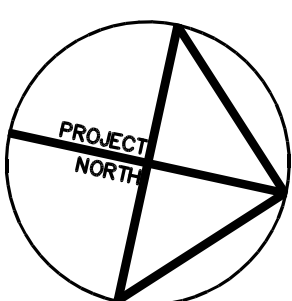

NOTES: GENERAL CONTRACTOR TO VERIFY ALL DIMENSIONS WITH FINAL ARCHITECTURAL AND MECHANICAL DRAWINGS. NOTIFY THE ENGINEERS OF ANY ERRORS AND/OR OMISSIONS PRIOR TO CONSTRUCTION FOR DIRECTION. DO NOT SCALE THIS DRAWING.

3	ISSUED FOR 80% REVIEW	06/12/2013			
2	ISSUED FOR 75% REVIEW	22/03/2013			
1	ISSUED FOR REVIEW	03/01/2013			
No.	DESCRIPTION	DATE	BY	APPROVED	


 Olthwa :
 100-1960 Robertson Road, Suite 100, K2H 5B9
 T: (613) 596.6454 F: (613) 596.3346
 www.bpa.co
 Gathneau :
 430 de l'hôpital bid, suite 210, J8V 1Y7
 T: (819) 778.2448 F: (819) 778.5031
 Consulting Engineers



GOVERNMENT OF NUNAVUT
DEPARTMENT OF COMMUNITY
AND GOVERNMENT SERVICES

PROJECT	TITLE
REPULSE BAY, NUNAVUT NEW PUMPING STATION	MECHANICAL CONTROLS SCHEMATICS

designed by	J.C.S.
drawn by	J.C.S.
checked by	P.C.
date	DECEMBER 2013

DECEMBER 2013