



DATE: 2013-06-20 10:00 AM (GMT-04:00) PROJECT: WASTE WATER TREATMENT PLANT UPGRADE PANGNIRTUNG, NU

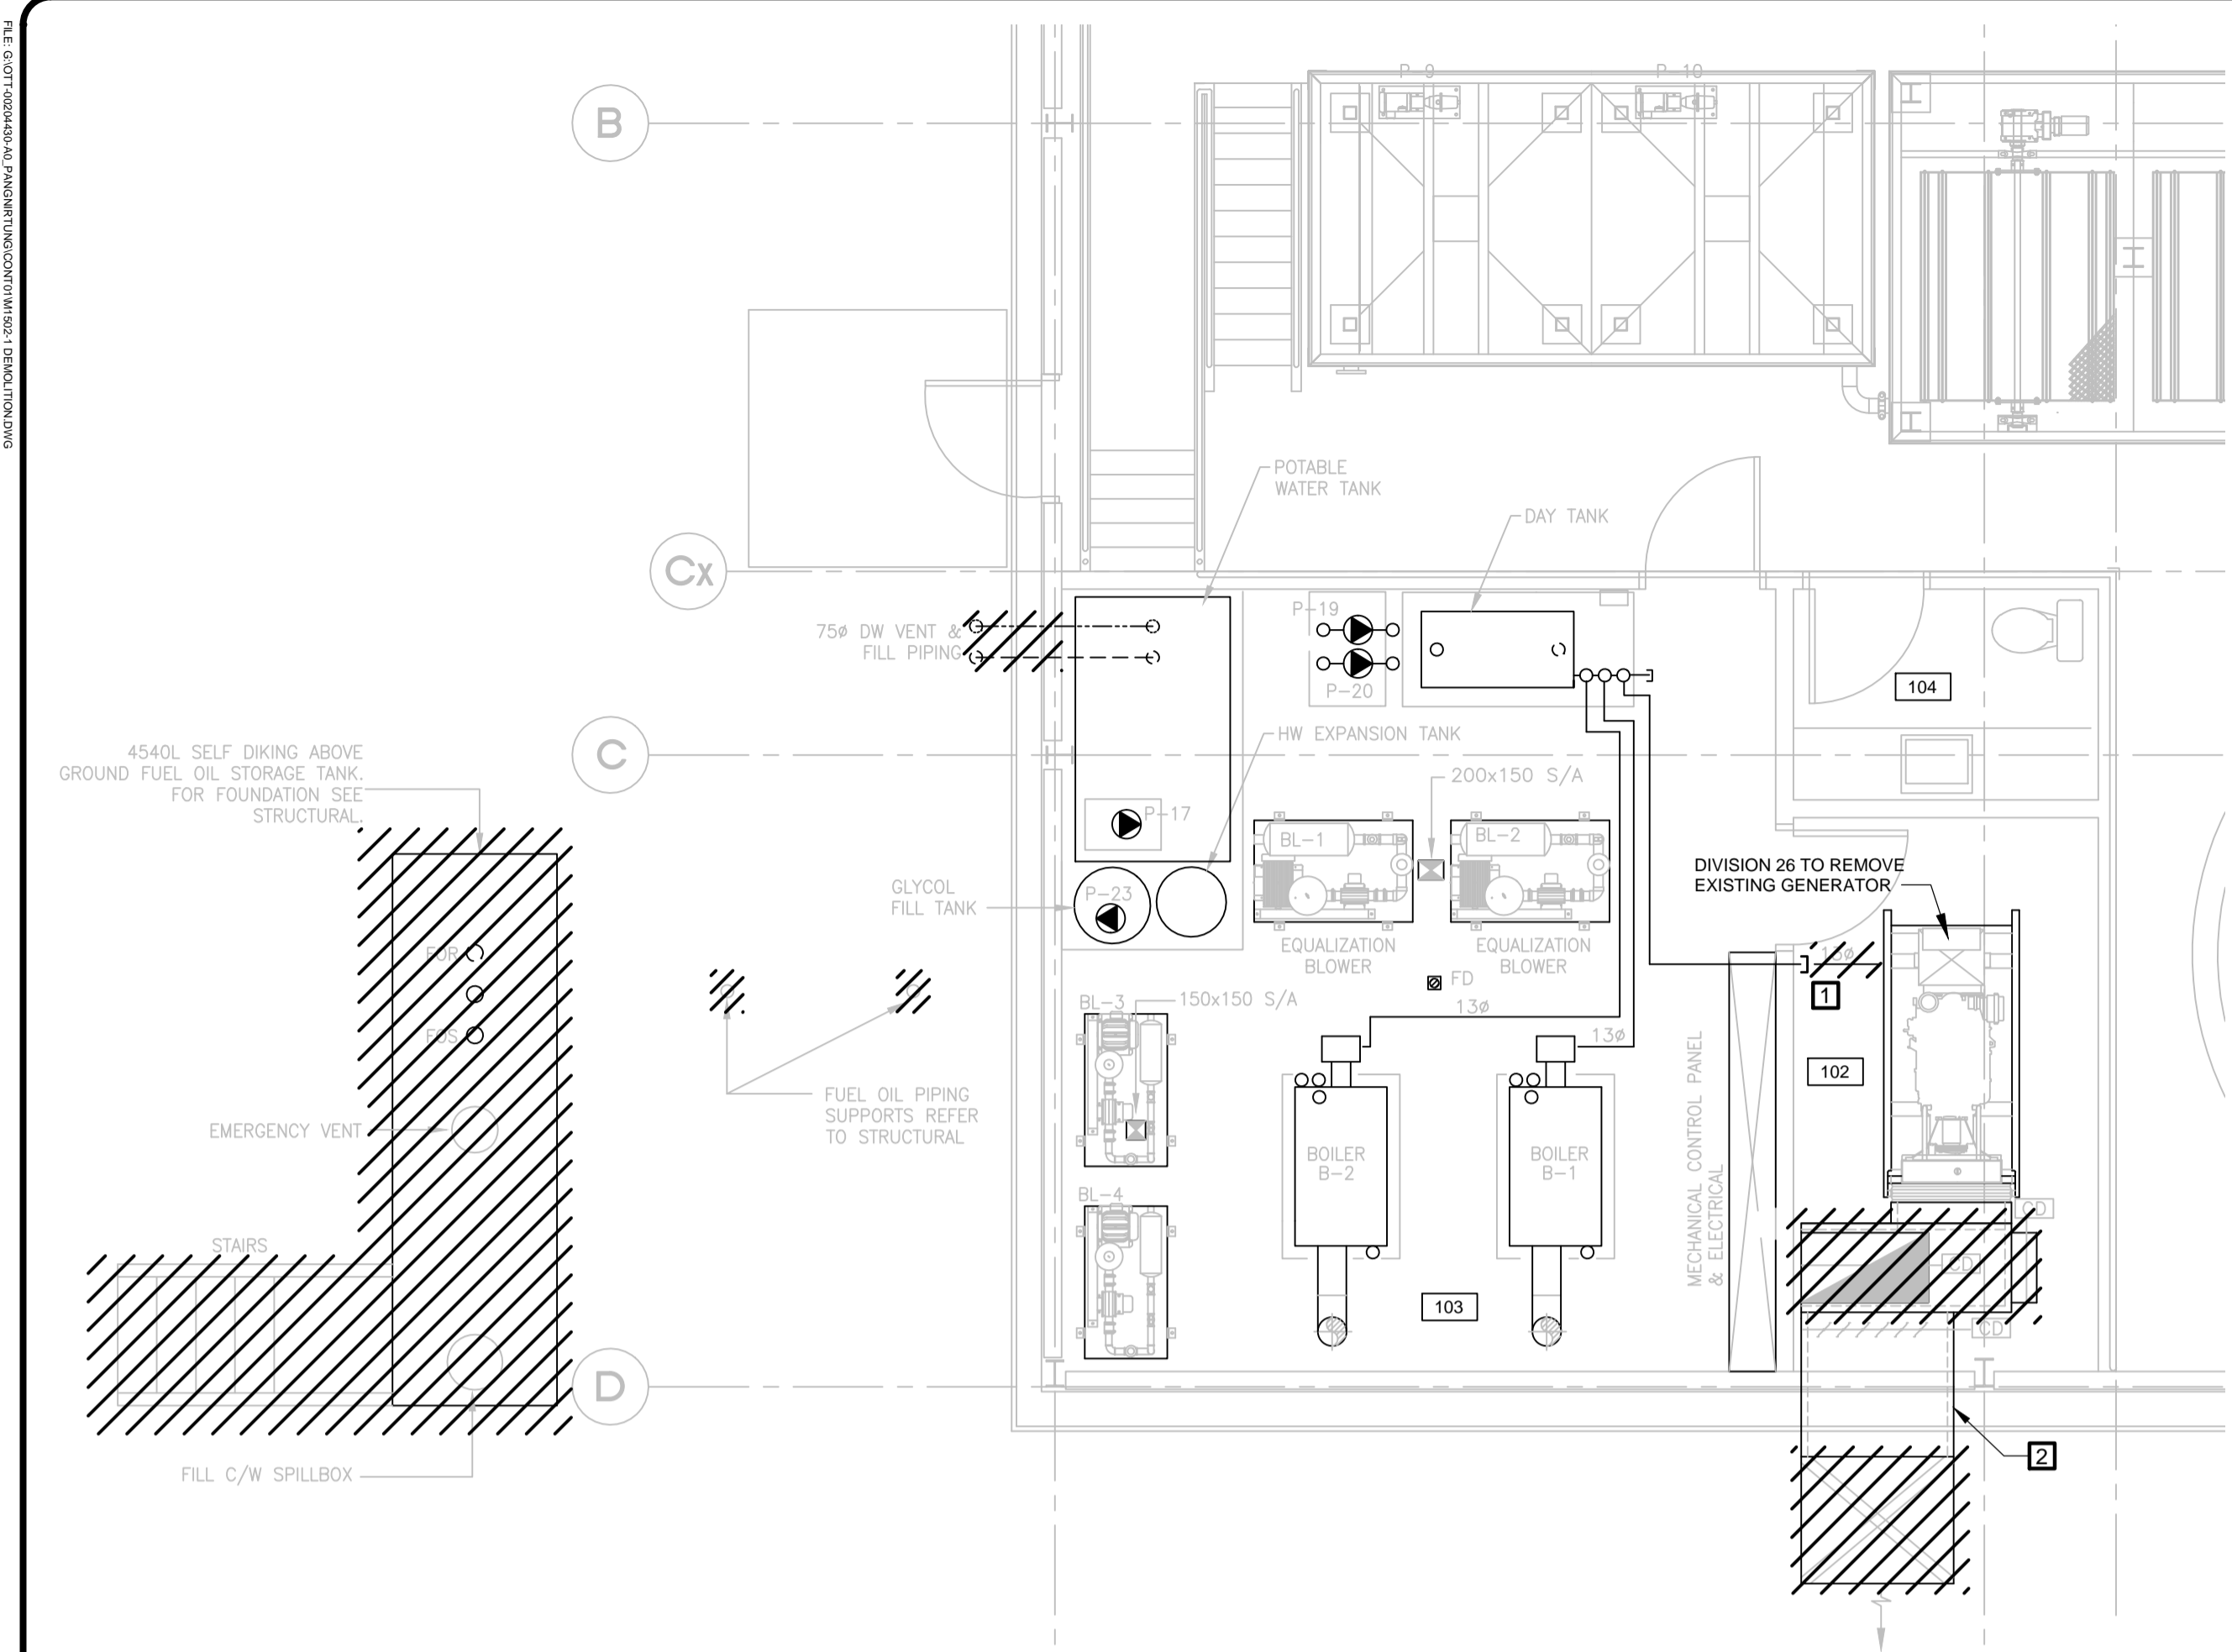

PARTIAL FLOOR PLAN - MECHANICAL ROOM - LOW LEVEL

PIPING AND VENTILATION DEMOLITION


1:50

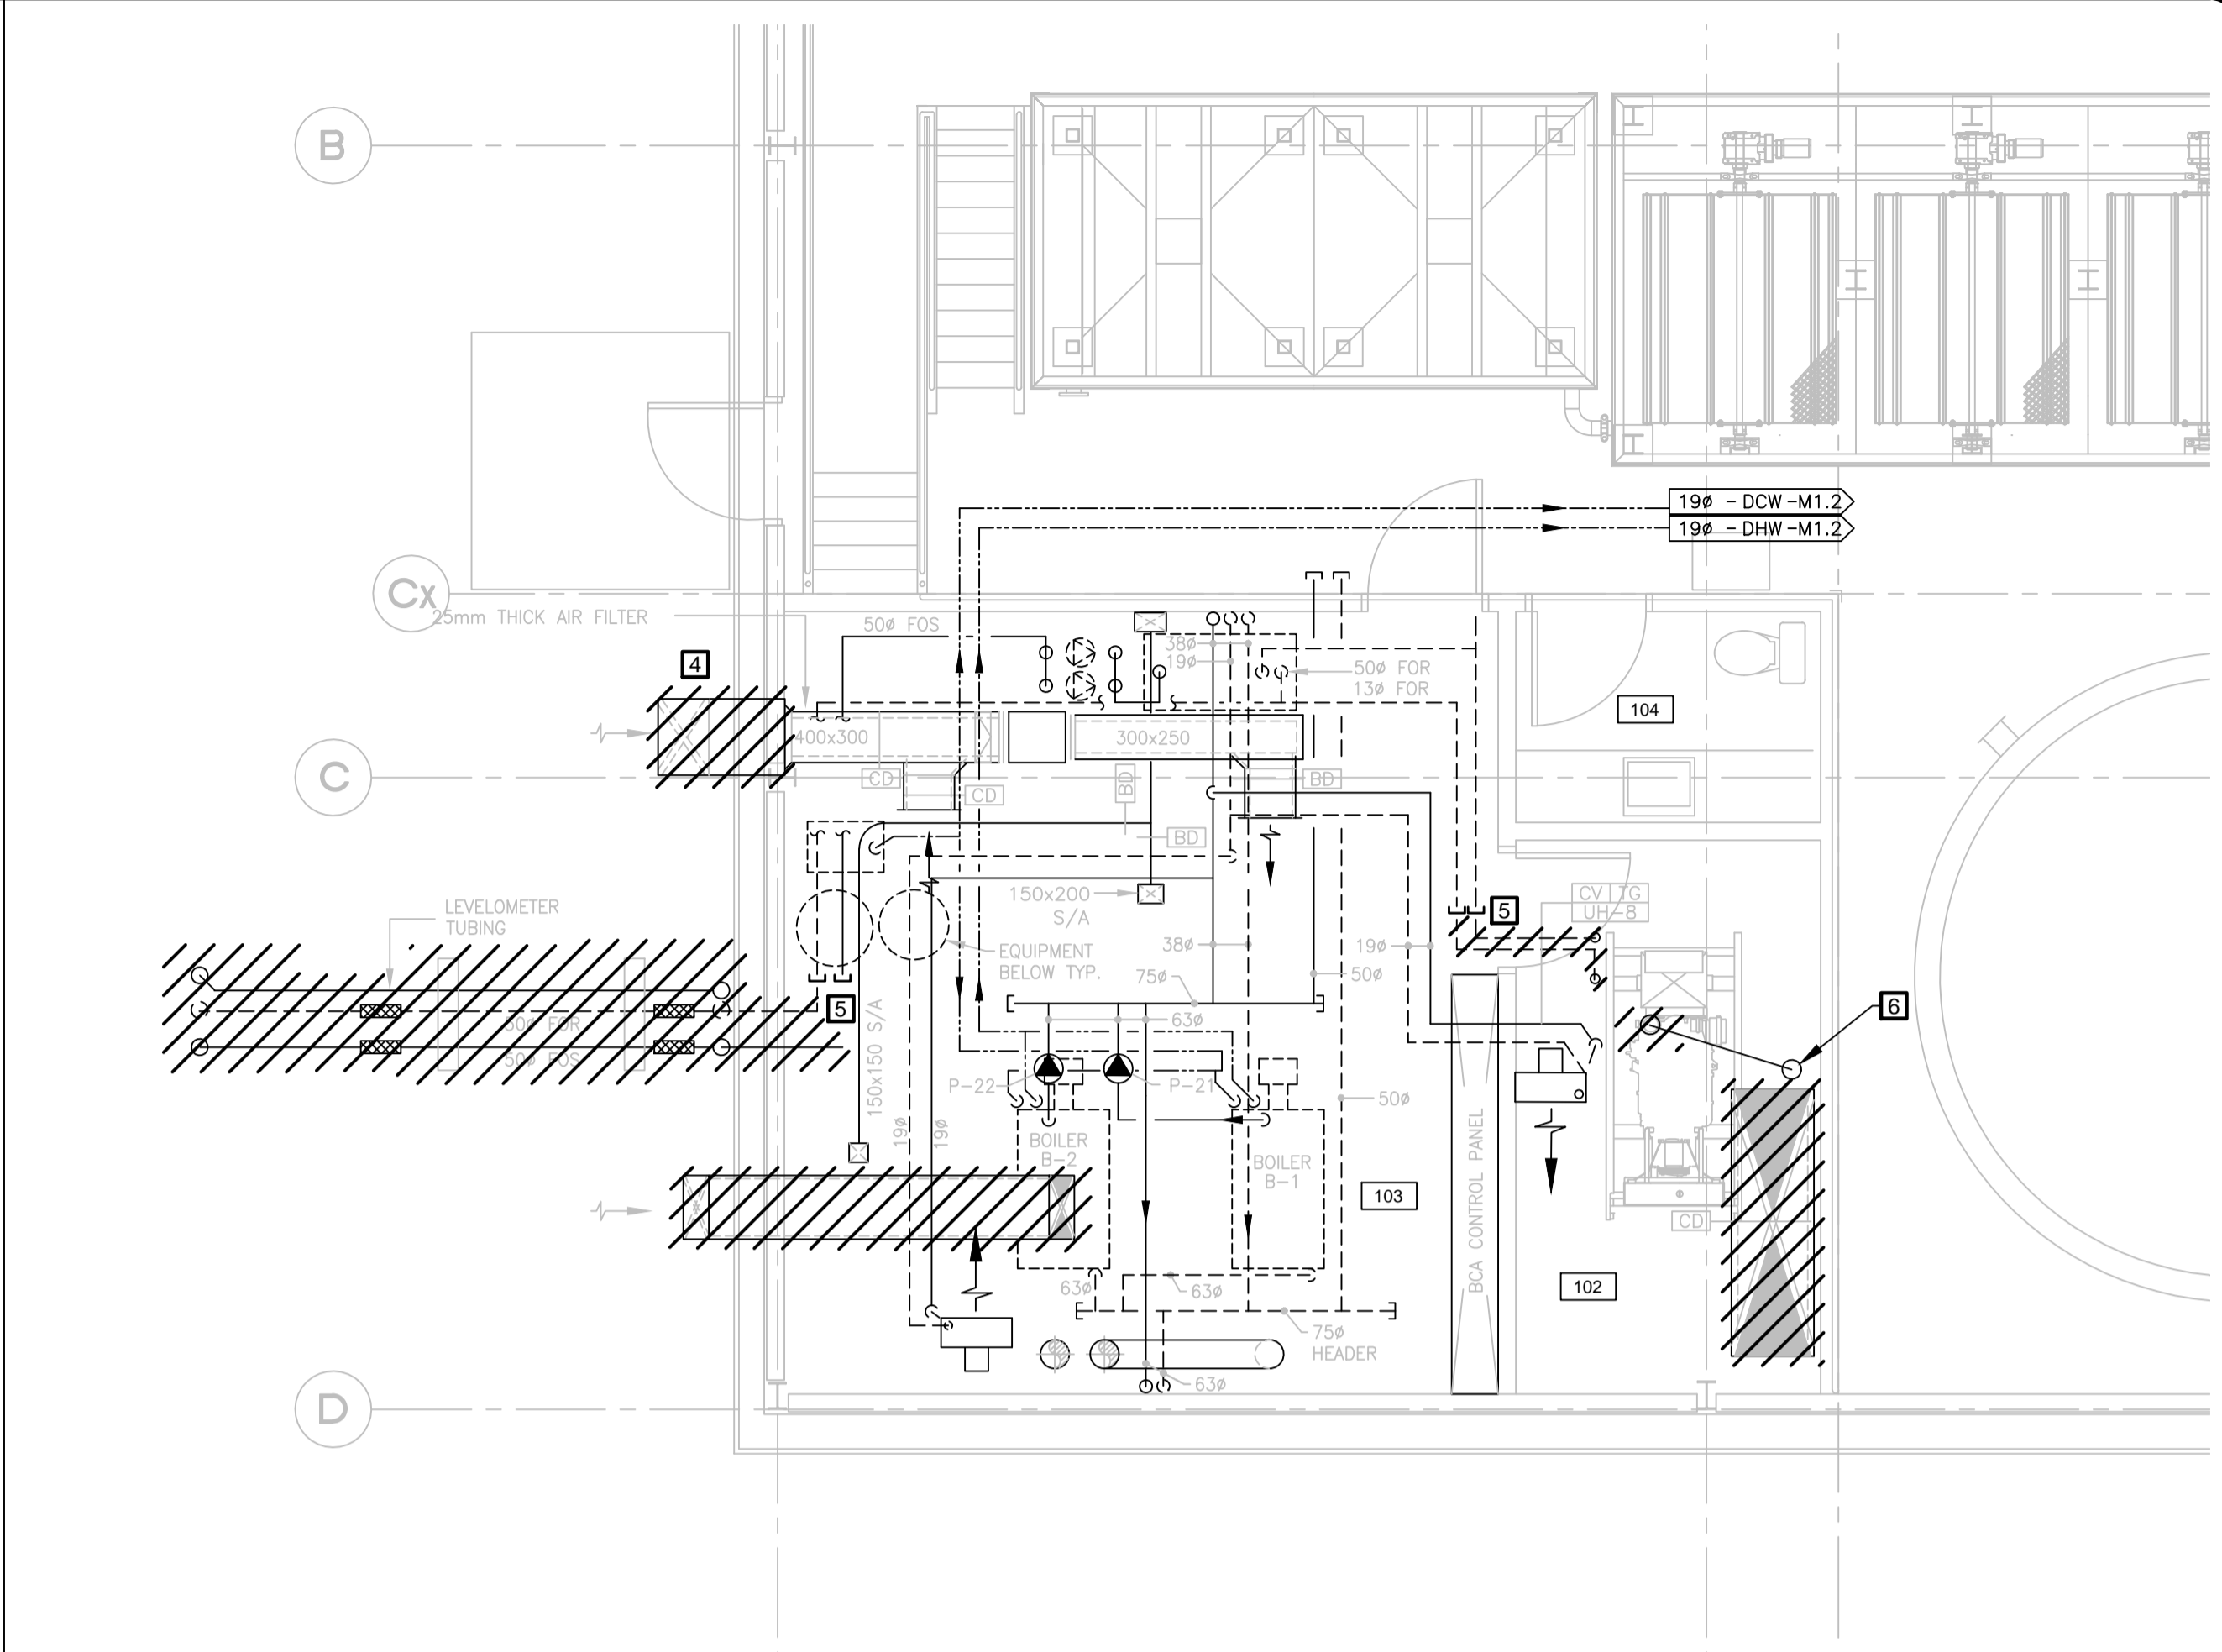

PARTIAL FLOOR PLAN - MECHANICAL ROOM - HIGH LEVEL

FUEL OIL PIPING AND VENTILATION DEMOLITION


1:50

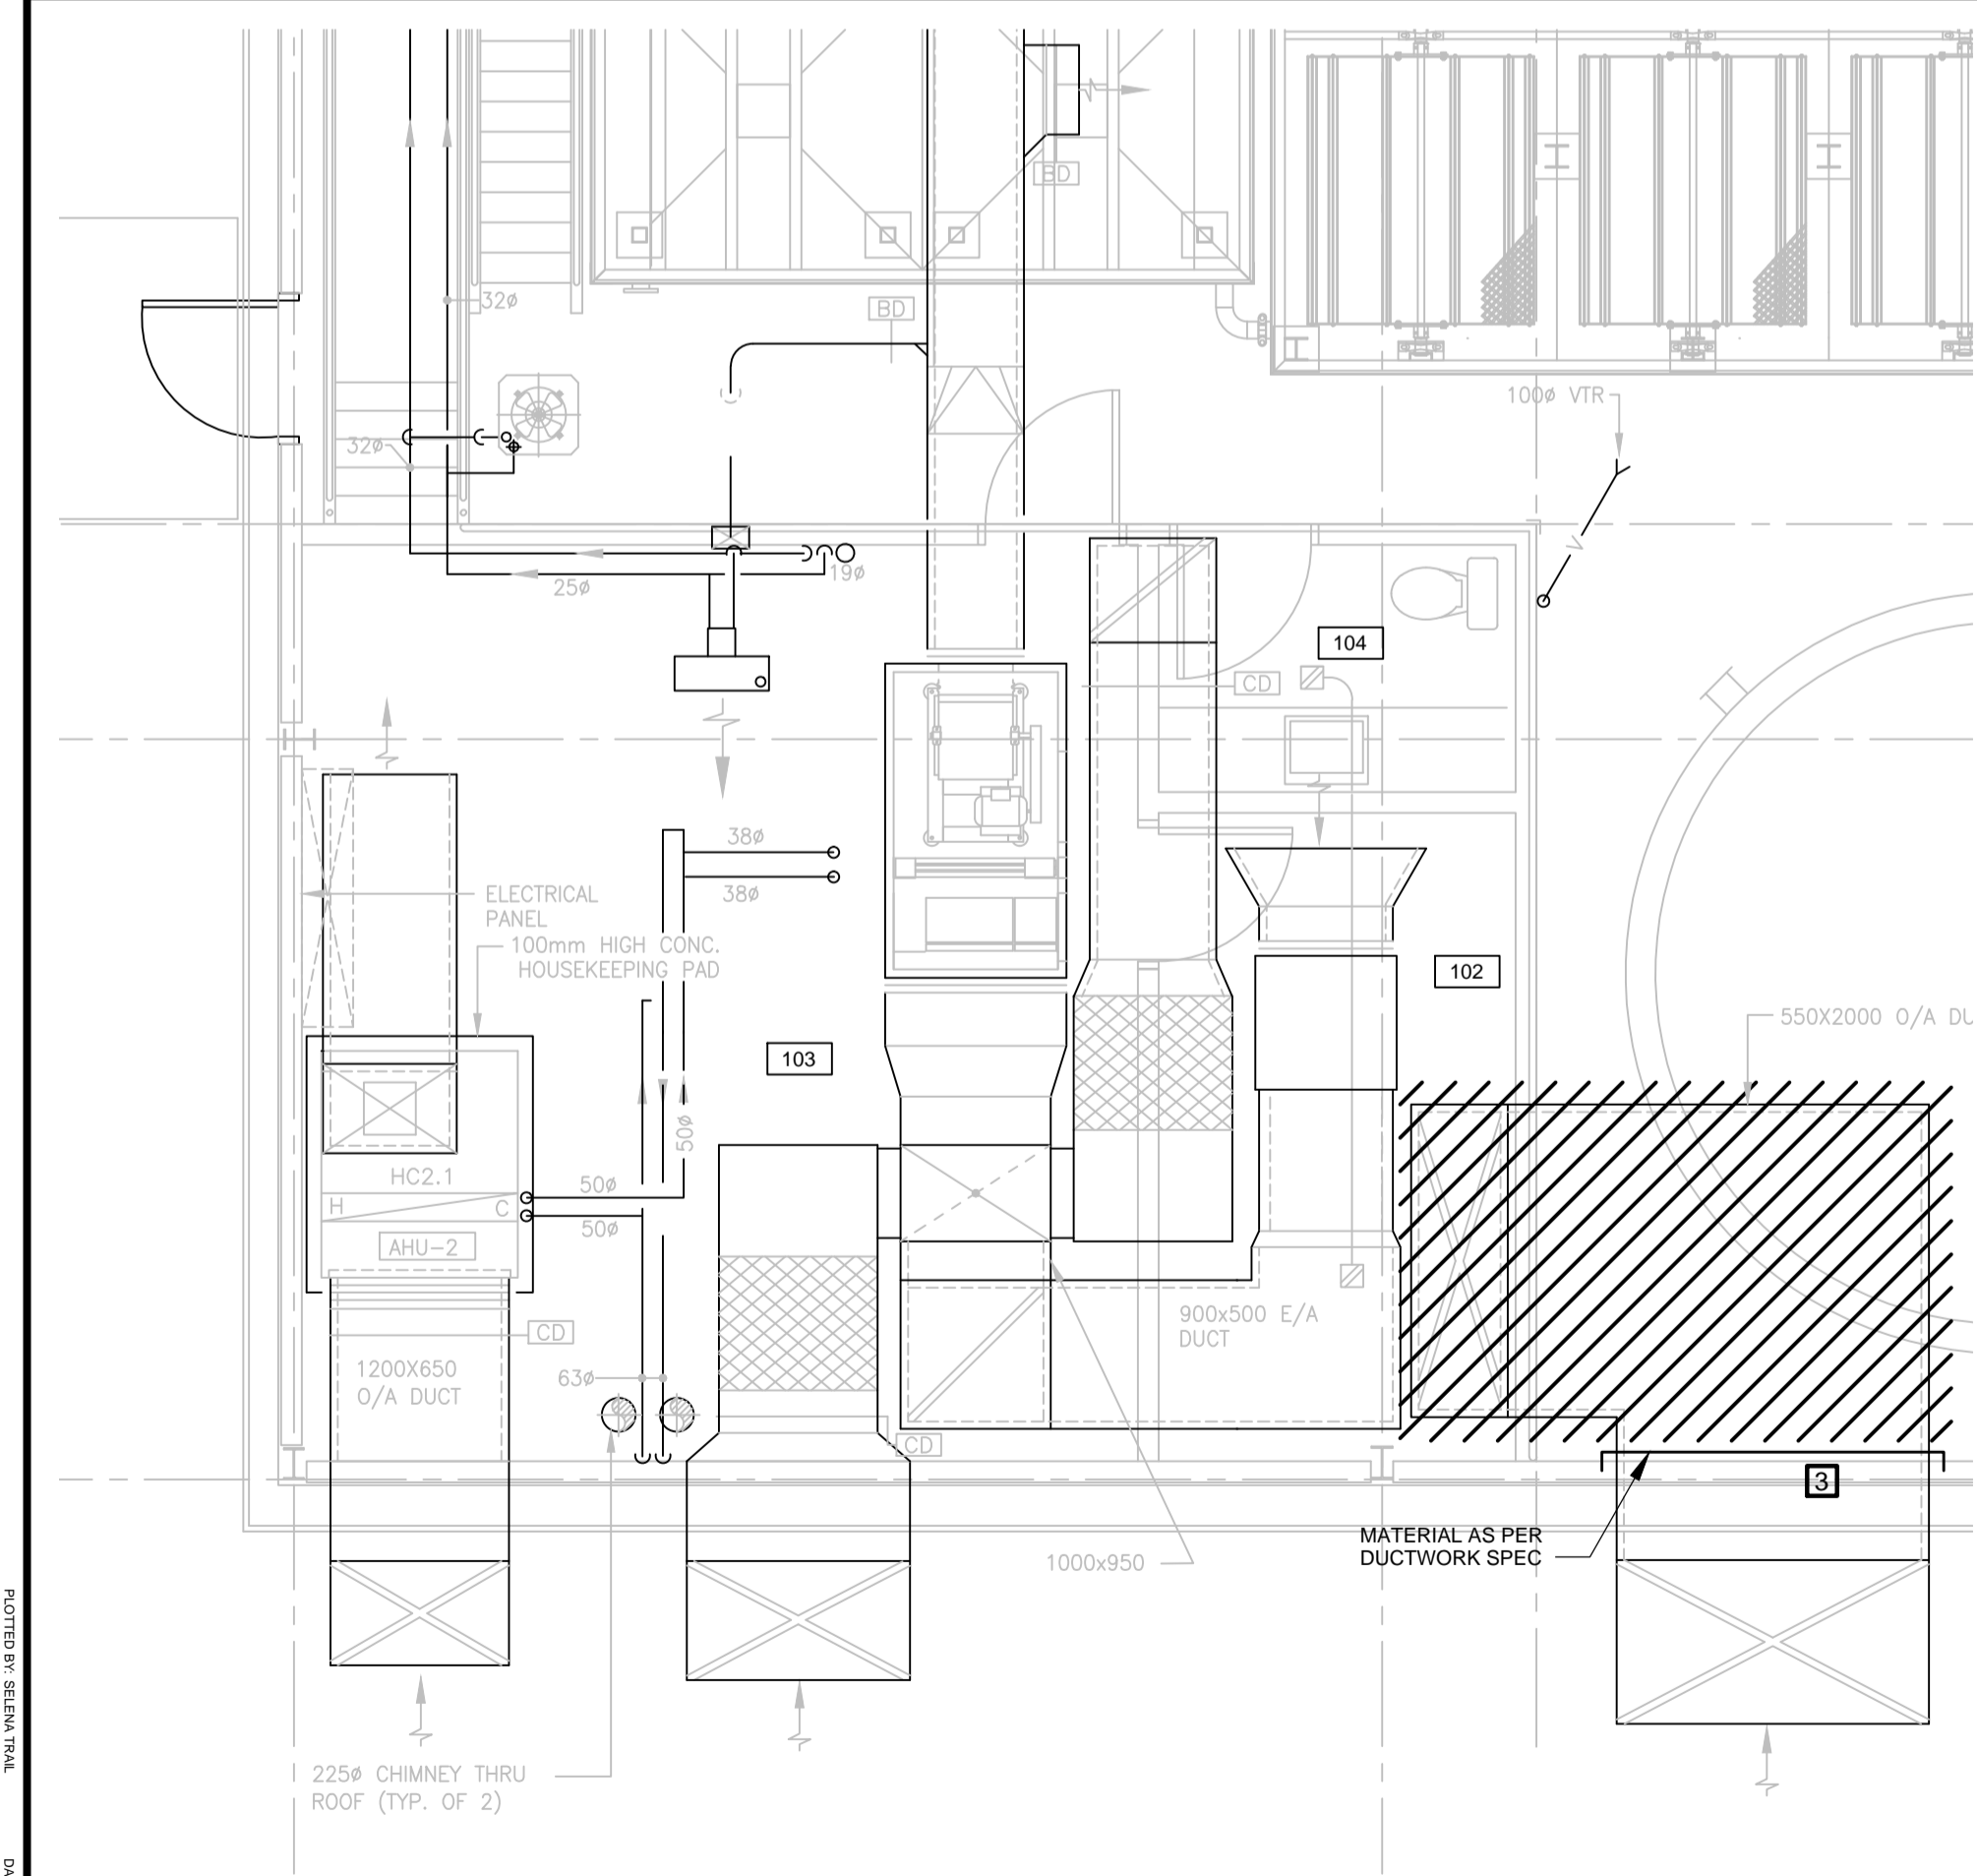

PARTIAL FLOOR PLAN - UPPER LEVEL

VENTILATION DEMOLITION

1:50

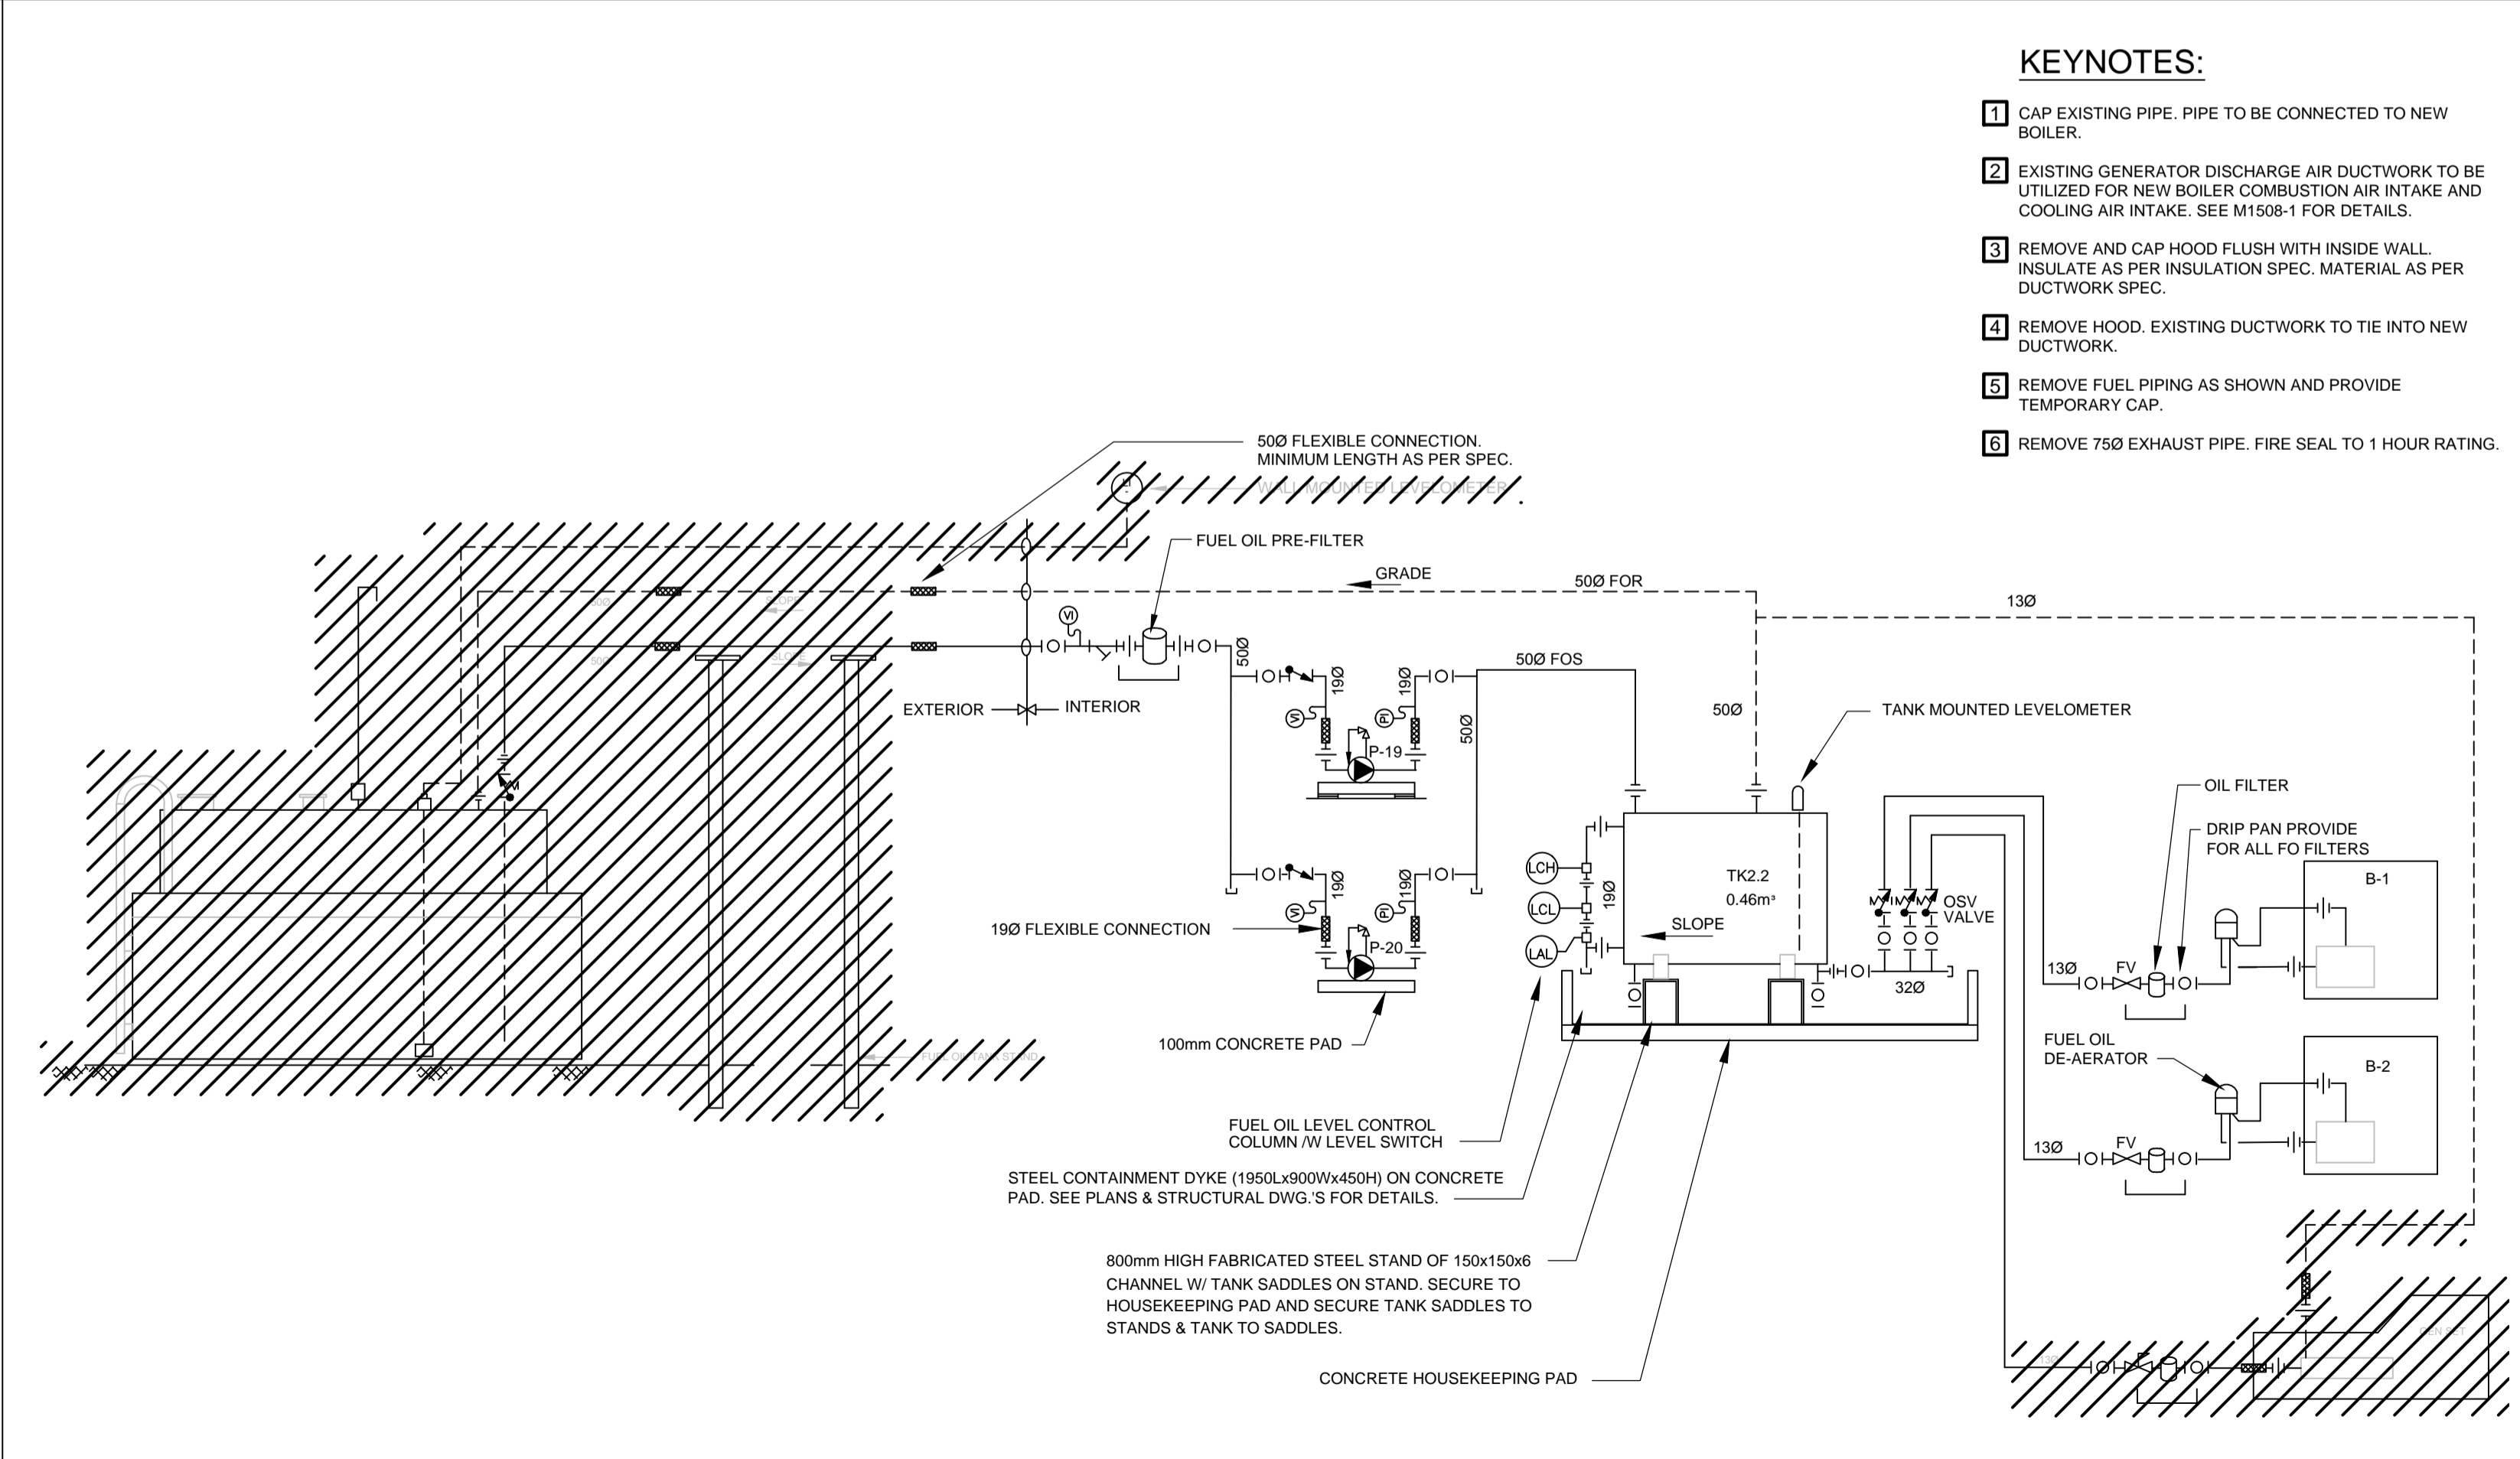

SCHEMATIC

FUEL OIL PIPING DEMOLITION

NOT TO SCALE

No.	Issue	Date
1	ISSUED FOR TENDER	2013-APR-10
2	RELEASED FOR CONSTRUCTION	2013-JUN-27



No.	Revision	Ckd. By	Date

PERMIT OF PRACTICE
EXP SERVICES INC.
Signature: *J. T. Davis*
Date: 2013/JUN/27
PERMIT NUMBER: P483
NT/NU Association of Professional Engineers and Geoscientists

RELEASED FOR CONSTRUCTION

	Const. North
	Drawn By: SET
	Dwg. Standards: PD
Date Printed:	Designed By: RJM
	Dwg. Design Ckd. By: JTD

exp Services Inc.
t: +1.613.688.1899 | f: +1.613.225.7330
2650 Queensview Drive, Unit 100
Ottawa, ON K2B 8H6
CANADA
www.exp.com

- BUILDINGS • EARTH & ENVIRONMENT • ENERGY •
- INDUSTRIAL • INFRASTRUCTURE • SUSTAINABILITY •

Project Title

WASTE WATER TREATMENT PLANT UPGRADE PANGNIRTUNG, NU

Dwg. Title

DEMOLITION

Project No.	OTT-00204430-A0
Dwg. No.	M1502 - 1
Rev. No.	0
Scale	AS SHOWN This drawing is not to be scaled