
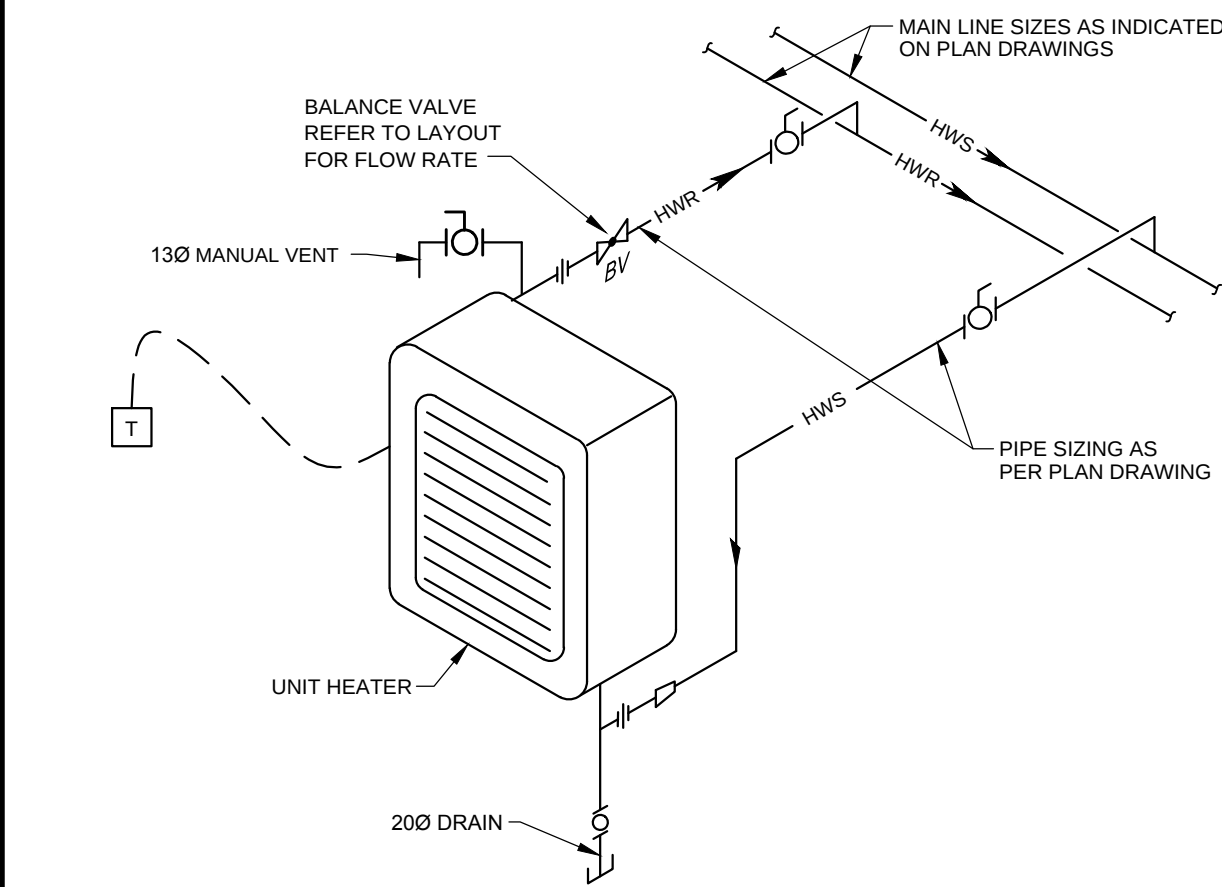



FILE C:\01\2020\03\24\PROJECT\02\SCHEMATIC\HEATING\DETAILS\SCHEMATIC.DWG

NOTED IN REVISIONS AS FOLLOWS
DATE: 2013-06-27

SCHEMATIC HEATING PIPING

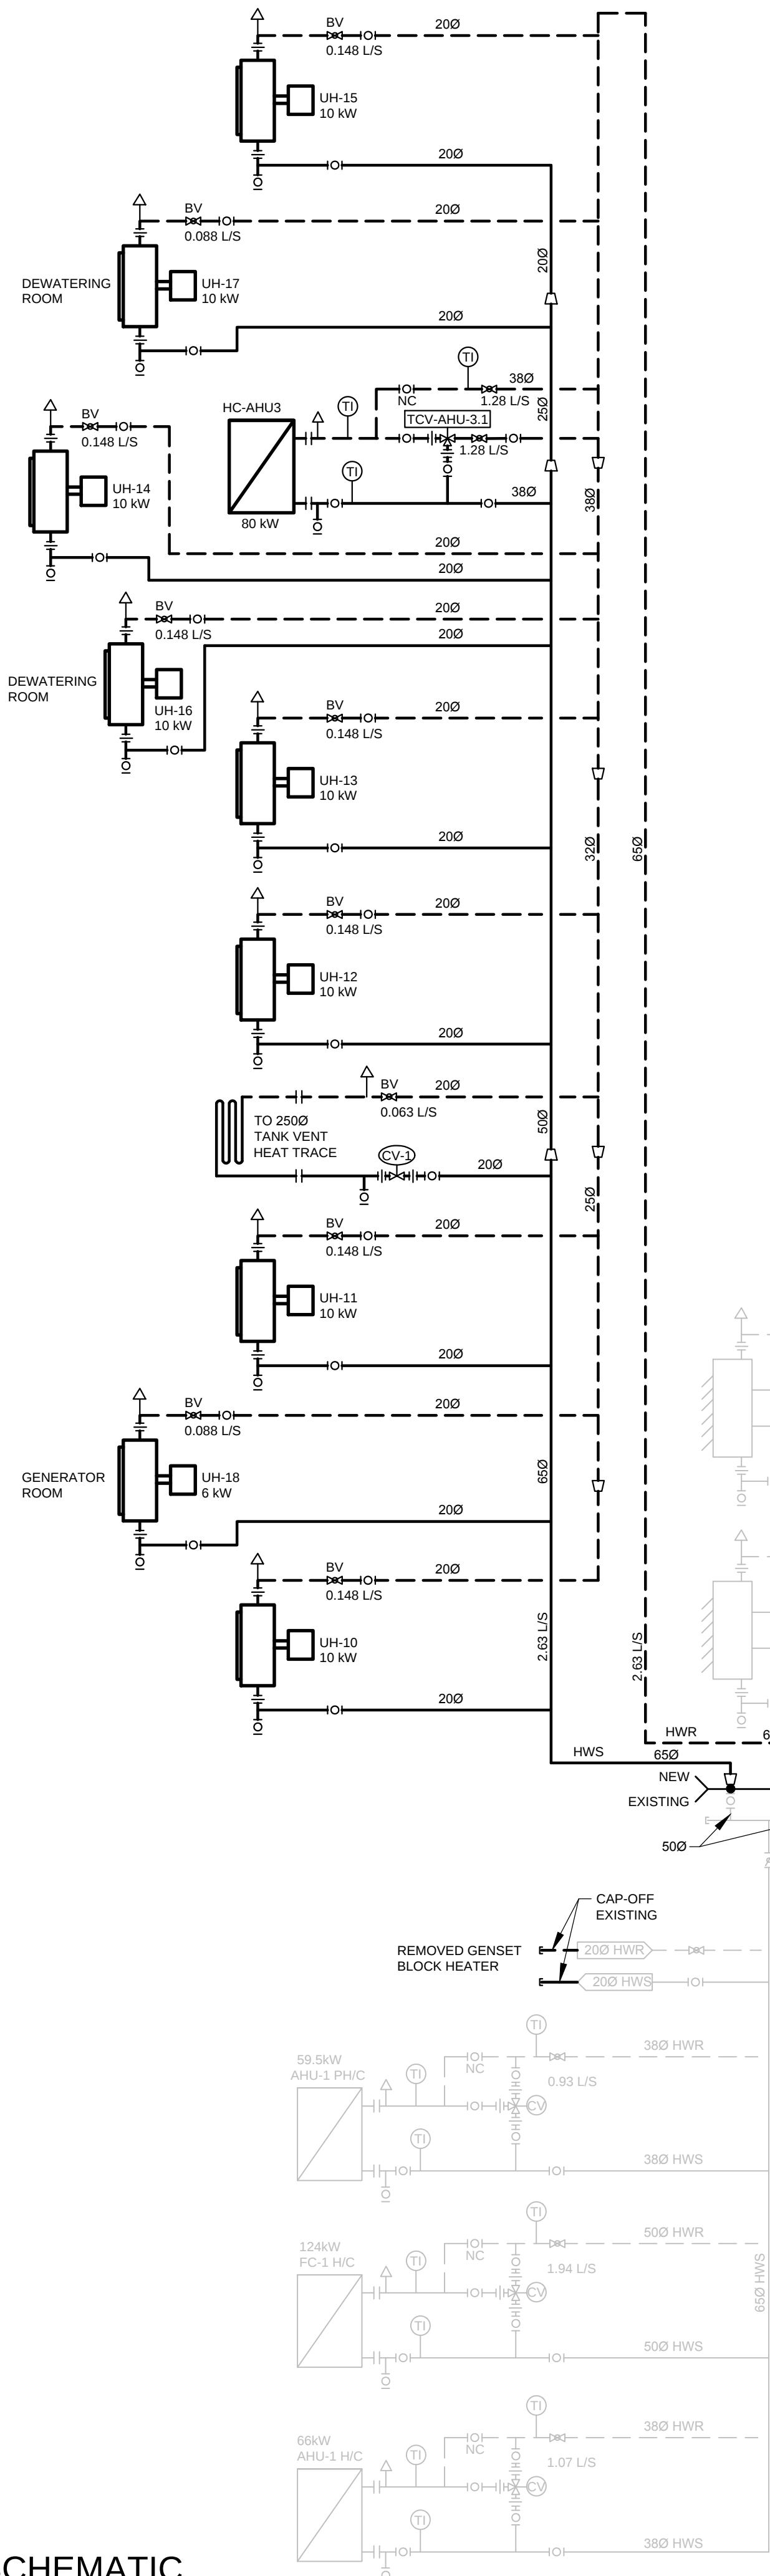

DETAIL
TYPICAL HORIZONTAL UNIT HEATER PIPING

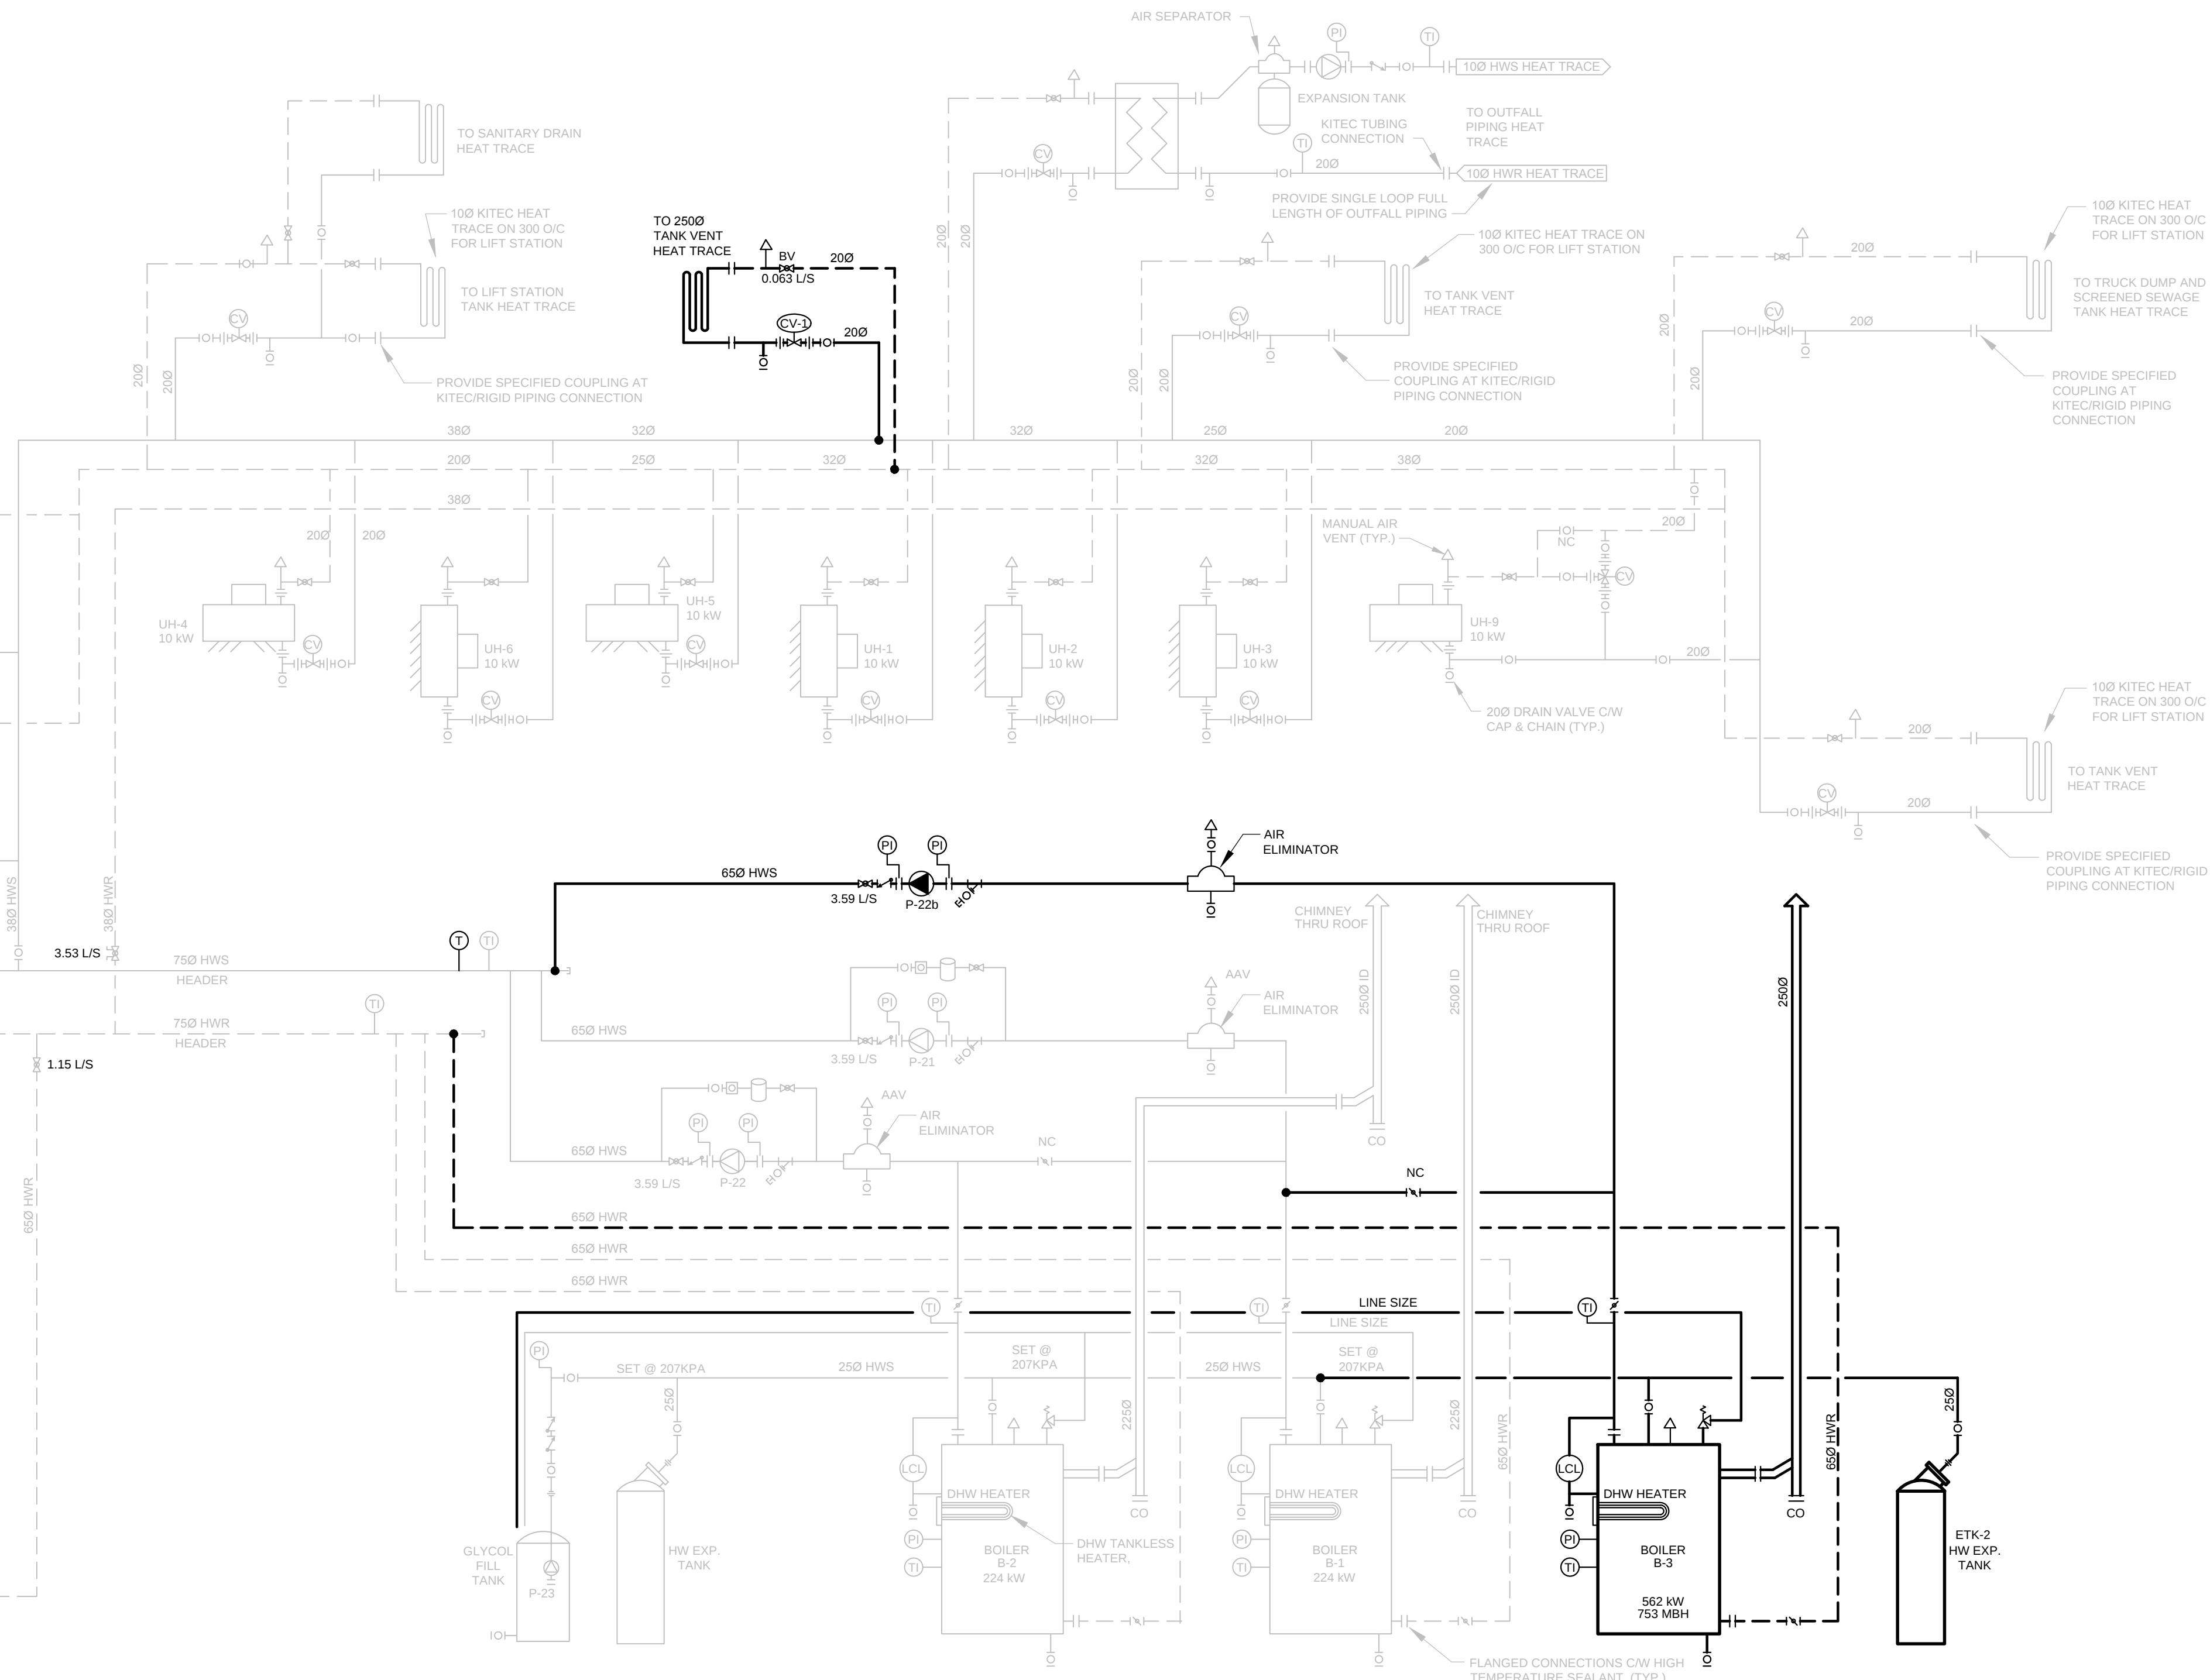

No.	Issue	Date
1	60% REVIEW SUBMISSION	2013-MAR-08
2	ISSUED FOR TENDER	2013-APR-10
3	RELEASED FOR CONSTRUCTION	2013-JUN-27



No.	Revision	Ckd. By	Date

PERMIT OF PRACTICE
EXP SERVICES INC.

Signature: *J. Davis*

Date: 2013/JUN/27

PERMIT NUMBER: P483
NT/NU Association of Professional
Engineers and Geoscientists

RELEASED FOR CONSTRUCTION

Const. North

Drawn By: SET

Dwg. Standards: PD

Designed By: RJM

Date Printed: JTD

Dwg. Design: JTD

exp Services Inc.

t: +1.613.688.1899 | f: +1.613.225.7330
2650 Queensview Drive, Unit 100
Ottawa, ON K2B 8H6
CANADA

www.exp.com

exp.

- BUILDINGS • EARTH & ENVIRONMENT • ENERGY •
- INDUSTRIAL • INFRASTRUCTURE • SUSTAINABILITY •

Project Title

WASTE WATER
TREATMENT PLANT
UPGRADE
PANGNIRTUNG, NU

Dwg. Title

HEATING DETAILS
AND SCHEMATICS

Project No.	OTT-00204430-A0	Rev. No.	0
Dwg. No.	M1505 - 1	Rev. No.	0
Scale	NOT TO SCALE This drawing is not to be scaled		