


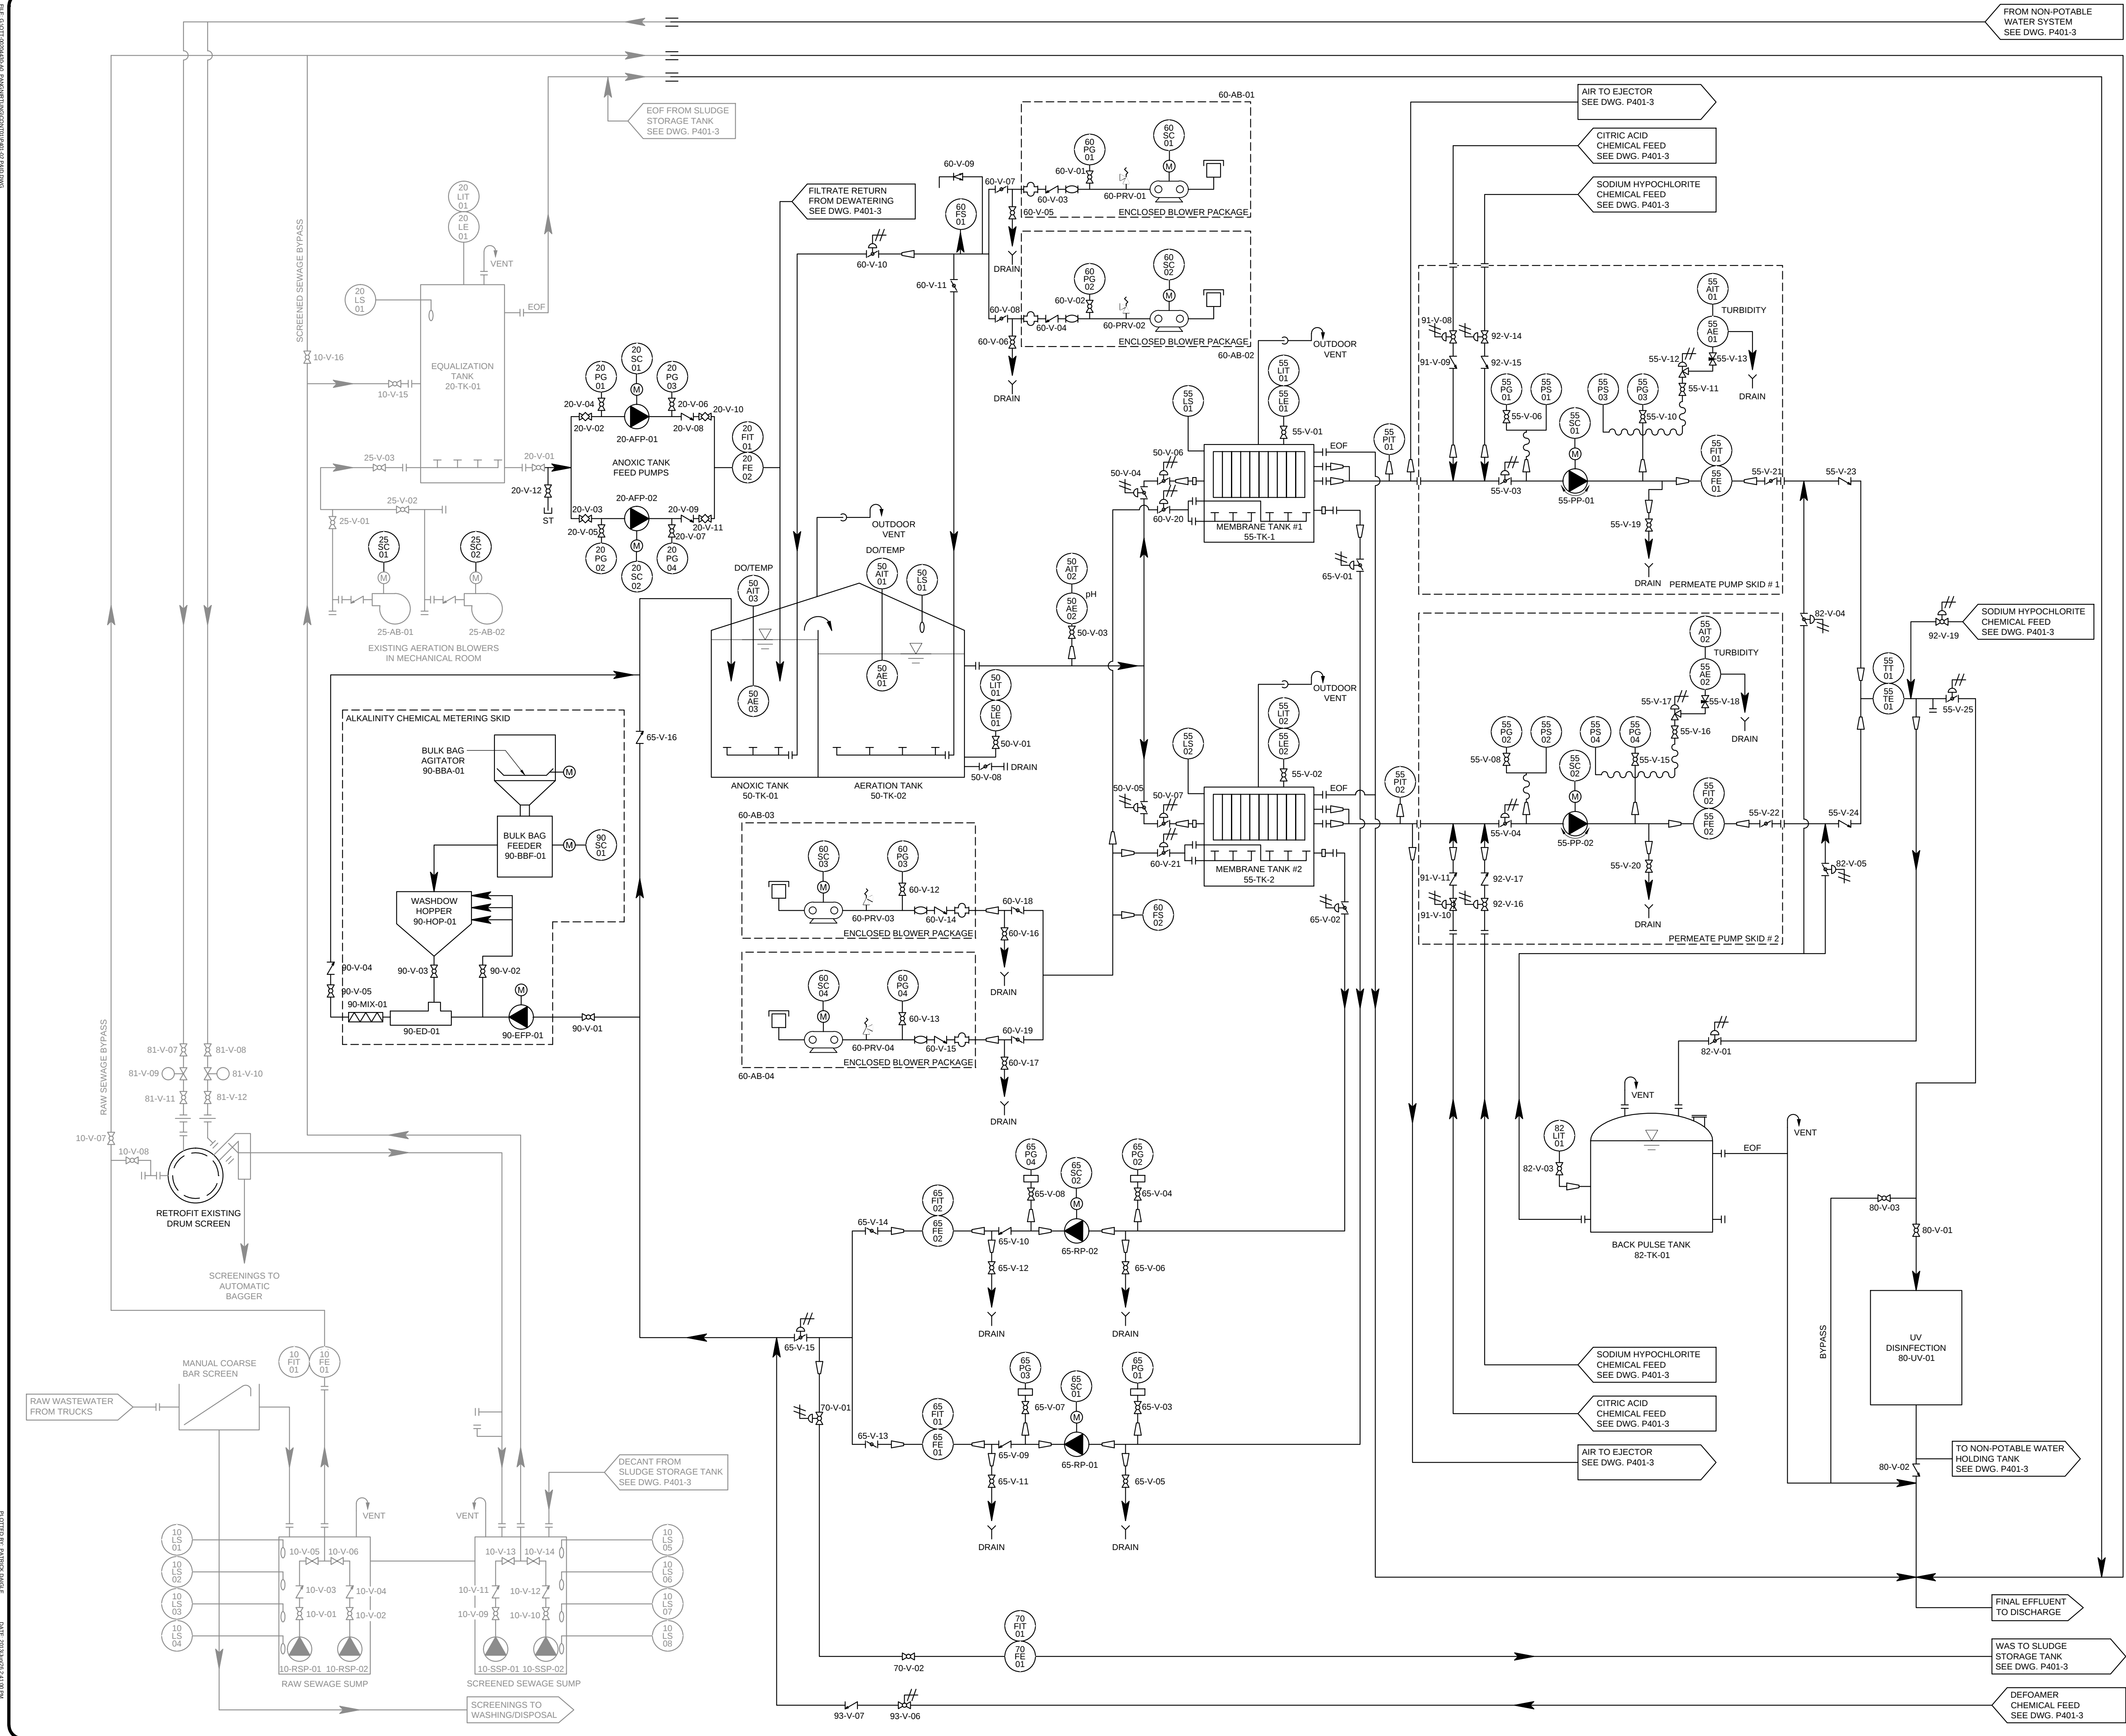

No.	Issue	Date
1	60% REVIEW SUBMISSION	2013-MAR-08
2	ISSUED FOR TENDER	2013-APR-10
3	RELEASED FOR CONSTRUCTION	2013-JUN-27

No.	Revision	Ckd. By	Date

PERMIT OF PRACTICE
EXP SERVICES INC.
Signature: *[Signature]*
Date: 2013/JUNE/27
PERMIT NUMBER: P483
NT/NU Association of Professional Engineers and Geoscientists

FOR INFORMATION ONLY

Const. North	
Drawn By:	ARL/MCO
Dwg. Standards	PD
Designed By:	DFB
Dwg. Design	SAO

exp Services Inc.
t: +1.613.688.1899 | f: +1.613.225.7330
2650 Queensview Drive, Unit 100
Ottawa, ON K2B 8H6
CANADA
www.exp.com

• BUILDINGS • EARTH & ENVIRONMENT • ENERGY •
• INDUSTRIAL • INFRASTRUCTURE • SUSTAINABILITY •

Project Title

WASTE WATER TREATMENT PLANT UPGRADE
PANGNIRTUNG, NU

Dwg. Title

PROCESS AND INSTRUMENTATION DIAGRAM (P&ID)

Project No. OTT-00204430-A0

Dwg. No.	Rev. No.
P401-2	0

Scale

NOT TO SCALE
This drawing is not to be scaled