



- PUMPS GRUNFOS MODEL SP 95-1-A
 FLOW METER McCROMETER MODEL MW500
 100mm PROPELLER TYPE
 FILTERS HARMSCO HURRICANE FILTER HOUSING (HUR-170-1)
 FILTER CARTRIDGES (PP-HC-170-1)

**TRUCK FILL BUILDING
FLOOR PLAN**
1:25


PARTS LIST	
MARK	DESCRIPTION
1	100mm ELBOW
2	100mm TEE
3	100x50mm REDUCER
4	50mm BUTTERFLY VALVE
5	50mm UNION
6	HUR 170 HP FILTER
7	100mm WATER METER
8	100x25 COMDOMION FLANGE
9	25mm SOLENOID VALVE

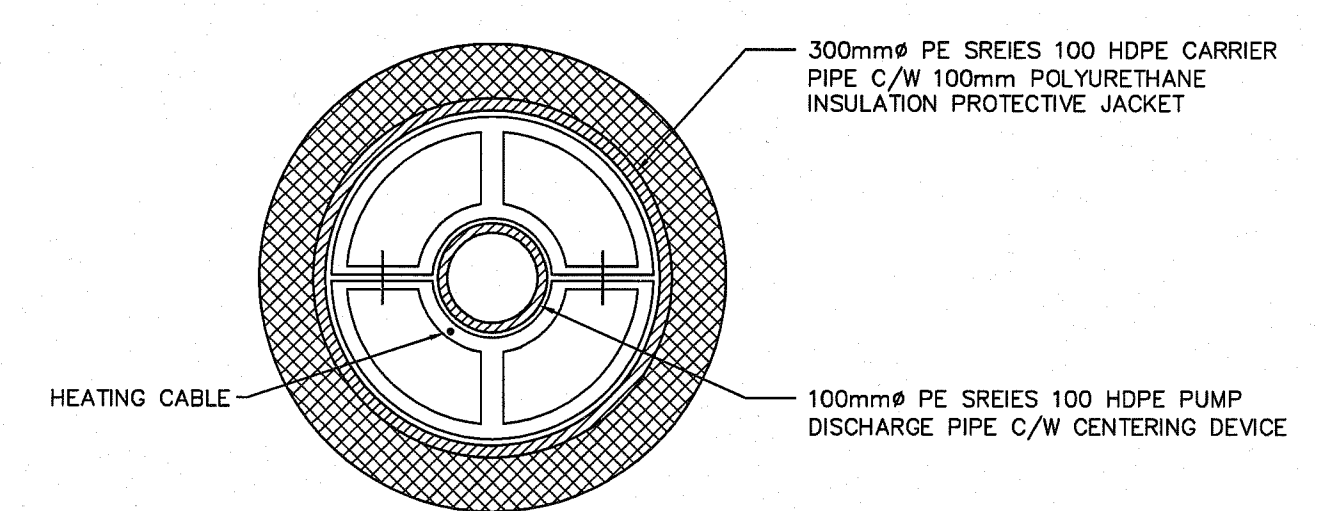


SECTION D-D
NTS

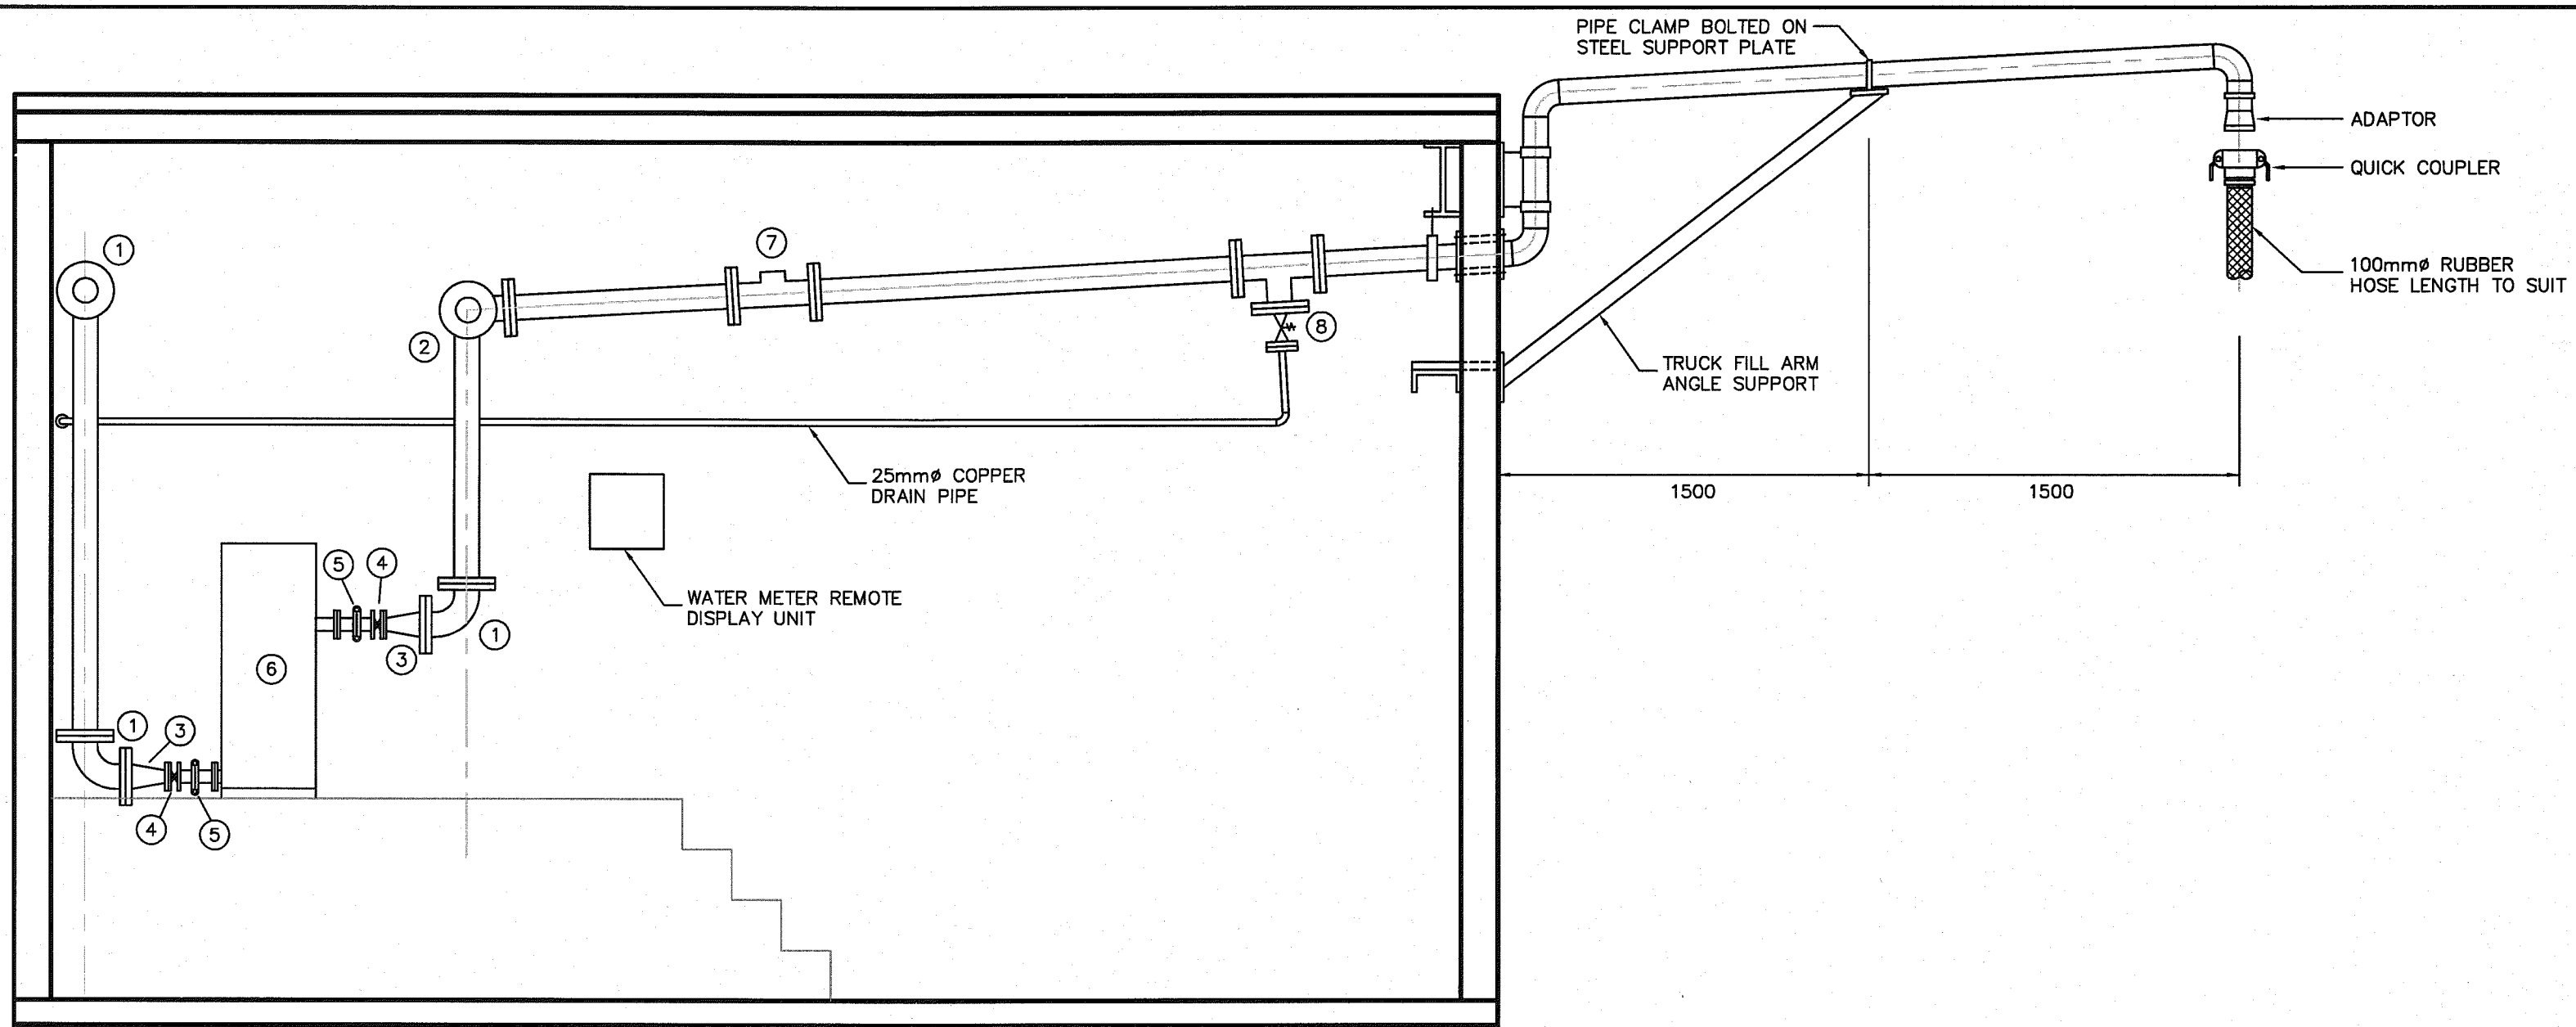


SECTION A-A
1:25

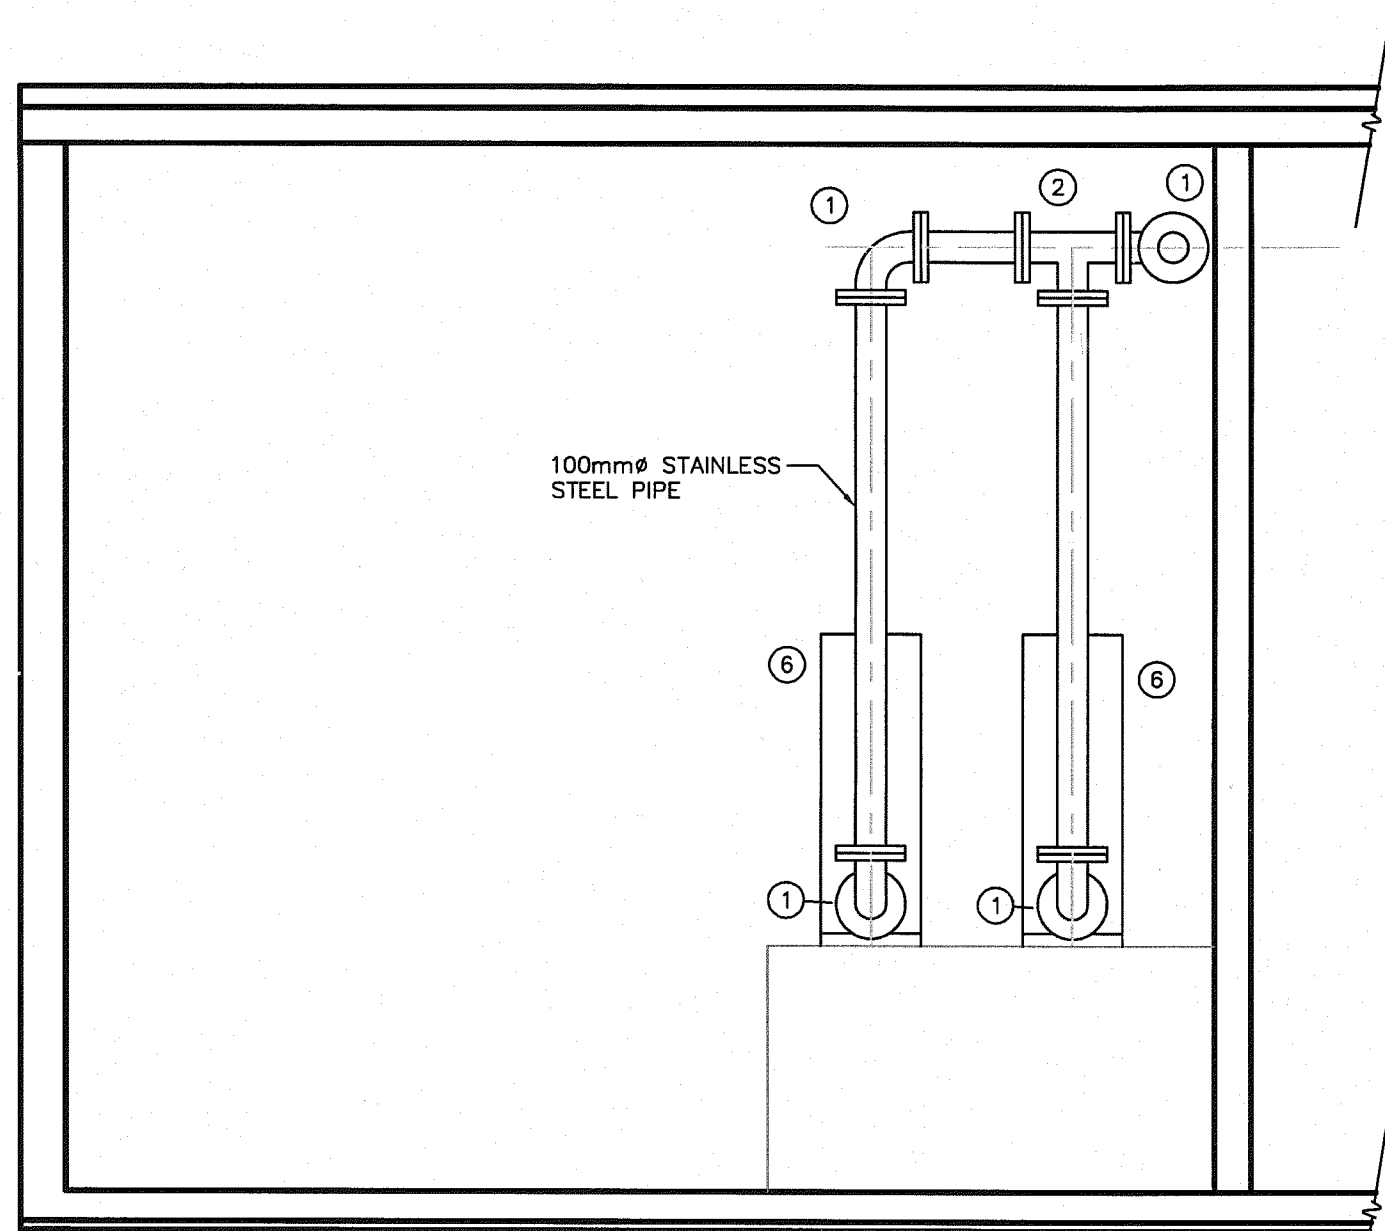


SECTION C-C
1:25

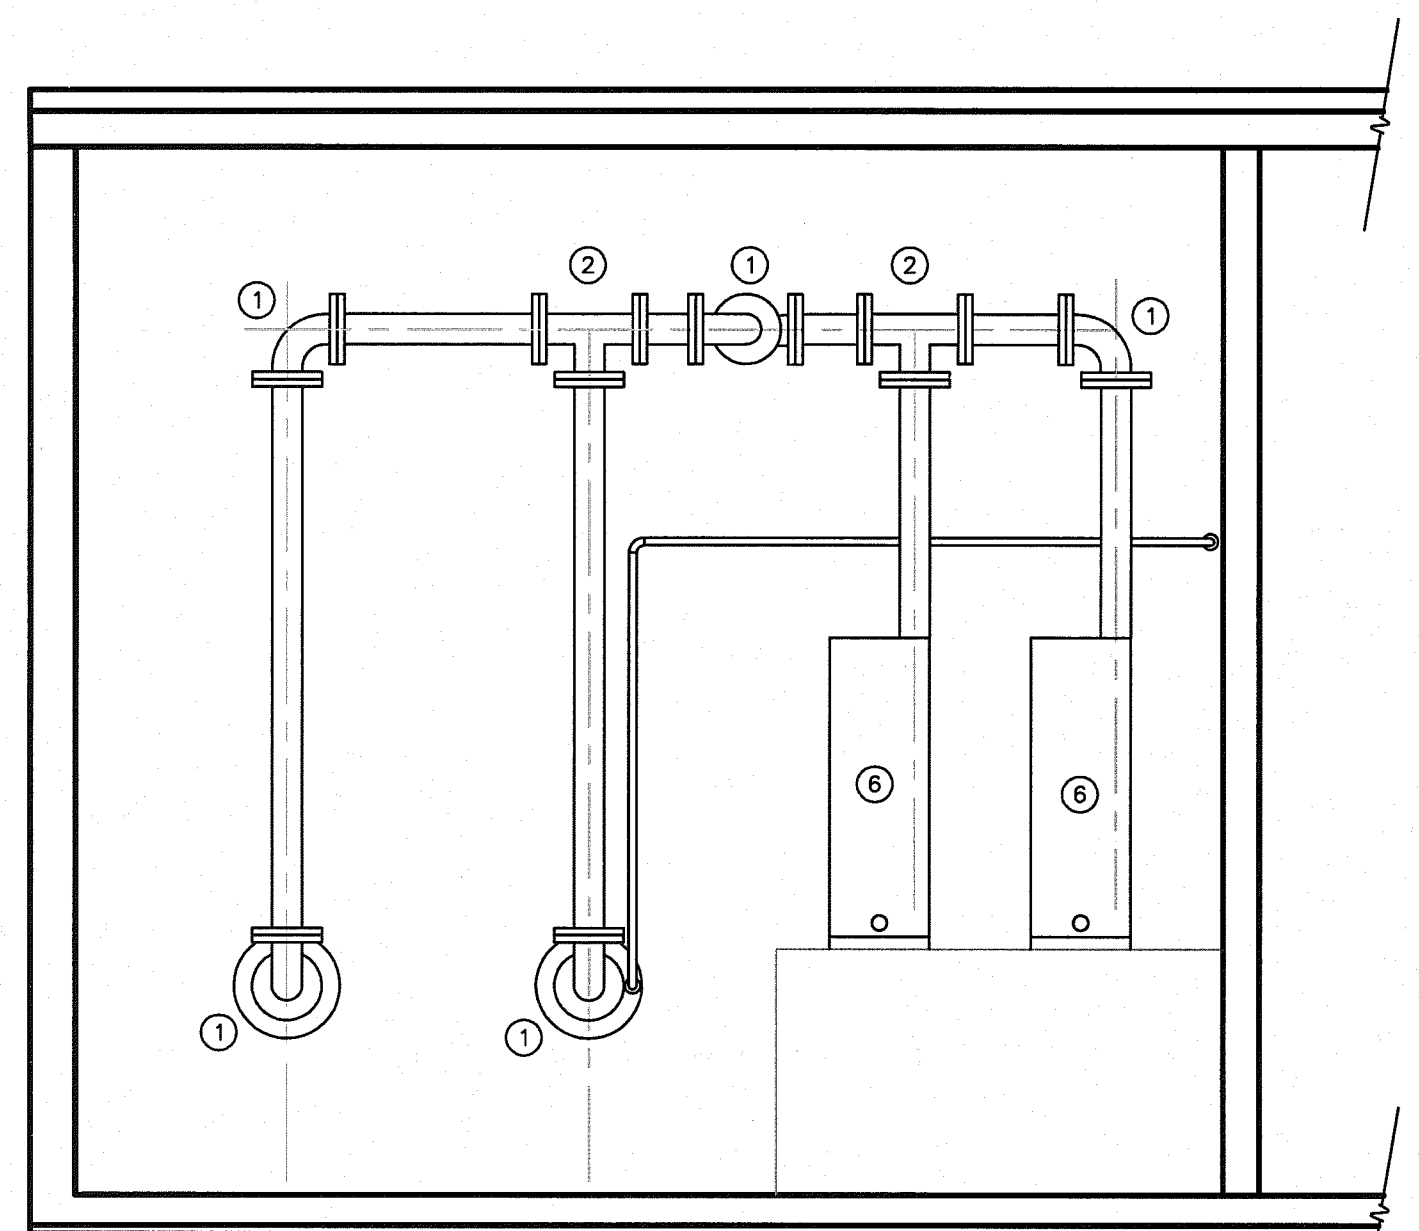

SECTION B-B
1:25

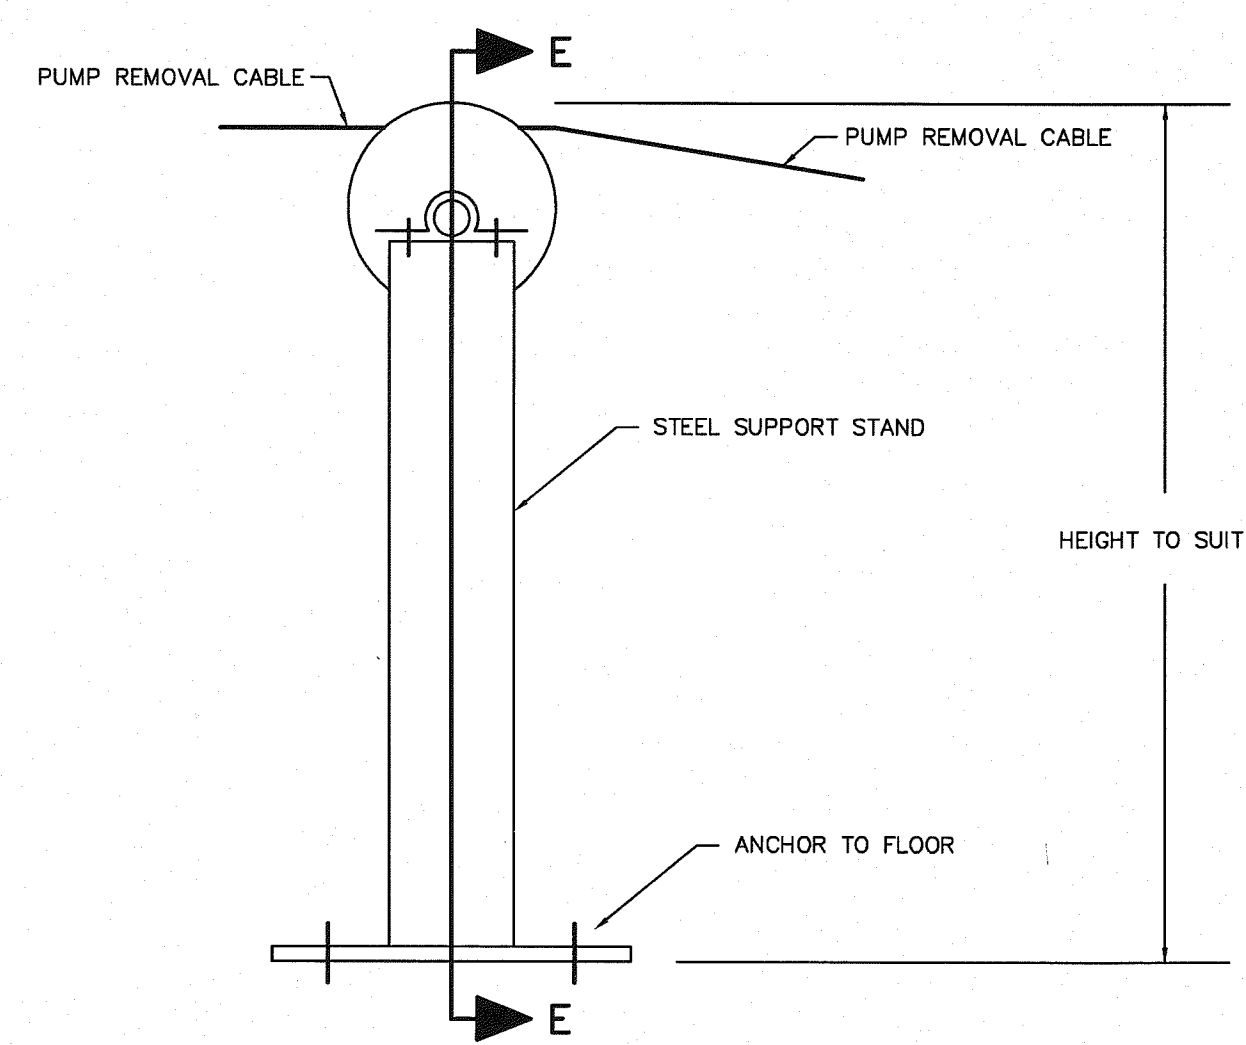

CABLE GUIDE
NTS

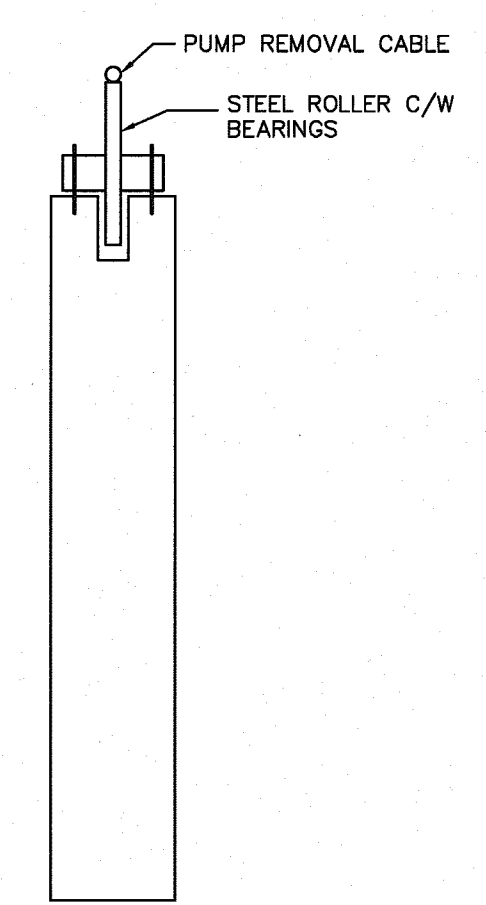

SECTION E-E
NTS

No.	Issue / Revision	Date
1	Client Review and Approval (Detailed Design)	Jan 31, 2006
2	Client Review and Approval (Construction Documents)	Apr 13, 2006
3	Client Review and Approval (Construction Documents)	May 8, 2006
4	Issued for Tender	Jun 6, 2006
5	As Built	January 2010

NOTE:
REMOVED EXISTING TRUCK FILL
PIPING AND SUPPLY AND INSTALL
NEW 100mm PIPING AS SHOWN

AS-BUILT
NOTE: This drawing has been prepared by "Nuna Burnside Engineering and Environmental Ltd." based solely on information provided by a third party that reflects the constructed conditions of the system and is believed to be correct. Those relying on this information are advised to obtain independent verification as to its accuracy before applying it for any purpose.

NUNA BURNSIDE
Nuna Burnside Engineering and Environmental Ltd.
Box 175, 25 Third Avenue, Rankin Inlet, NU
Telephone (867) 645-2792 fax (867) 645-2765
15 Townline, Orangeville, Ontario
Telephone (519) 941-0342 fax (519) 941-8120
email info@nunaburnside.com
web www.nunaburnside.com

Client: **GOVERNMENT OF NUNAVUT
COMMUNITY AND
GOVERNMENT SERVICES**
P.O. BOX 379
POND INLET, NUNAVUT
X0A 0S0

Drawing Title WATER RESERVOIR, SEWAGE LAGOON AND LANDFILL IMPROVEMENTS QIKQTARJUAQ, NUNAVUT TRUCK FILL STATION UPGRADES FLOOR PLAN AND X-SECTIONS	
Drawn By K. Pridham	Checked By M. O'Hara
Scale 1:25	Project No. N-009439
Drawing No. 15	