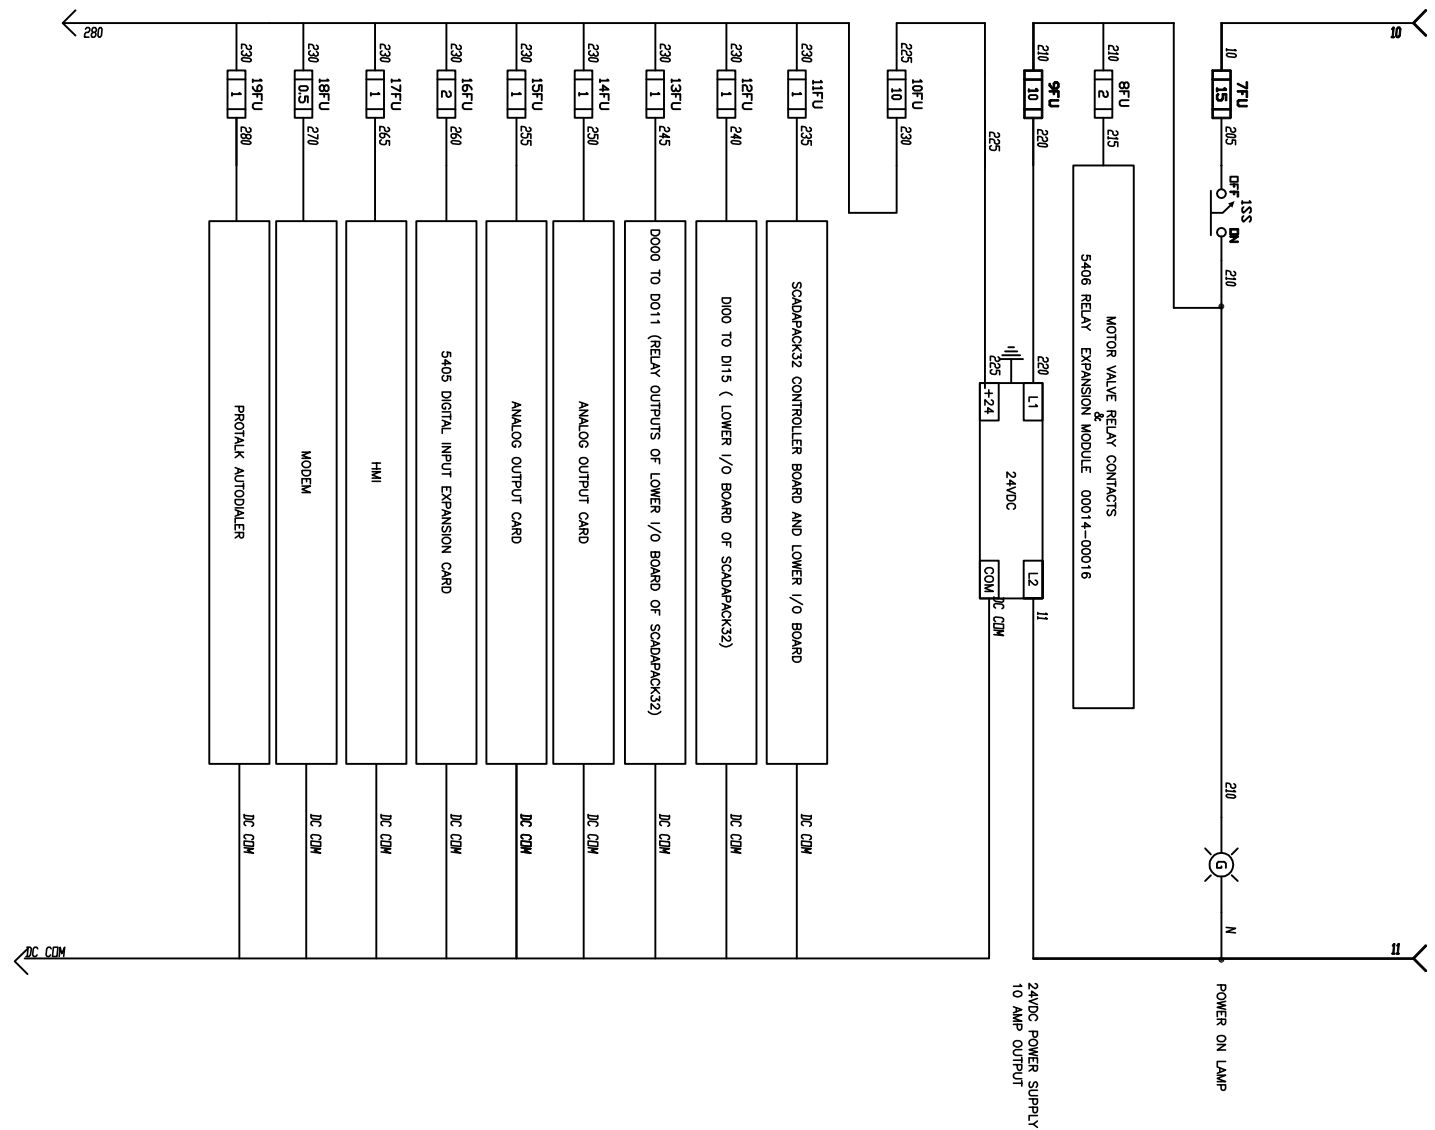
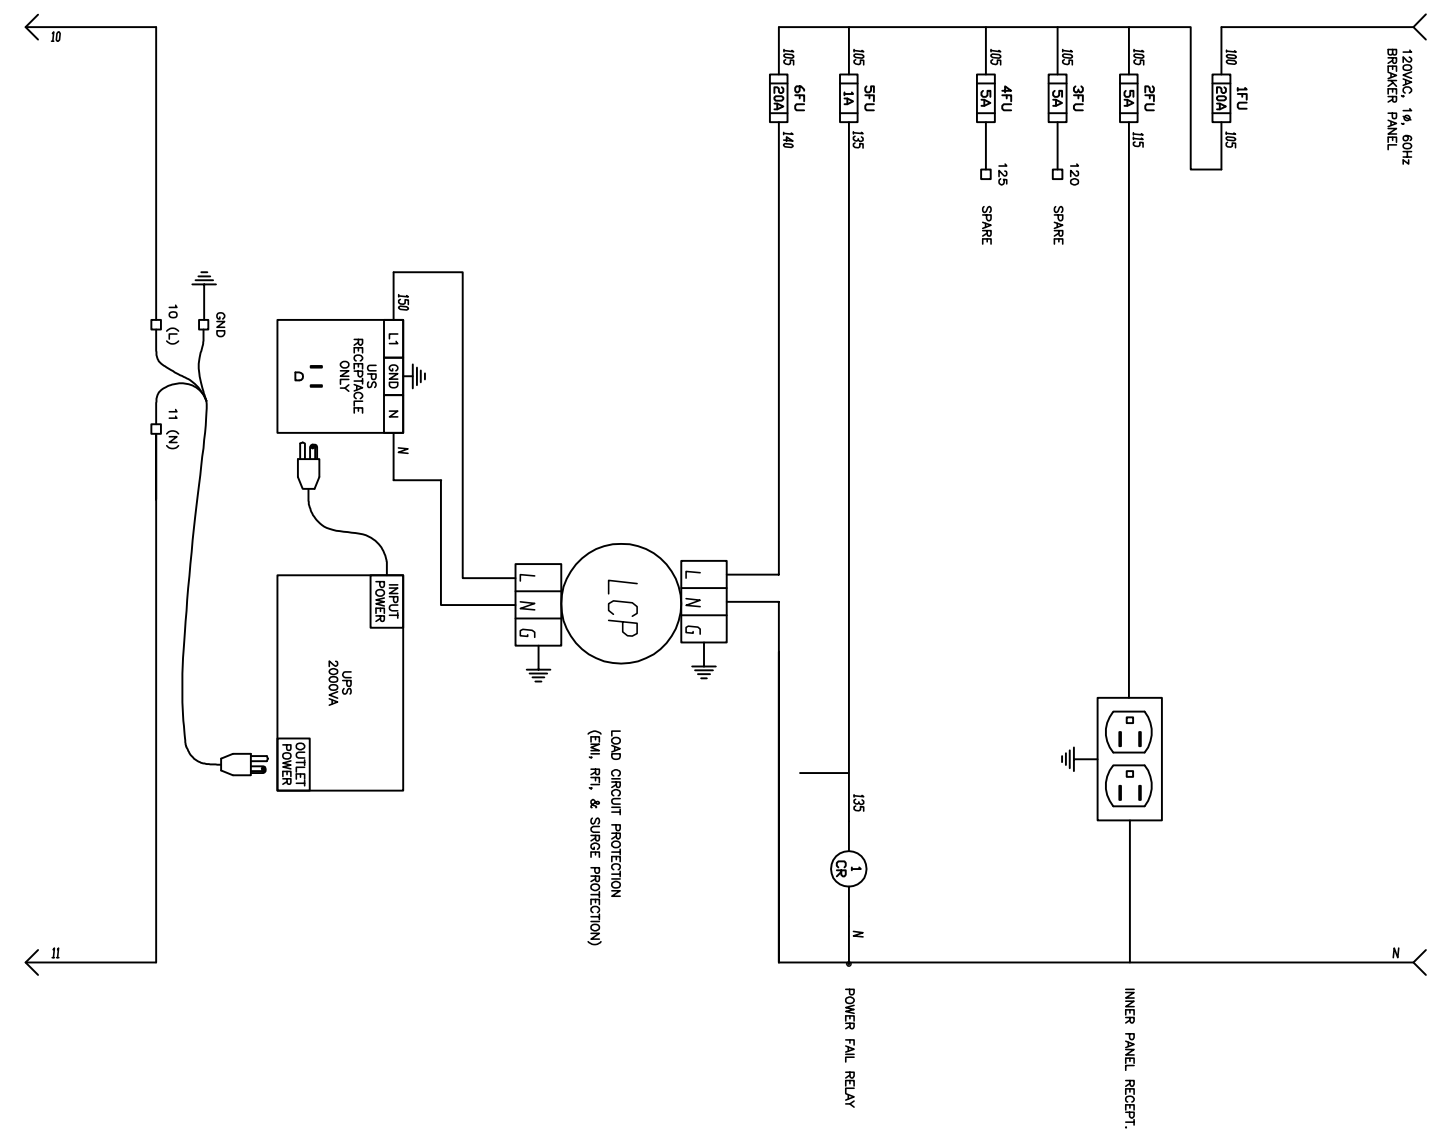


BI Pure Water
(Canada) Inc.

#2, 9790 - 190th Street
Surrey, BC V4N 3M9
Phone: (604) 882-6655
Fax: (604) 882-6659
<http://www.bipurewater.com>

#2, 9790 - 190th Street,
Surrey, BC V4A 3M9
Phone: (604) 882-6650
Fax: (604) 882-6659
<http://www.bipurewater.ca>

Status

[illegible]

Design By:	DL
Drawn By:	KD
Checked By:	JK
Submitted	
Approved	

Clients:

KITNUNA
PROJECTS
INC.

Time

CONTROLS SCHEMATIC

Scale

Date /









Sheet

Project: **POTABLE WATER
TREATMENT PLANT**

Job#

001-73-711.

53

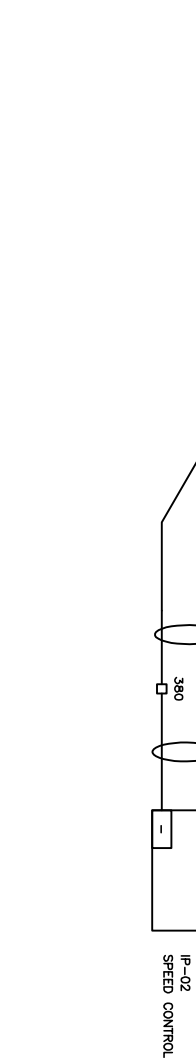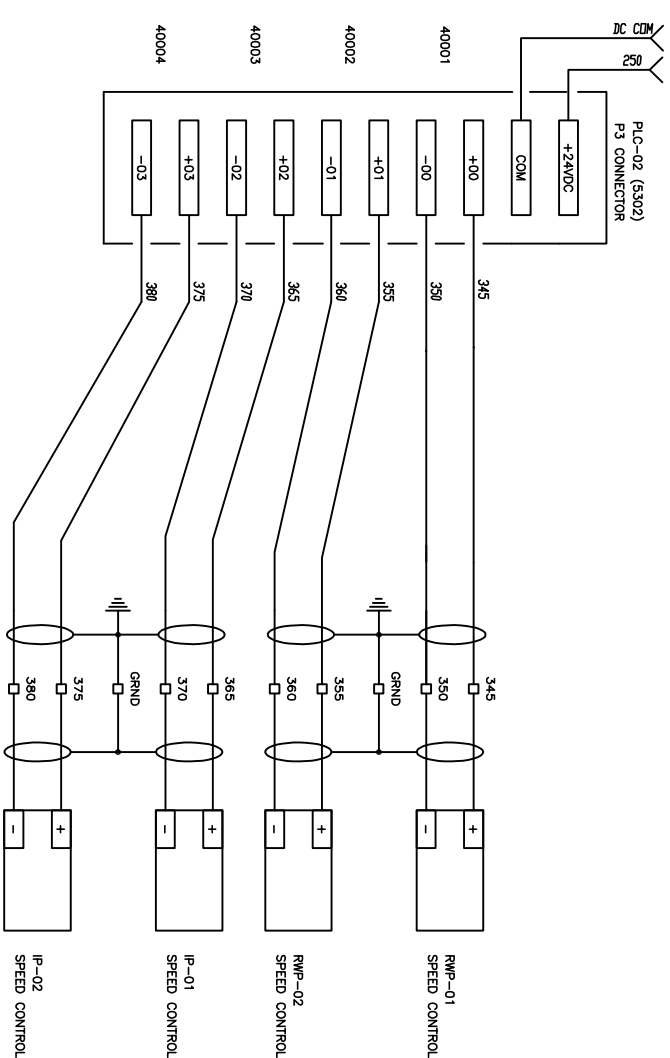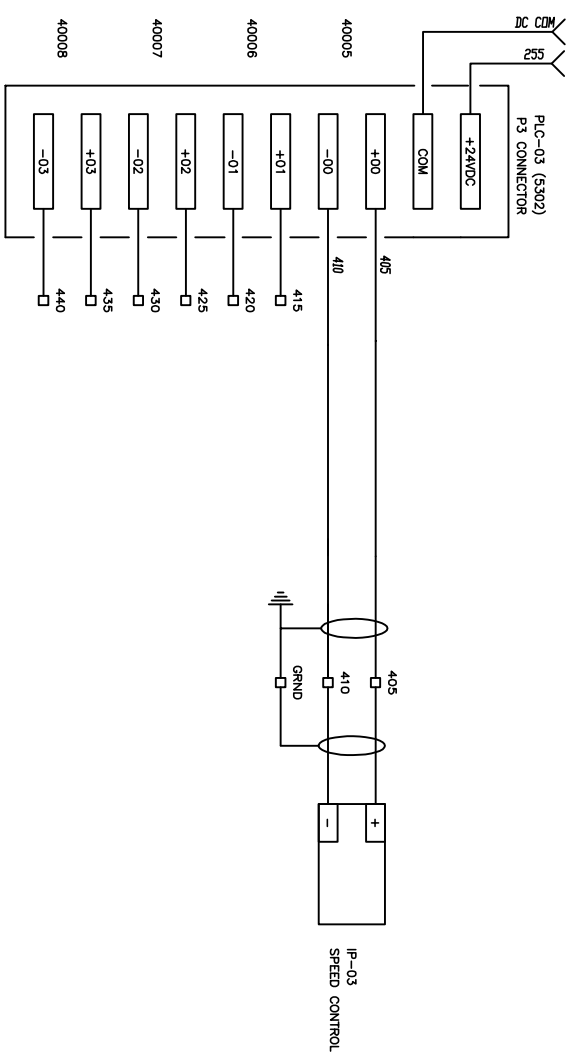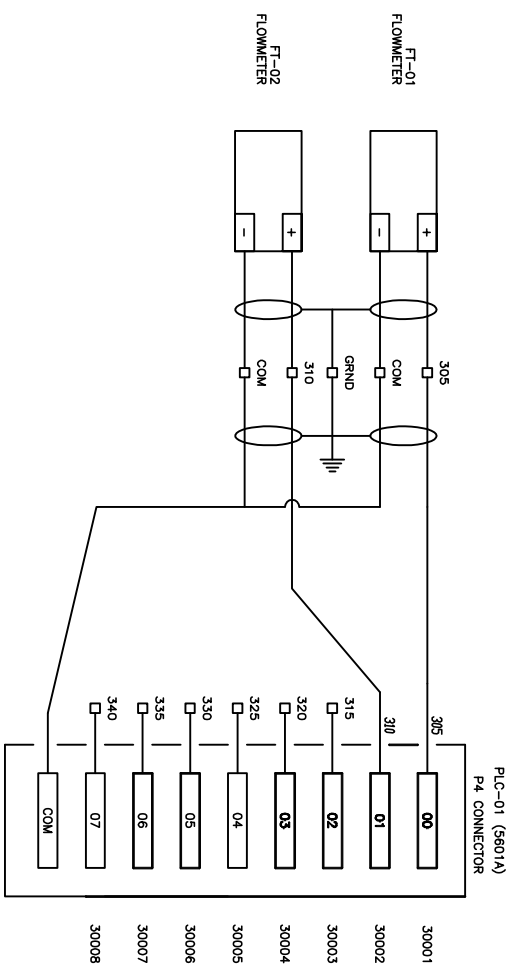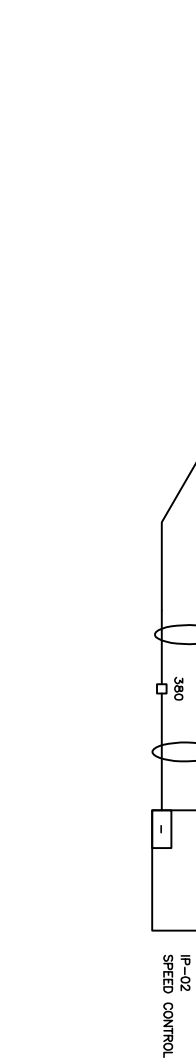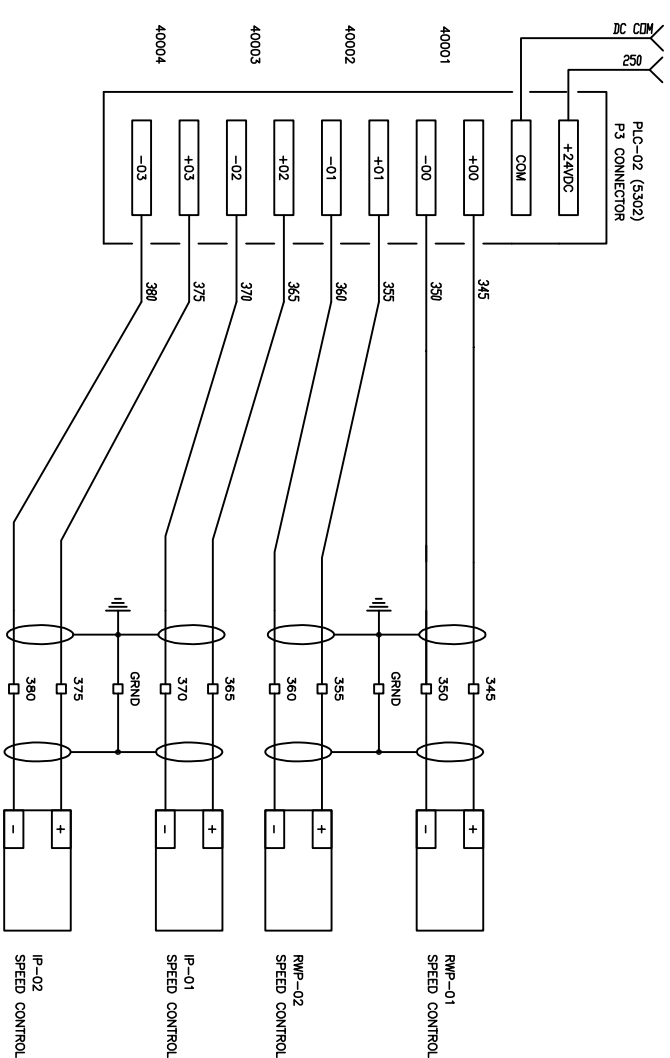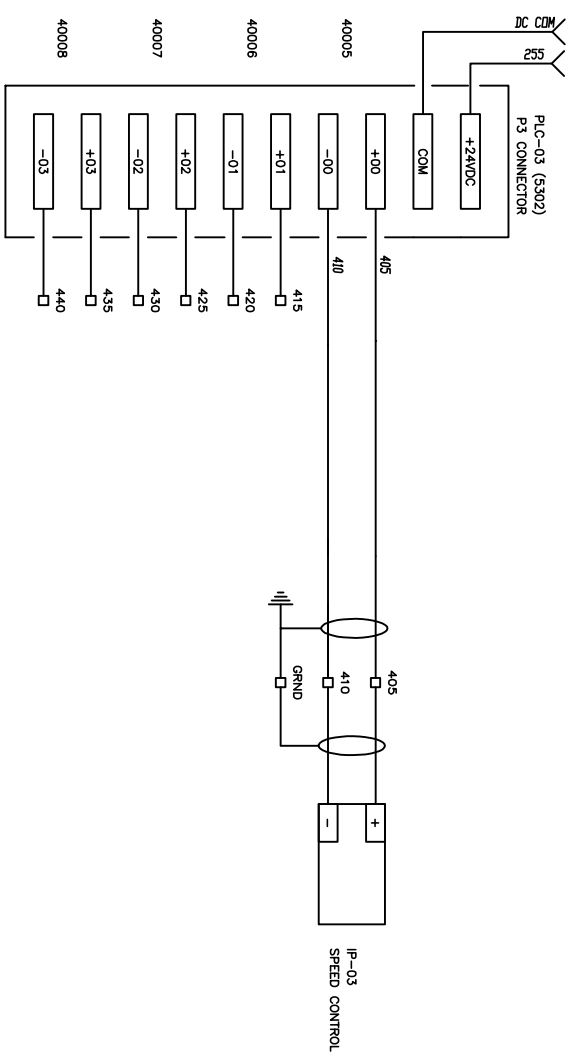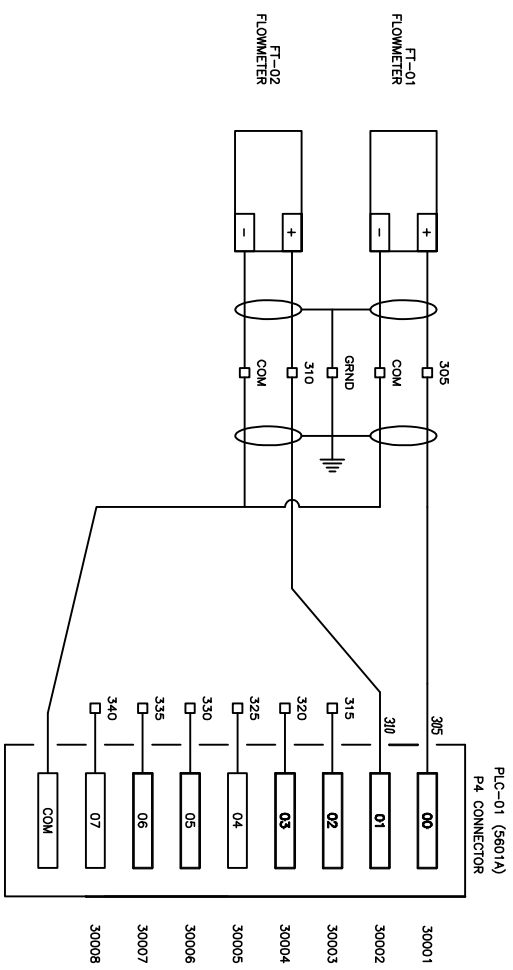

**BI Pure Water
(Canada) Inc.**



#2, 9790 - 130th Street
Surrey, BC V4N 3M9
Phone: (604) 882-6650
Fax: (604) 882-6659
<http://www.bipurewater.ca>

THE WRITTEN PERMISSION OF
BI PUREWATER (CANADA) INC.,
IS STRICTLY PROHIBITED.

BIPURE WATER (CANADA) INC.

THE WRITTEN PERMISSION OF
PUREWATER (CANADA) INC.
IS STRICTLY PROHIBITED.

AS BUILT

[illegible]

Client:

KITNUNA
PROJECTS
INC.

CONTROLS SCHEMATIC

Scale	NTS
-------	-----

Date AUG 26, 2011

Sheet 3 of 7

Job# 1772

Job# 1772

Rev: 03

03 New

Scale	NTS
-------	-----

Date AUG 26, 2011



Sheet 3 of 7

Job# 1772

Job# 1772

Rev: 03

03 New

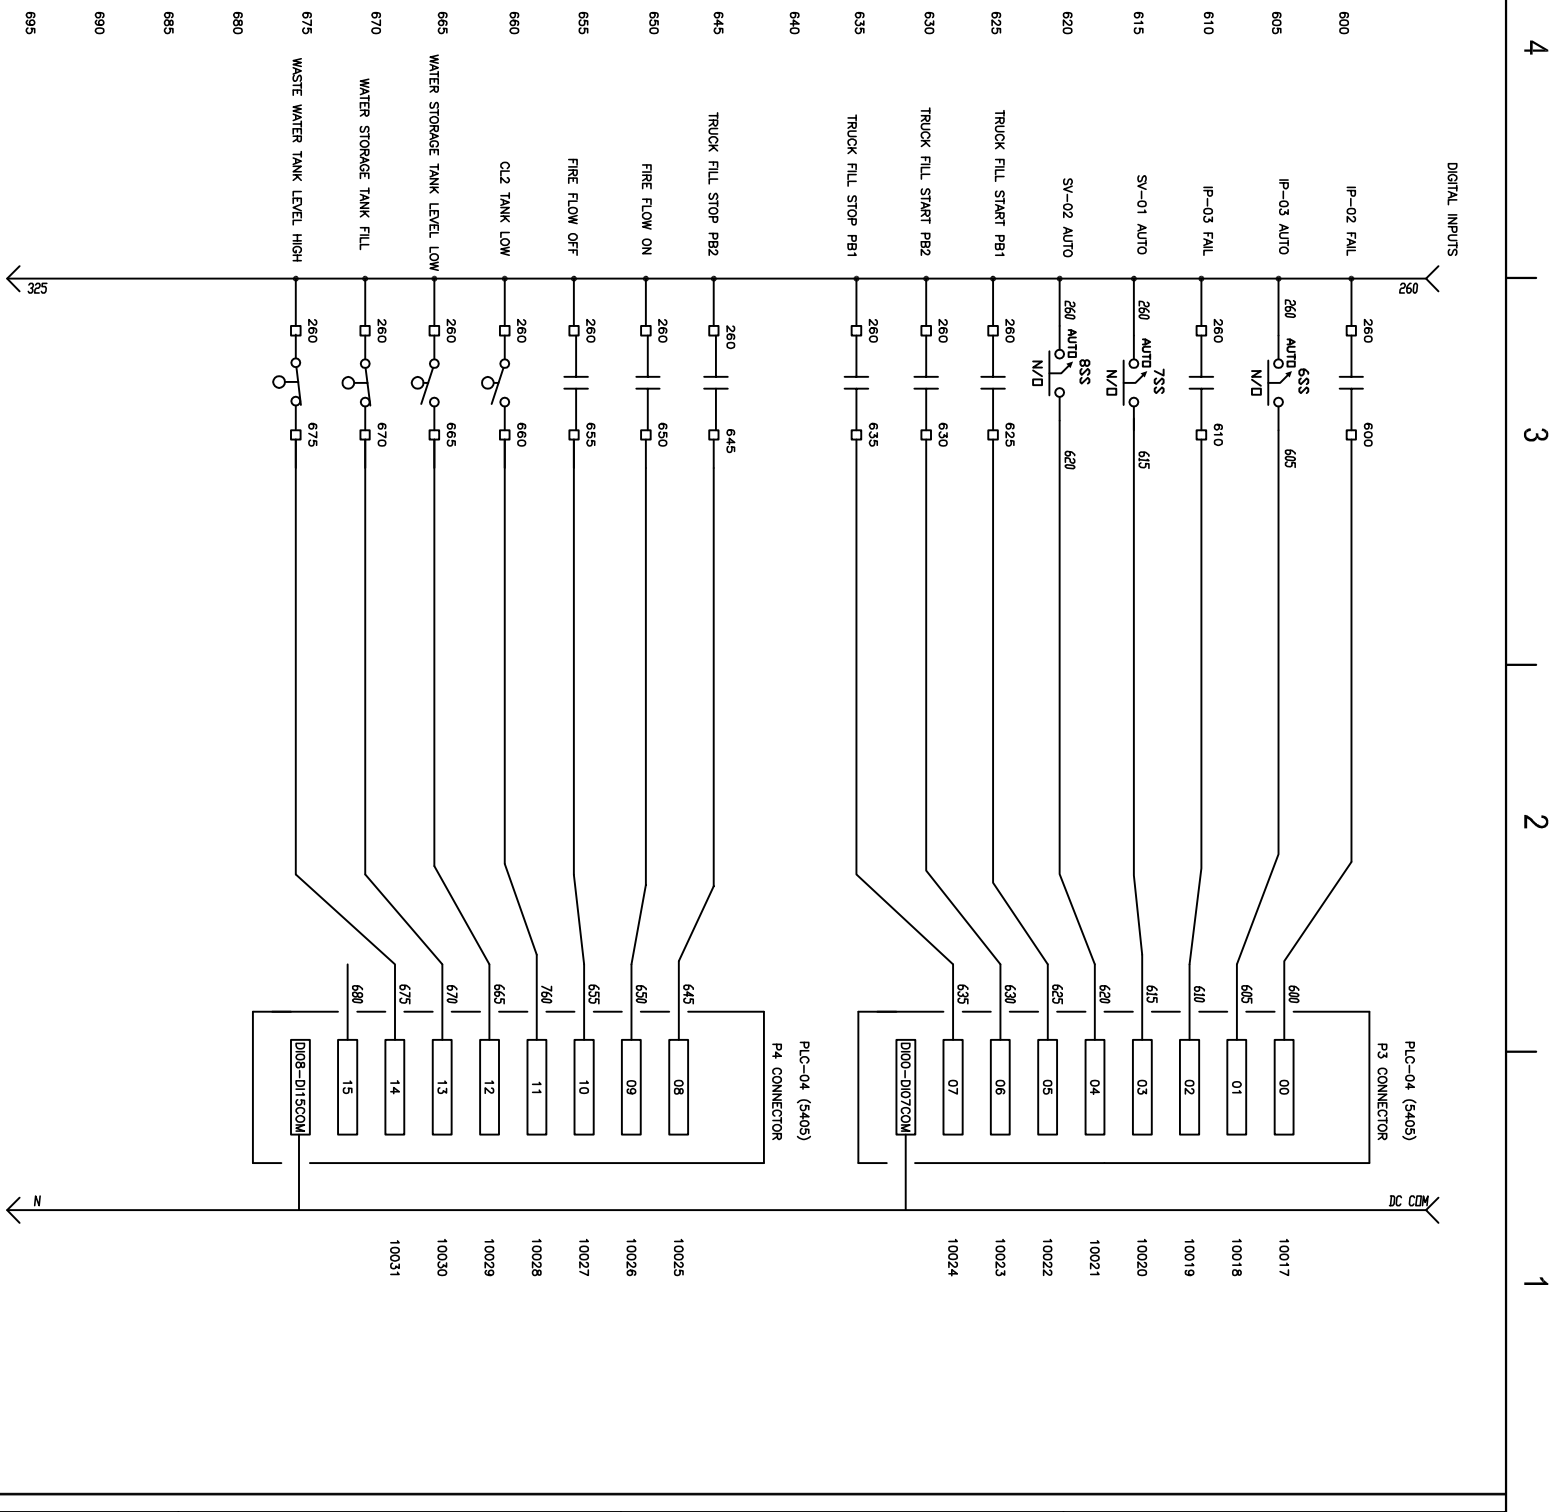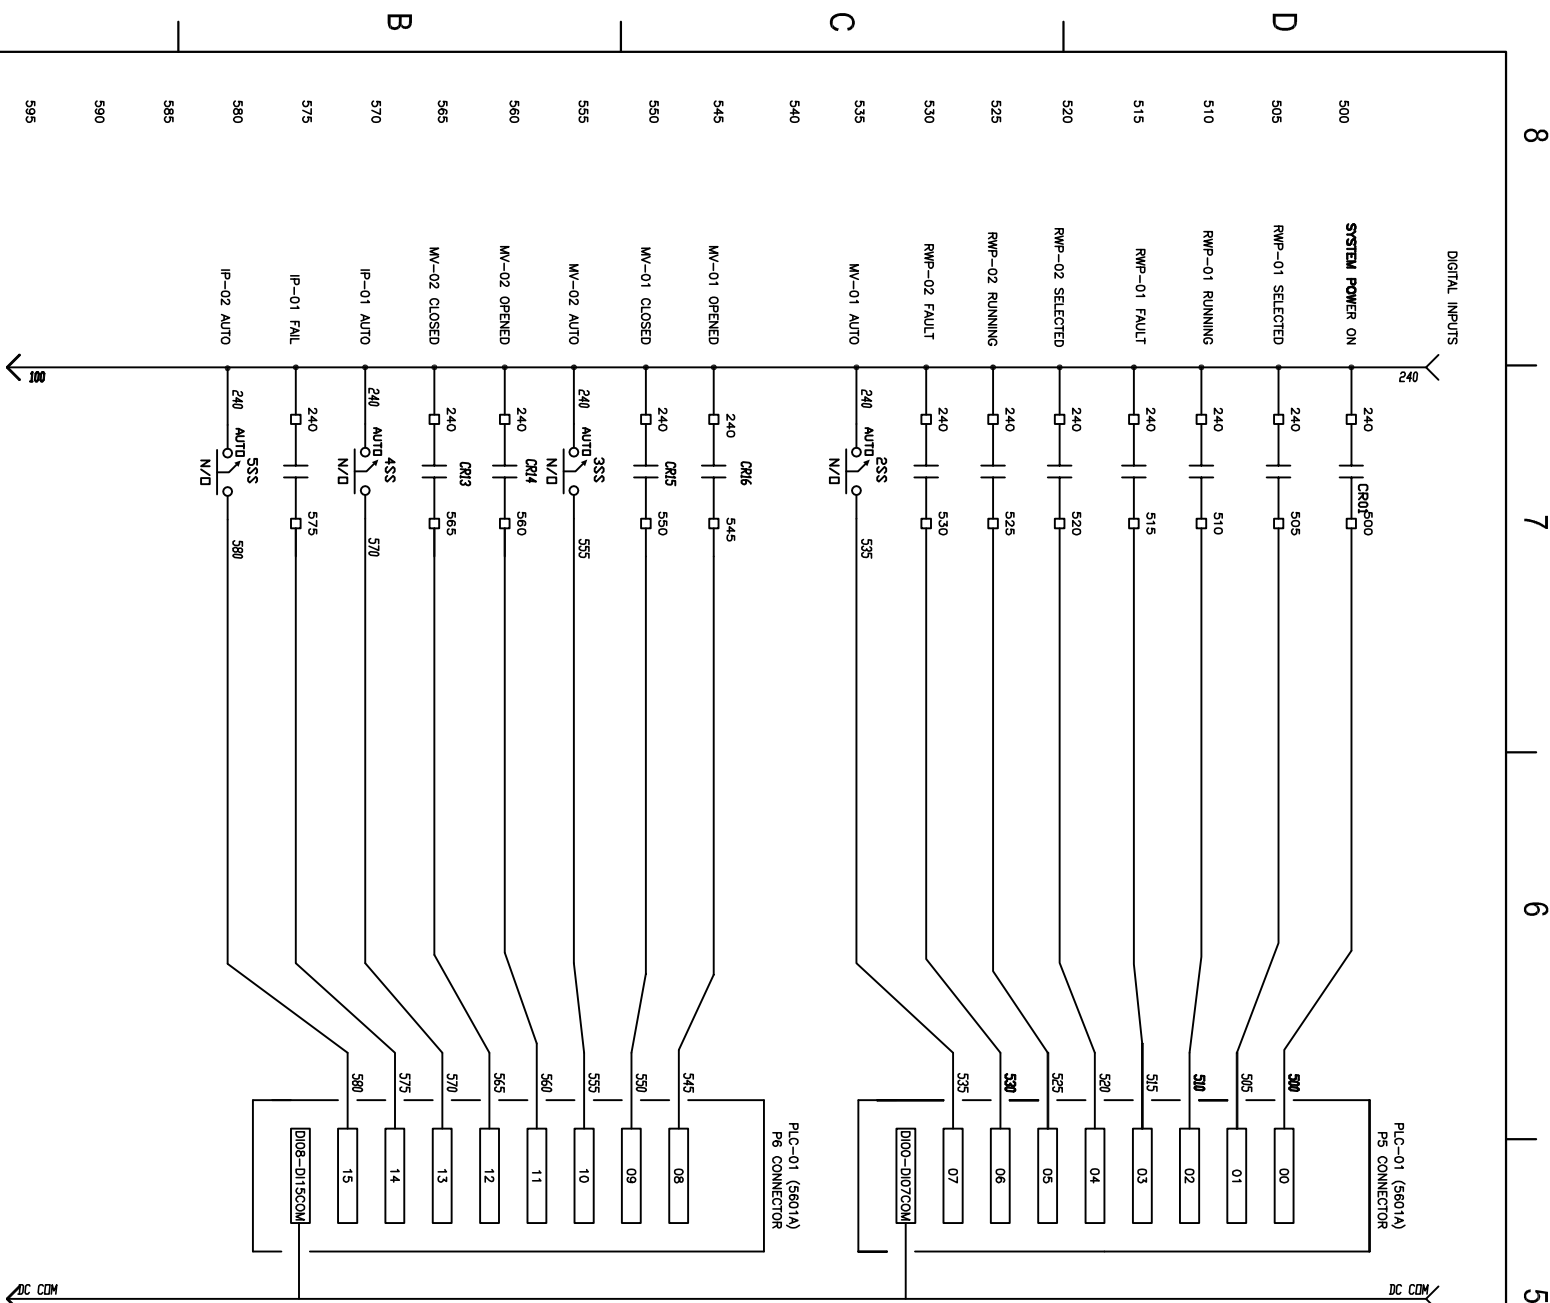

**BI Pure Water
(Canada) Inc.**



#2, 9790 - 190th Street
Surrey, BC V4N 3M9
Phone: (604) 882-6650
Fax: (604) 882-6659
<http://www.bipurewater.ca>

Status

AS BUILT

				Design By: DL
				Drawn By: KD
				Checked By: JK
				Submitted
Issue	Date	Appd	Revision Description	Approved

Clients:

KITNUNA
PROJECTS
INC.

CONTROLS SCHEMATIC

Scale NTS

Date AUG 26, 2011

Sheet 4 of 7



4770

3



Drawing #: 1772-EL-100

Rev: 03

03

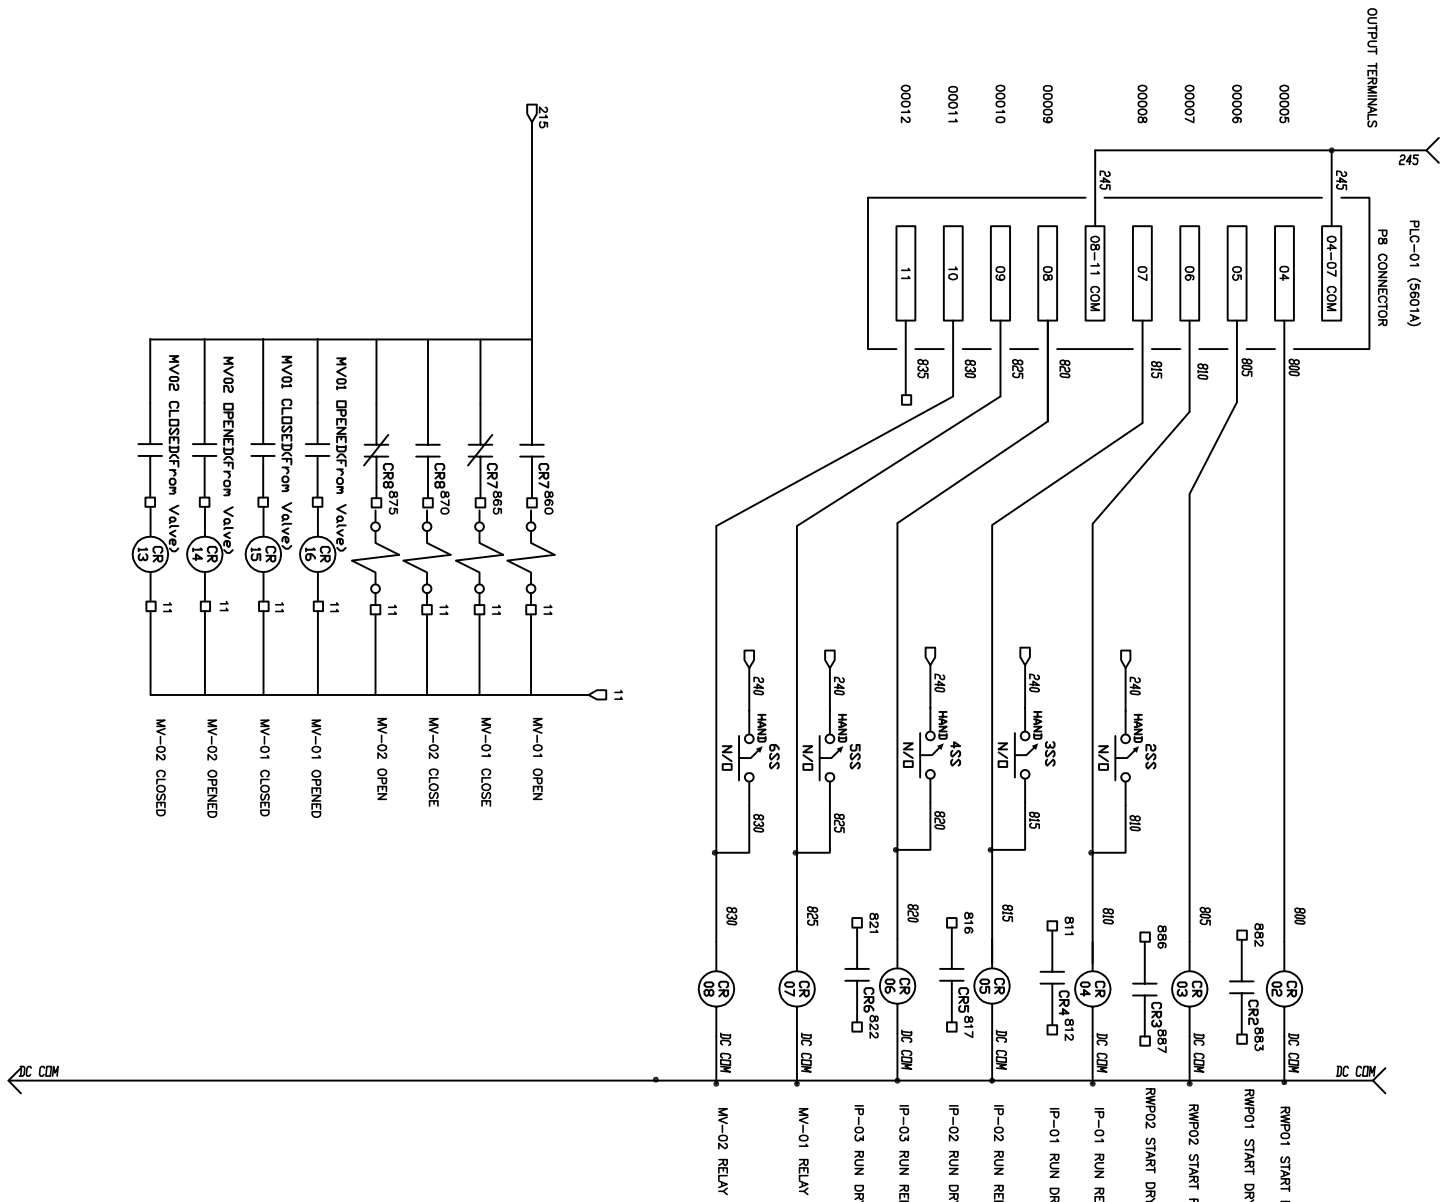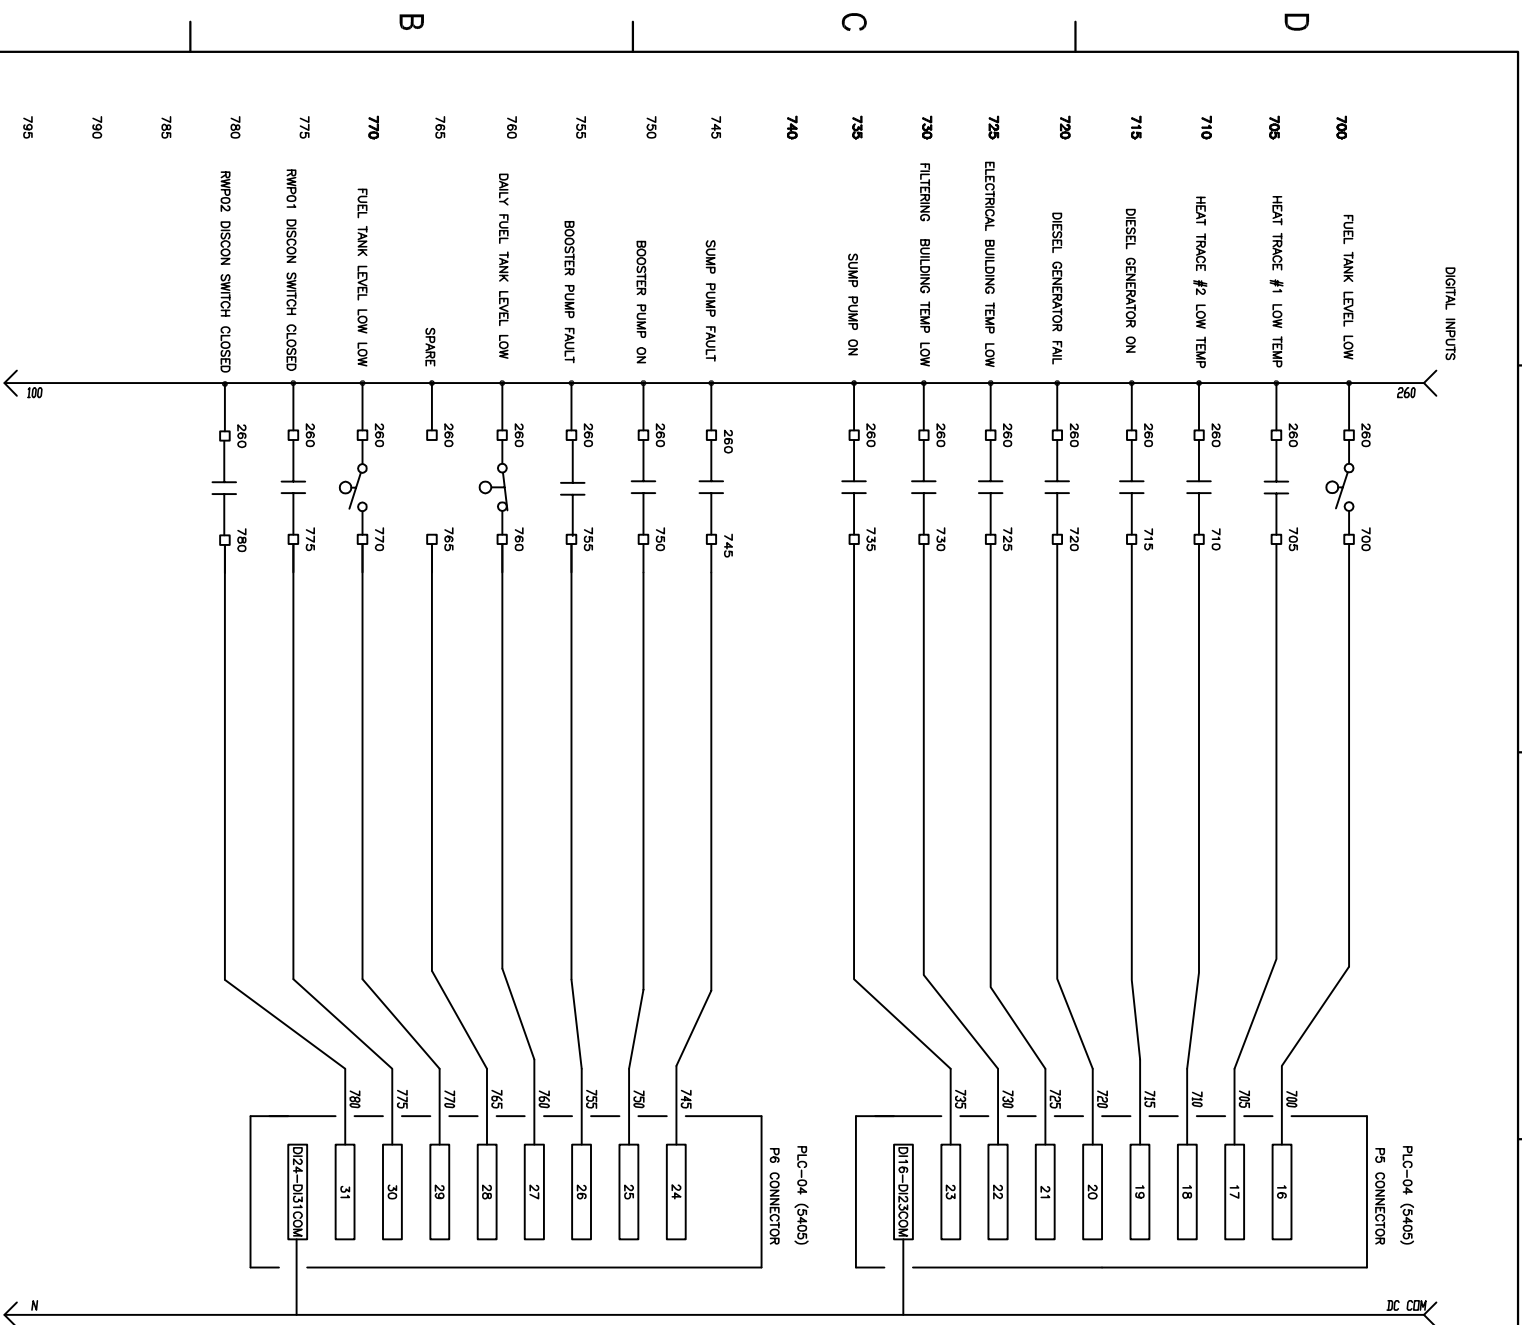

			
BI Pure Water (Canada) Inc.		THE INFORMATION CONTAINED IN THIS DRAWING IS THE SOLE PROPERTY OF BI PURE WATER (CANADA) INC. ANY REPRODUCTION IN PART OR WHOLE OF THE INFORMATION HEREIN, WITHOUT THE WRITTEN PERMISSION OF BI PUREWATER (CANADA) INC., IS STRICTLY PROHIBITED.	
Status			
AS BUILT			
Issue			
Date			
Appt			
Revision Description			
		Design By: DL	
		Drawn By: KD	
		Checked By:	
		Submitted	
		Approved	
		Client:	
KITTUNA PROJECTS INC.		Title: CONTROLS SCHEMATIC	
Project: POTABLE WATER TREATMENT PLANT TALOYOAK		Scale: NTS	
Drawing #: 1772-EL-100		Date: JULY 5, 2010	
		Sheet 5 of 7	
		Job# 1772	
		Rev: 02	

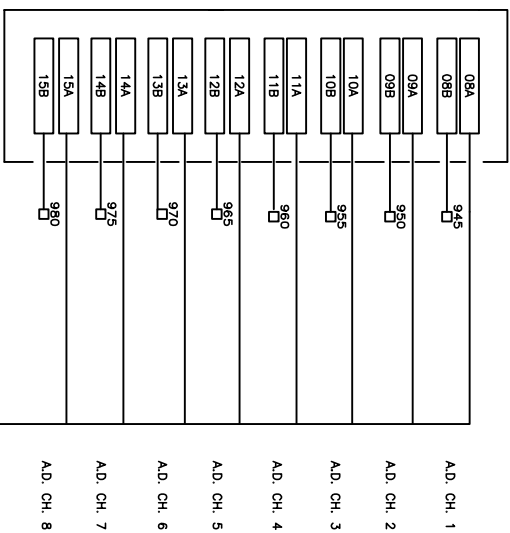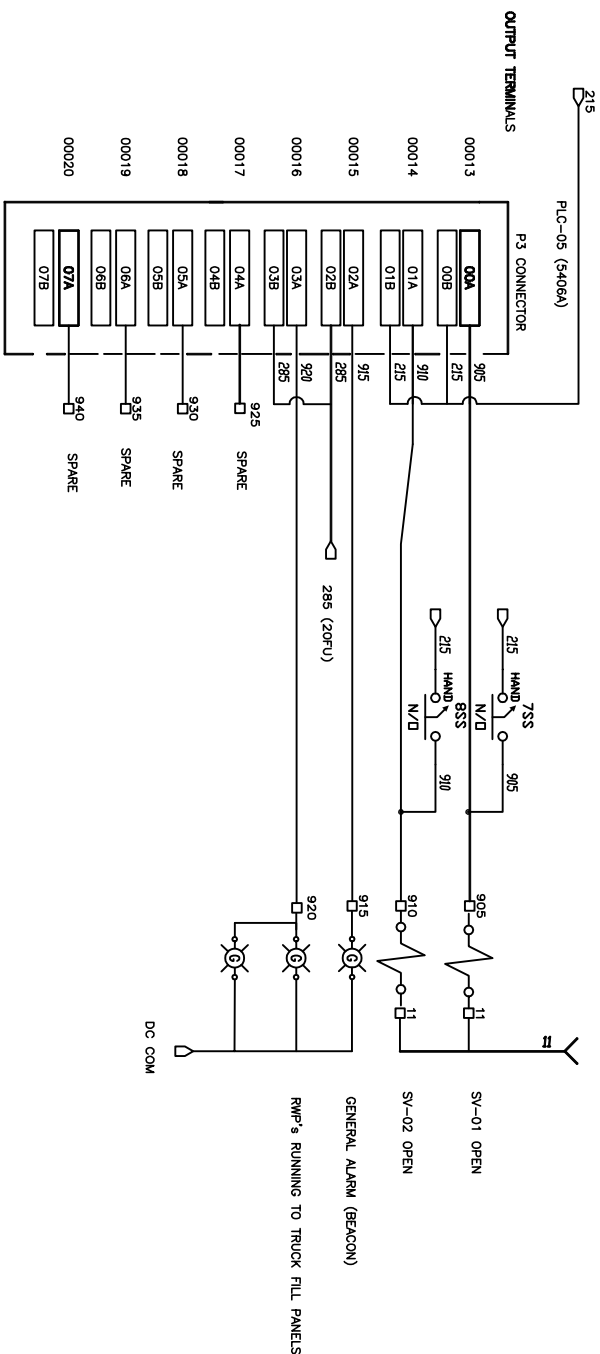

PLC-01 OUTPUT TERMINALS	P2 CONNECTOR	
940		1040
945	00021	1045
	08A	A.D. CH. 1
	08B	
	945	
950	00022	1050
	09A	A.D. CH. 2
	09B	
	950	
	09B	
955	00023	1055
	10A	A.D. CH. 3
	10B	
	955	
	10B	
960	00024	1060
	11A	A.D. CH. 4
	11B	
	960	
	11B	
965	00025	1065
	12A	A.D. CH. 5
	12B	
	965	
	12B	
970	00026	1070
	13A	A.D. CH. 6
	13B	
	970	
	13B	
975	00027	1075
	14A	A.D. CH. 7
	14B	
	975	
	14B	
	00028	1080
	15A	A.D. CH. 8
	15B	
	980	
	15B	
980		1085
985		1090
990		1095
995		1100

		BI Pure Water (Canada) Inc.		THE INFORMATION CONTAINED IN THIS DRAWING IS THE SOLE PROPERTY OF BI PURE WATER (CANADA) INC. ANY REPRODUCTION IN PART OR WHOLE OF THE INFORMATION HEREIN, WITHOUT THE WRITTEN PERMISSION OF BI PURE WATER (CANADA) INC., IS STRICTLY PROHIBITED.		Status	
AS BUILT							
		Issue		Date		Appld	
				Revision Description			
		Design By:		DL			
		Drawn By:		KD			
		Checked By:		JK			
		Submitted					
		Approved					
		Client:		KITNUNA PROJECTS INC.			
		Title:		CONTROLS SCHEMATIC			
		Scale:		NTS			
		Date		AUG 26, 2011			
		Project:		POTABLE WATER TREATMENT PLANT TALOYOAK			
		Sheet		6 of 7			
		Job#		1772			
		Drawing #:		1772-EL-100		Rev: 03	

