


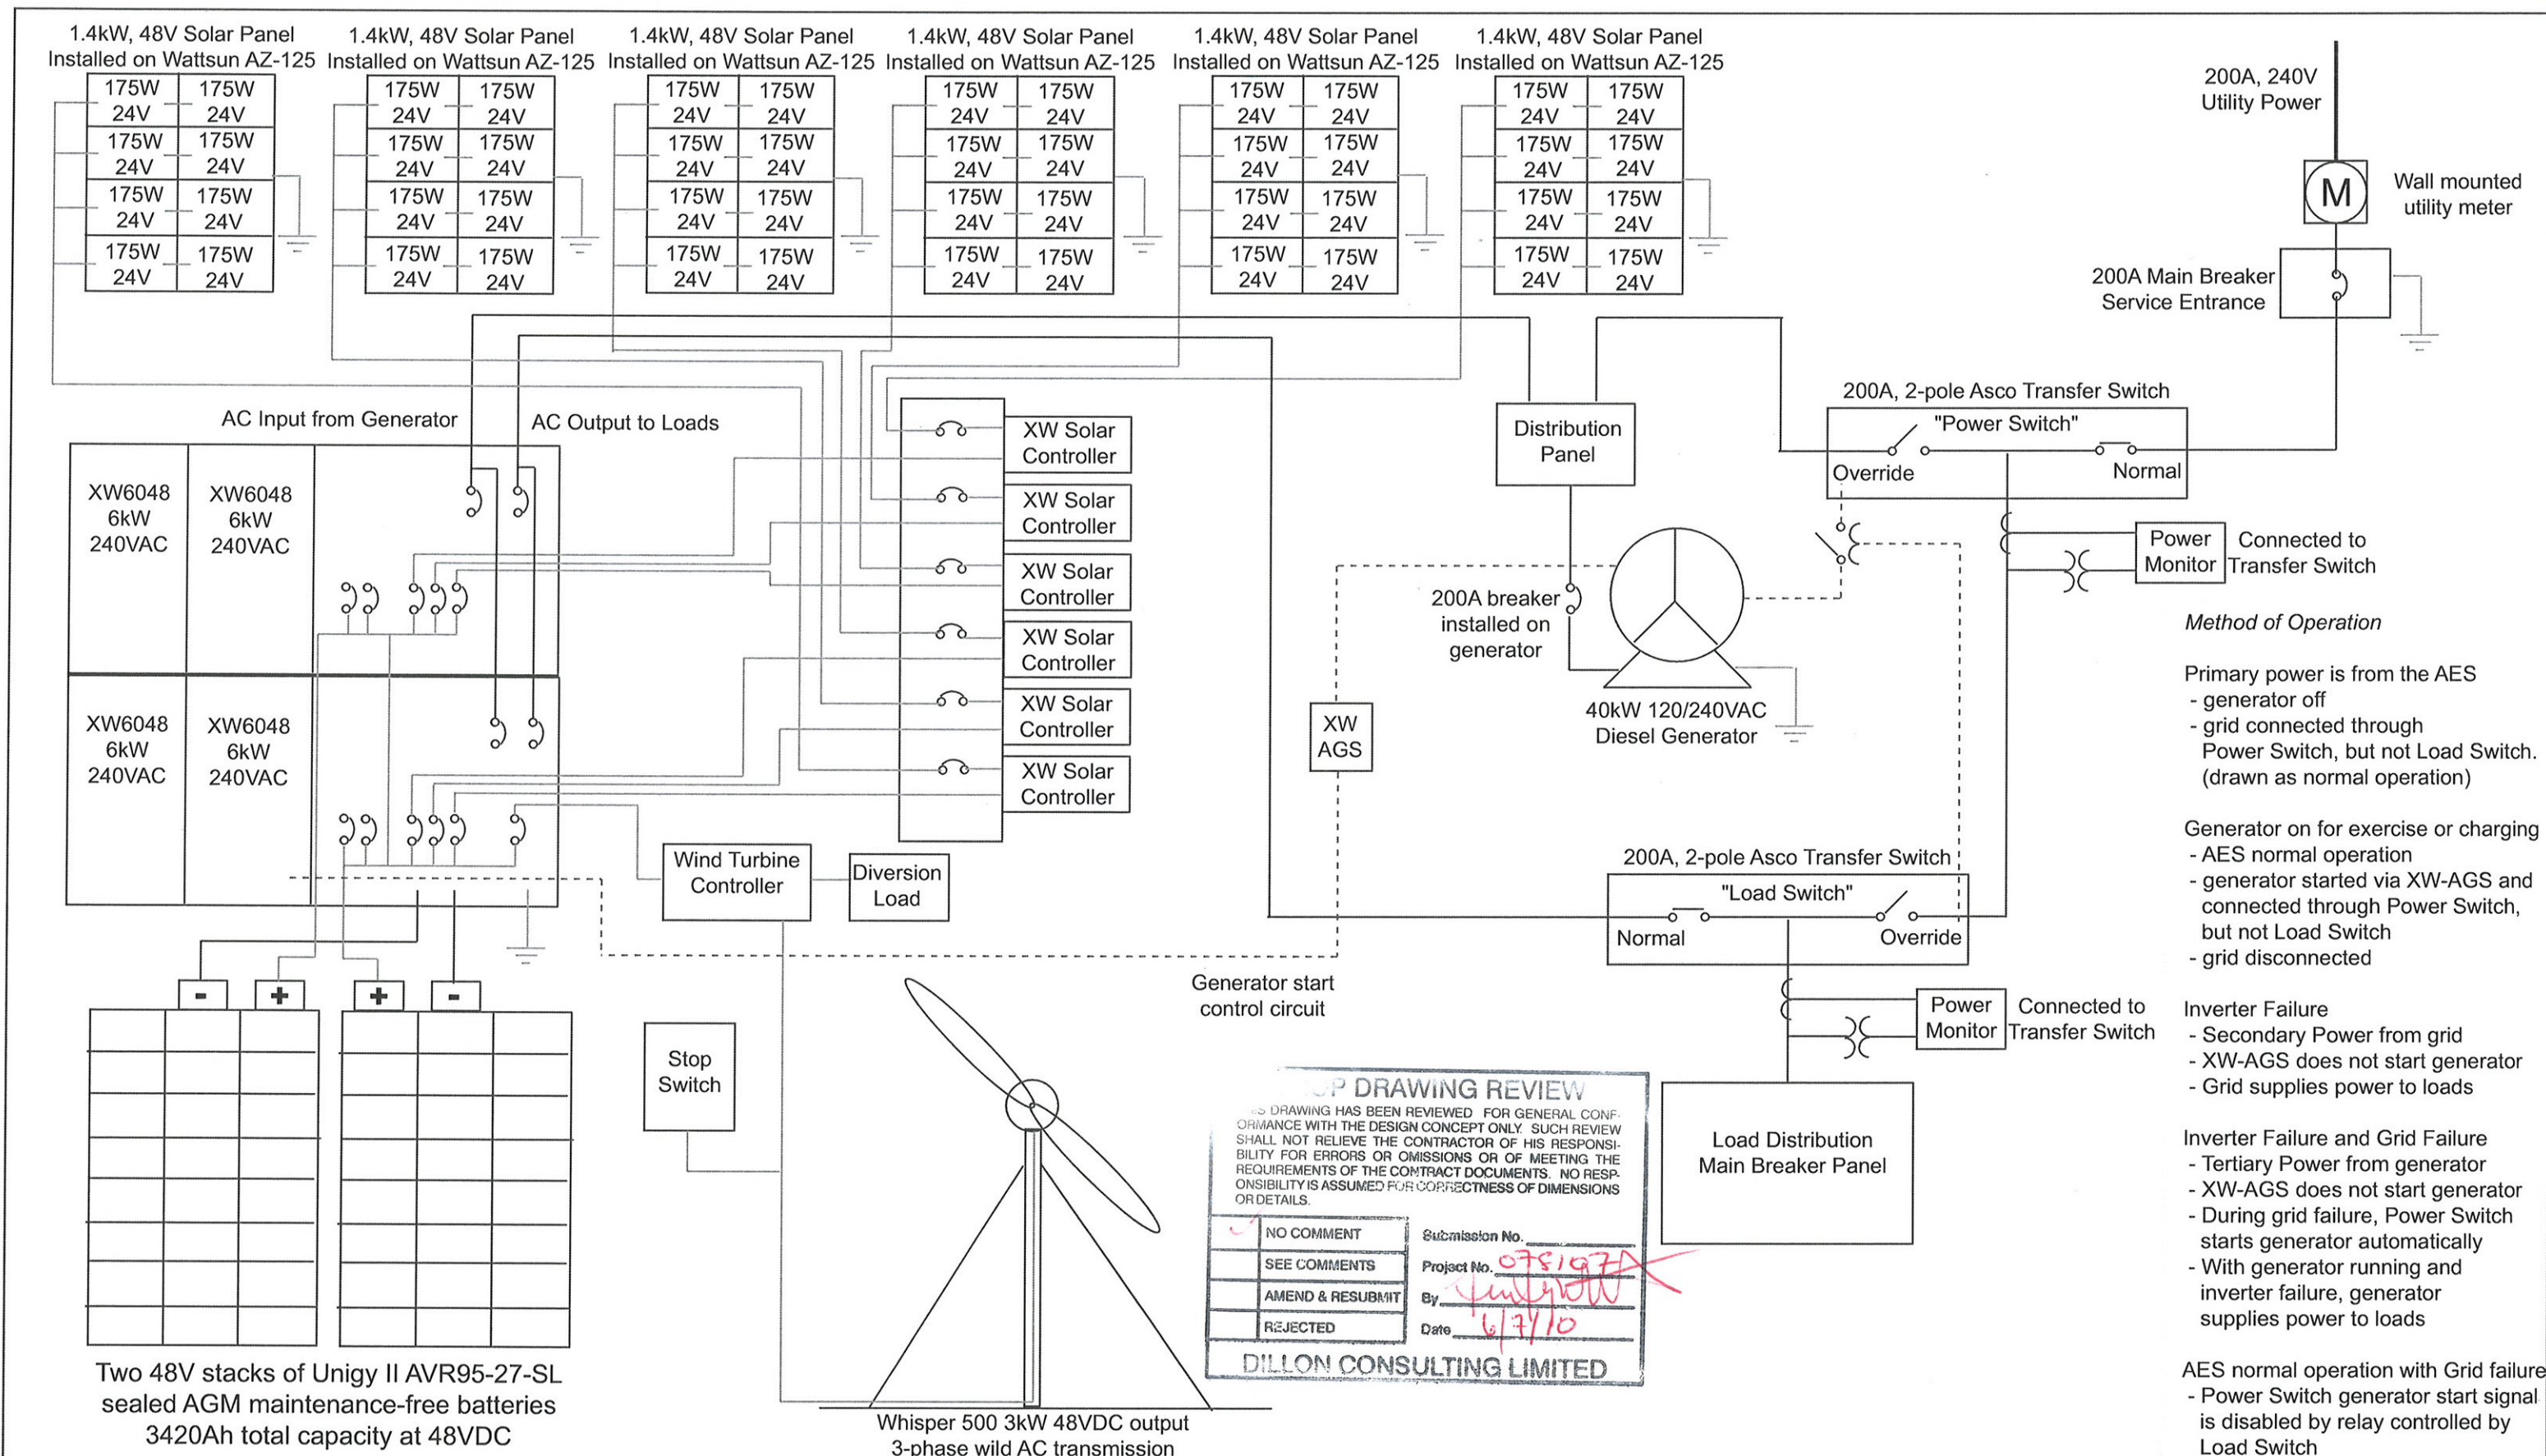

AES Electrical Layout Single Line Diagram
Revision 1



Taloyoak Water Treatment Plant

Drawn by: ☐ Hiltz Tanner
Checked by: Kevin Pegg
Date: ☐ June 4, 2010