


H-C75/2-8400-101

DYE-M

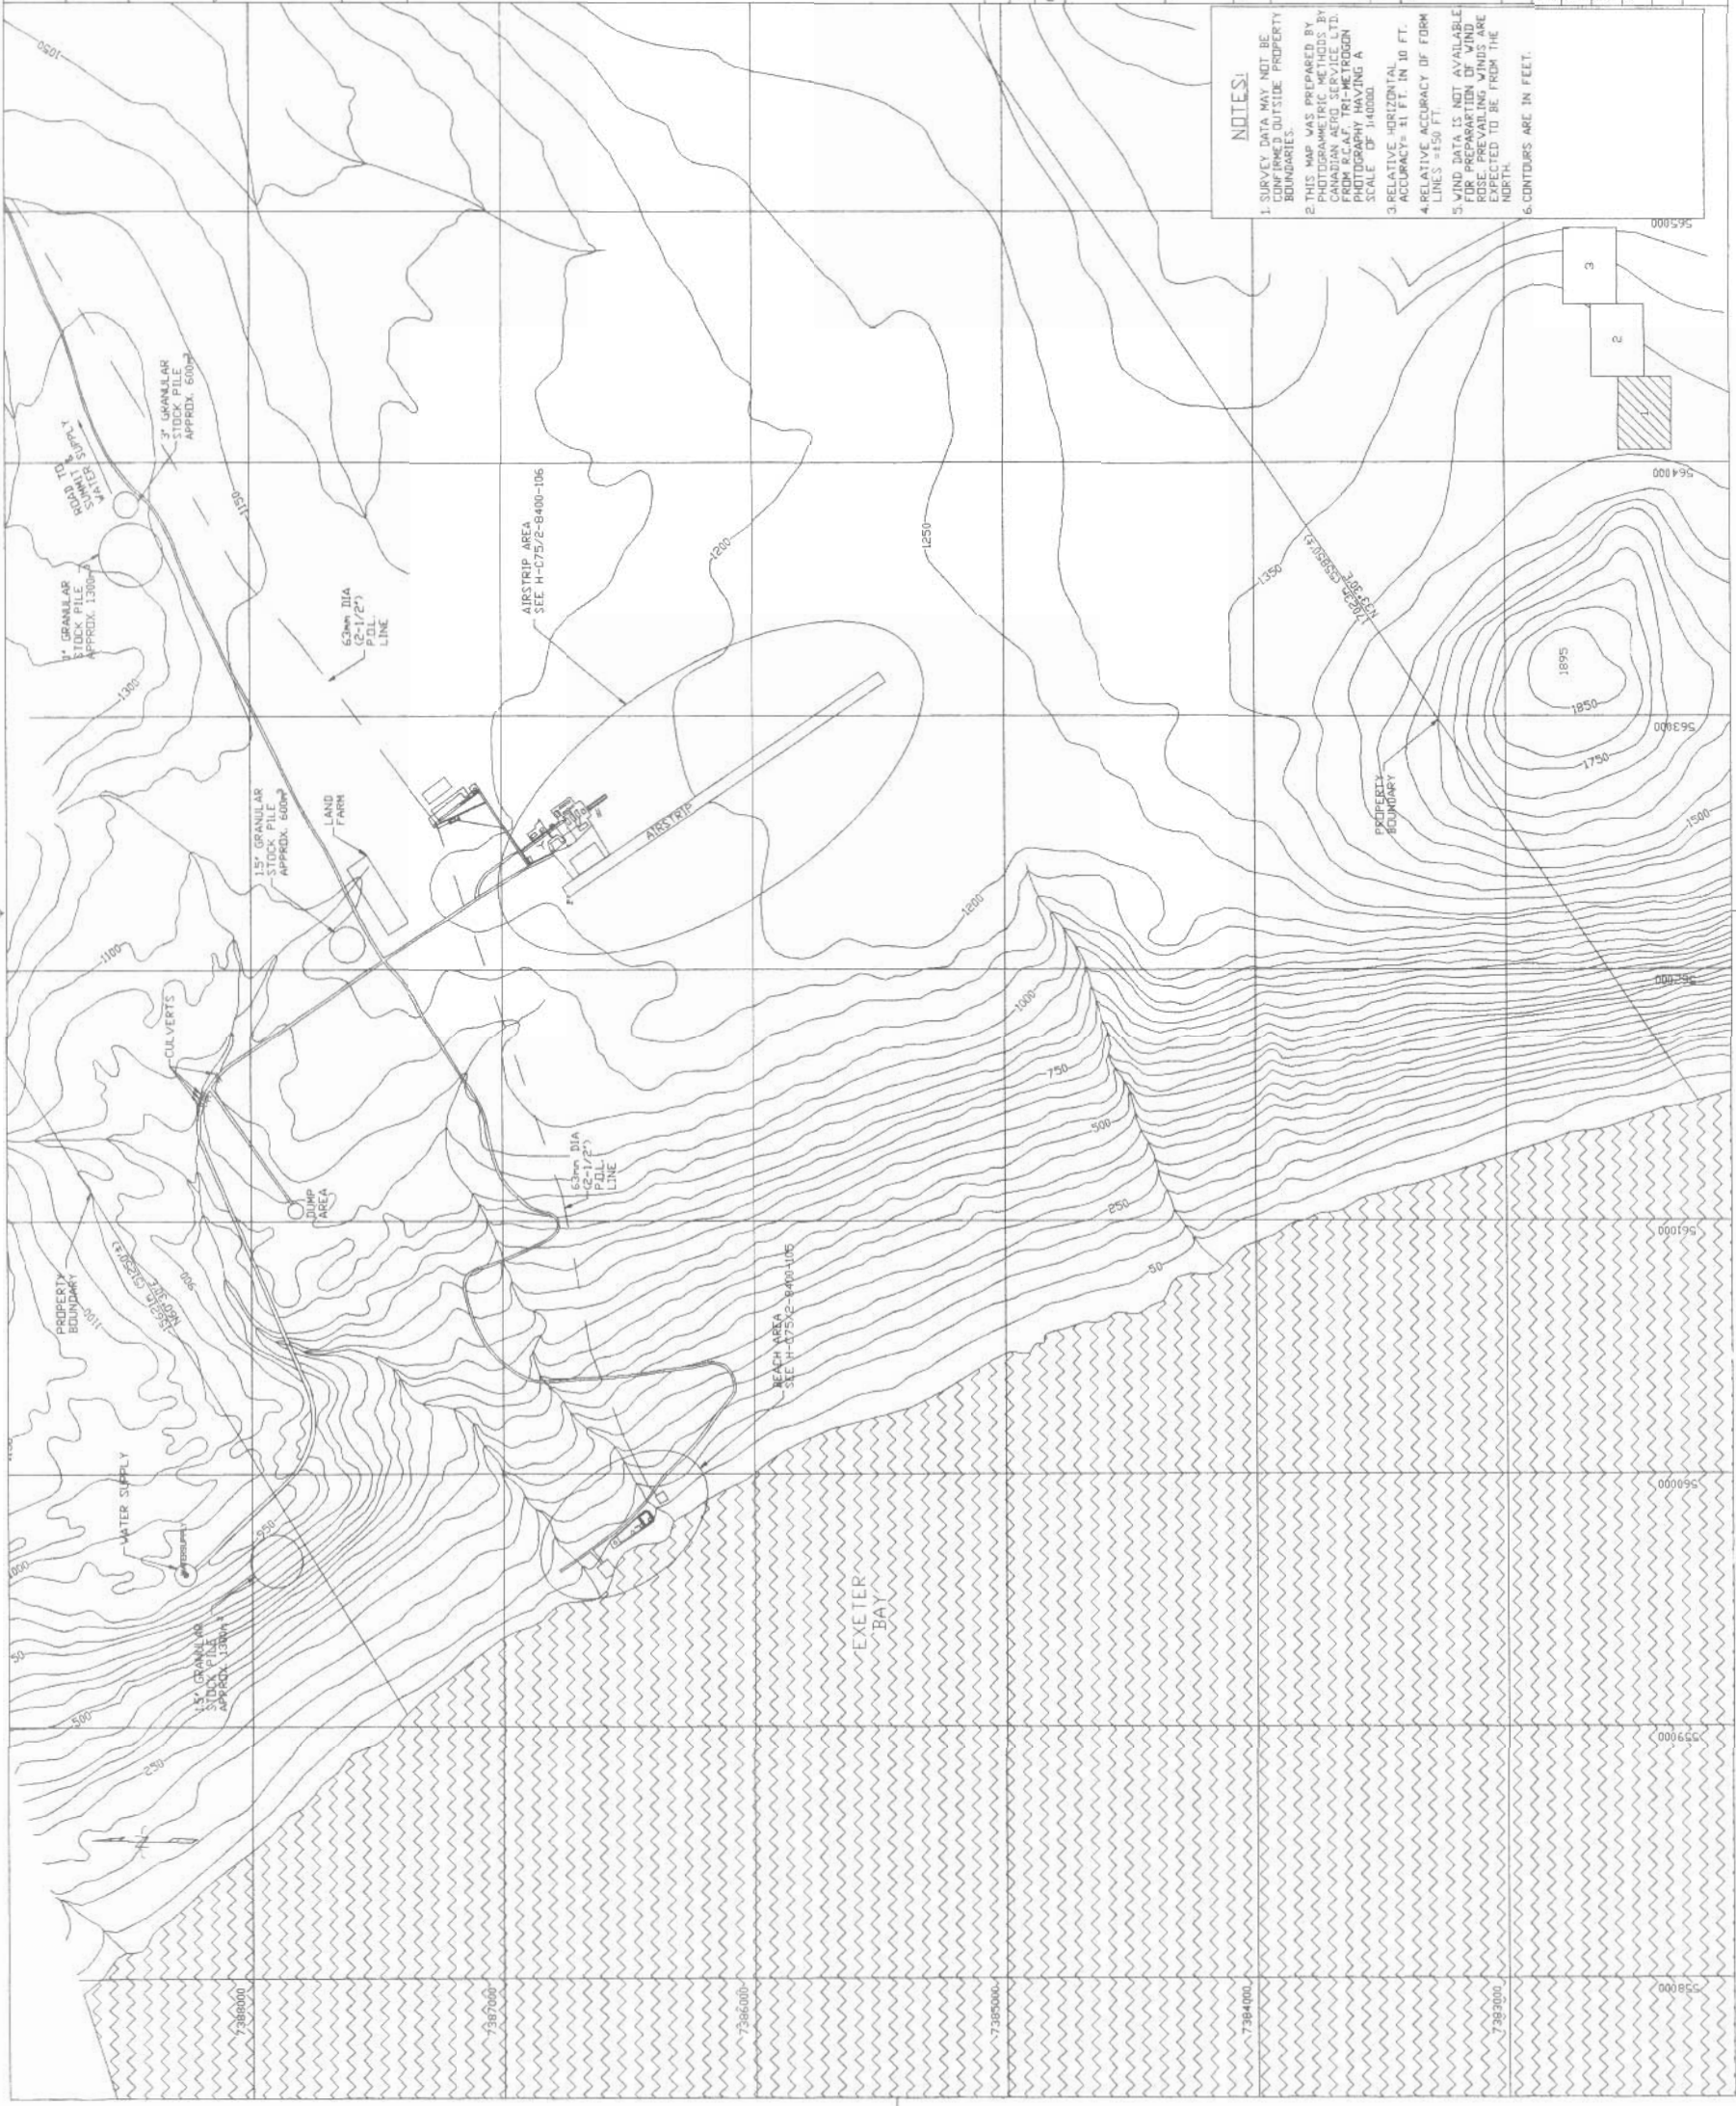

NOTES:
1 SURVEY DATA MAY NOT BE CONFIRMED OUTSIDE PROPERTY BOUNDARIES.
2 THIS MAP WAS PREPARED BY PHOTOGRAPHIC SURVEY BY CANADIAN AERO SERVICE LTD. FROM K&A/T, TRI-METROGEN SCALE OF 1:40000.
3 RELATIVE HORIZONTAL ACCURACY = 31 FT. IN 10 FT. LINES ±150 FT.
4 RELATIVE VERTICAL ACCURACY OF FORM LINES ±150 FT.
5 WIND DATA IS NOT AVAILABLE FOR THIS AREA. PREVALENT WINDS ARE EXPECTED TO BE FROM THE NORTH.
6 CONTOURS ARE IN FEET.

REDUCED DRAWING FOR INFORMATION ONLY
SCALE IS REPRESENTATIVE OF FULL SIZE DRAWING.

NOTES:
LEGEND:
SWAMP
WATER/LAKE

ATCO Frontec
100-170 LAUREN AVE. WEST
SUITE 100
CALGARY, ALBERTA T2C 1A8
TEL: 873 84-4000
FAX: 873 84-4000



LOCATION:
NORTH WARNING SYSTEM OFFICE
Bureau du système d'alerte du Nord



NO.	DATE	REVISION	BY	APP.
1	19 DEC 02	REVISED AS PER NO-20066 K.R.		

SITE RECORD DRAWING

200 0 200 400 600 800 metres
feet

SCALE - ÉCHELLE
1 : 10000

PROJECT - PROJET
CM-66431
LONG RANGE RADAR SITE

DYE-M

CAPE DIER
THICK-METER
SUBJECT-SUBJET

SITING
DATE
03 APR 02

SITE PLAN

CONCURRENCE - ASSEMENT

DESIGNED	BY	DATE	BY	DATE
ETUDE	K.R.			
DESIGN				
VERIFICATION				
COORDINATION				


OFFICER DU GÉNIE
INSTRUMENTATION
INSTALLATION
DYE-M
H-C75/2-8400-101

Canada

H-C75/2-8400-103

DYE-M

NOTES:
1. SURVEY DATA MAY NOT BE CONFIRMED OUTSIDE PROPERTY BOUNDARIES.
2. CONTOURS ARE IN FEET.
3. THIS MAP WAS PREPARED BY PHOTOGRAMMETRIC METHODS BY CHARTERED SURVEYORS LTD. (CHARTERED SURVEYORS) PHOTOGRAPHY HAVING A SCALE OF 1:40,000.
4. RELATIVE HORIZONTAL ACCURACY = ±1 FT. IN 100 FT.
5. RELATIVE VERTICAL ACCURACY OF FORM LINES = ±50 FT.
6. WIND DATA IS NOT AVAILABLE FOR PREPARATION OF WIND ROSE. PREVAILING WINDS ARE EXPECTED TO BE FROM THE NORTH.

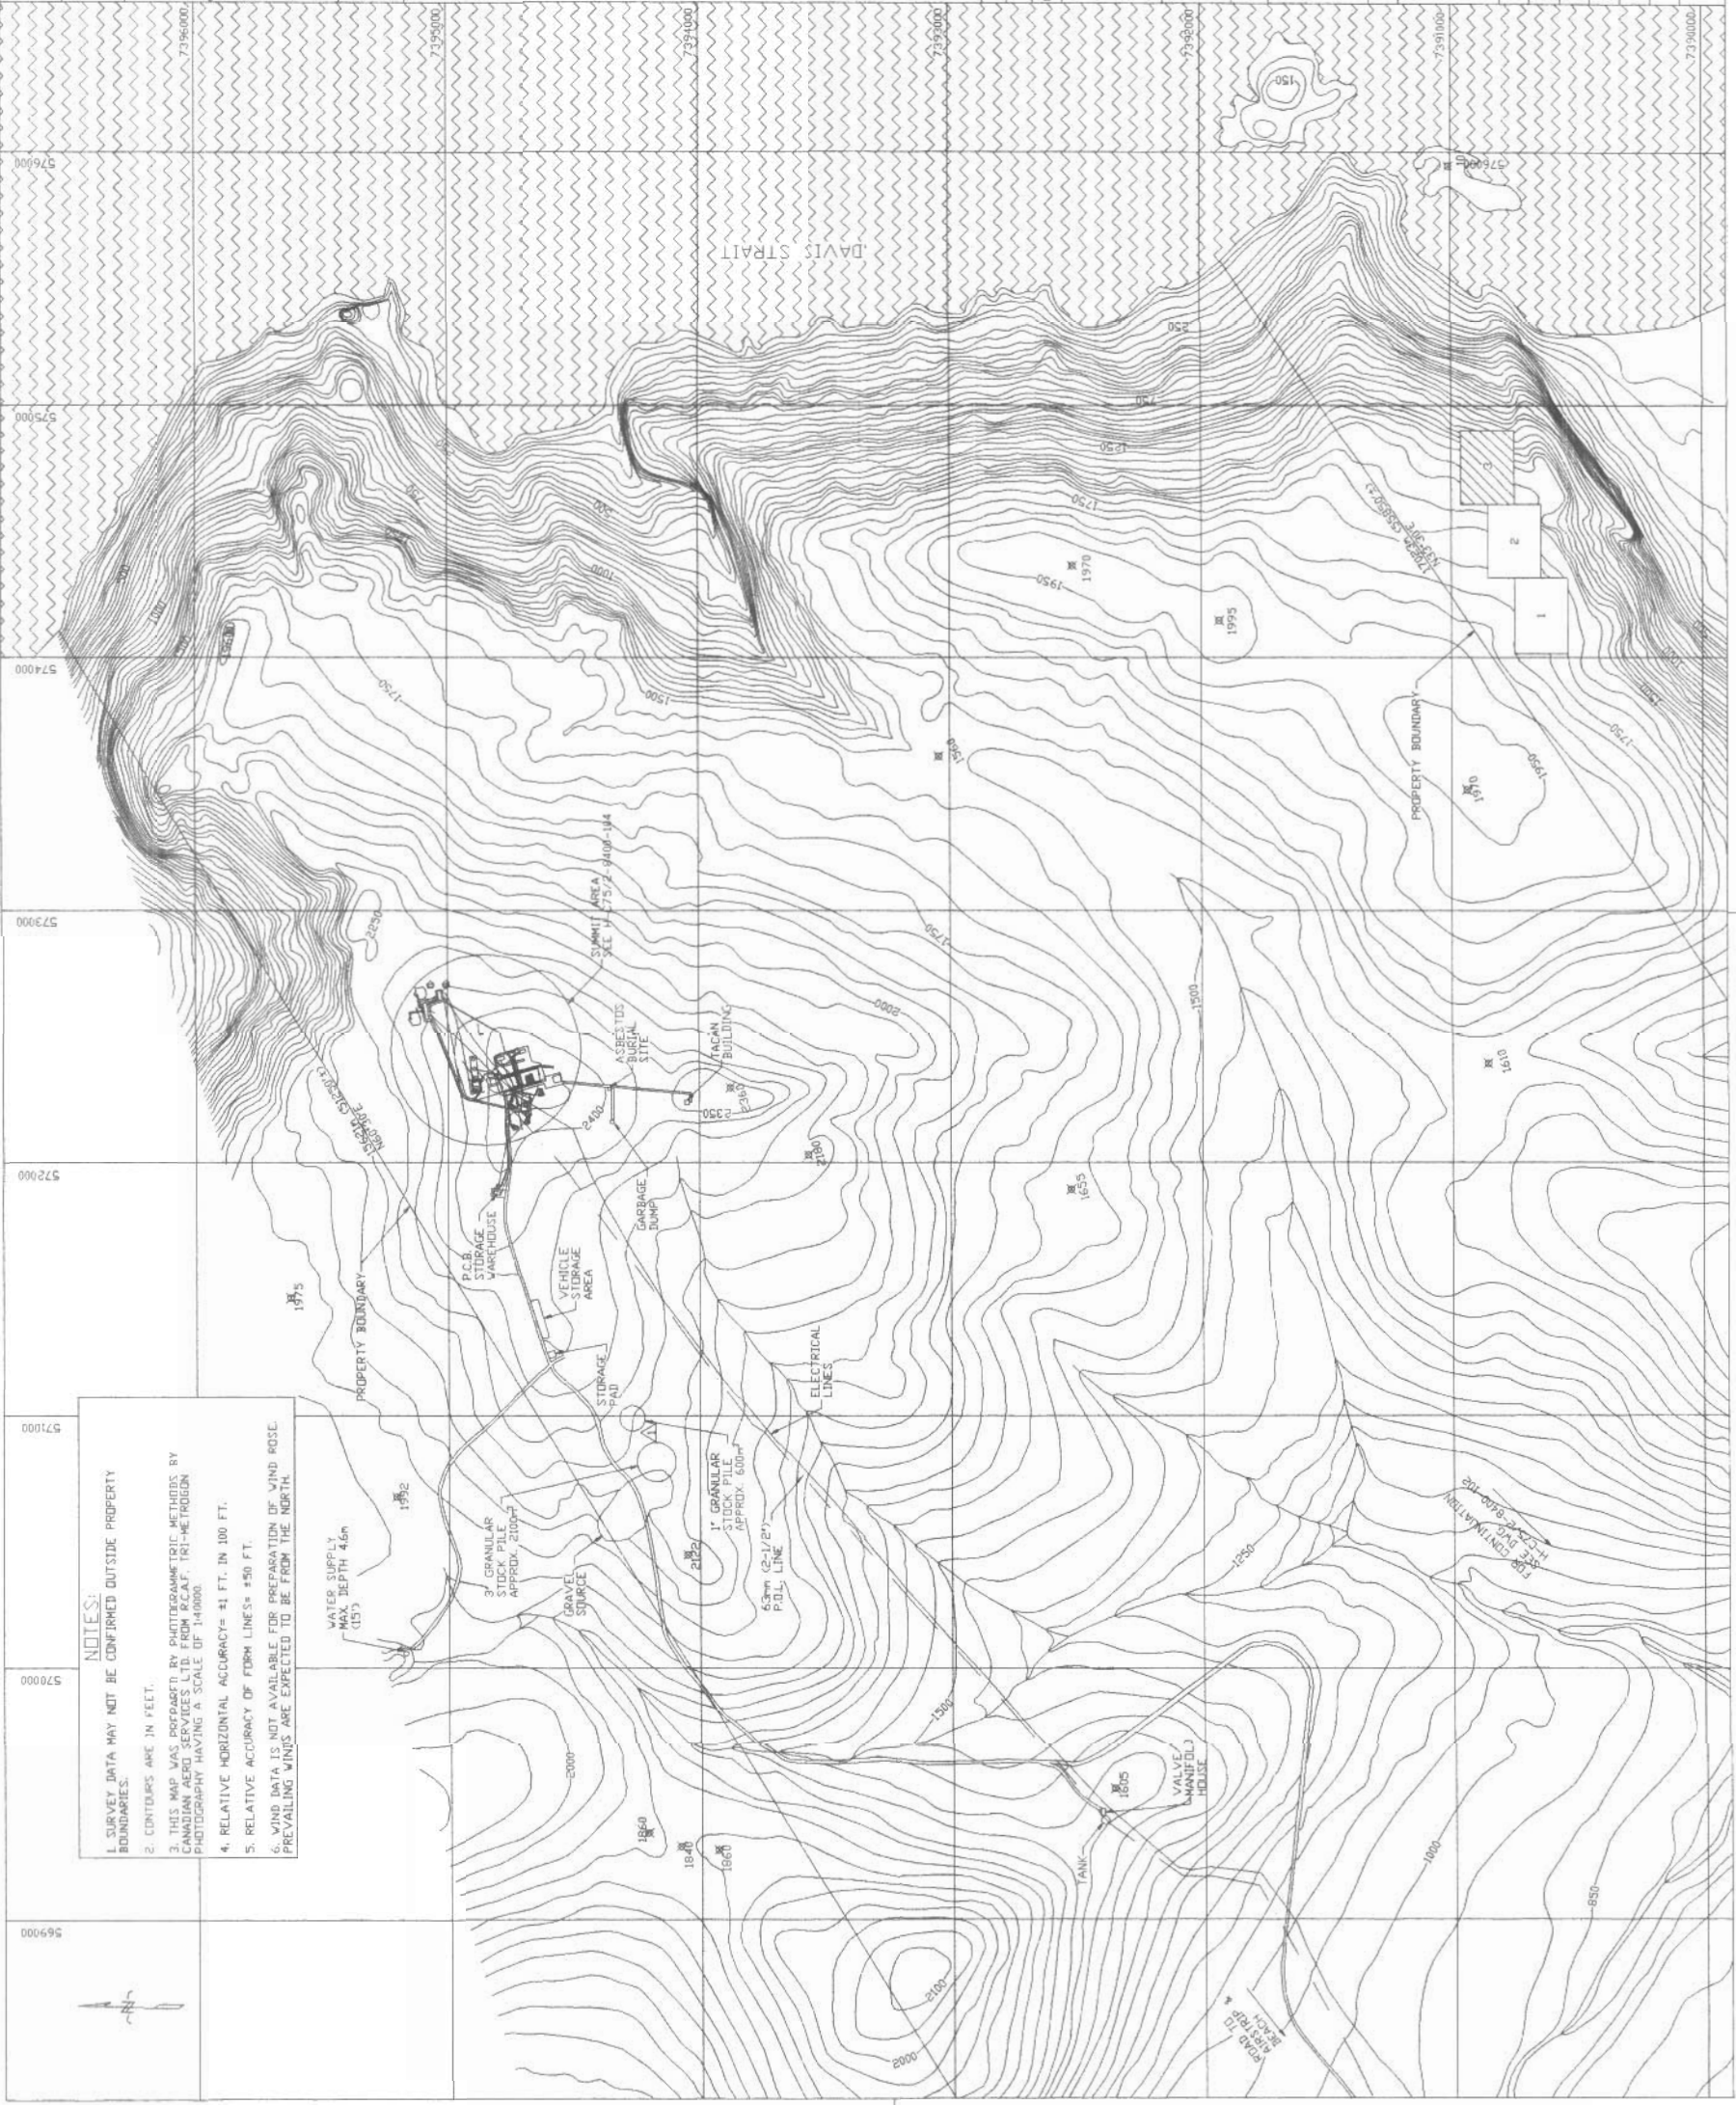



National
Défense

Defence
nationale

NORTH WARNING SYSTEM OFFICE
Bureau du système d'alerte du Nord

LOCATION



ATCO Frontec
100-100 LAURENCE AVE. WEST
SCARBOROUGH, ONTARIO M1H 1B7
TEL: (416) 291-1000
FAX: (416) 291-1001

LEGEND:

	SWAMP
	WATER/LAKE

REDUCED DRAWING FOR
INFORMATION ONLY
SCALE IS REPRESENTATIVE
OF FULL SIZE DRAWING.

No.	DATE	REVISION	BY	APP.
1	19 DEC 02	REVISED AS PER NO-20066 K-R		



SCALE - ECHELLE
1 : 10000

PROJECT - PROJET
CM-66431
LONG RANGE RADAR SITE

DYE-M

CAPE DYER
TRACE-METER
SITING
DATE
02 APR 02


SUBJECT - SUJET
SITE PLAN

PRODUCTION	CONTRIBUTOR	ASSIGNMENT
DESIGNED BY K.R.	FIRE HAWTHAL	DESIGN OF SITE PLAN
DRAWN BY K.R.	FIRE HAWTHAL	DRAWING OF SITE PLAN
CHECKED BY K.R.	FIRE HAWTHAL	CHECKING OF SITE PLAN
APPROVED BY K.R.	FIRE HAWTHAL	APPROVAL OF SITE PLAN
DATE 02 APR 02	FIRE HAWTHAL	DATE OF SITE PLAN

H-C75/2-8400-103
Canada

H-C75/2-8400-102

DYE-M

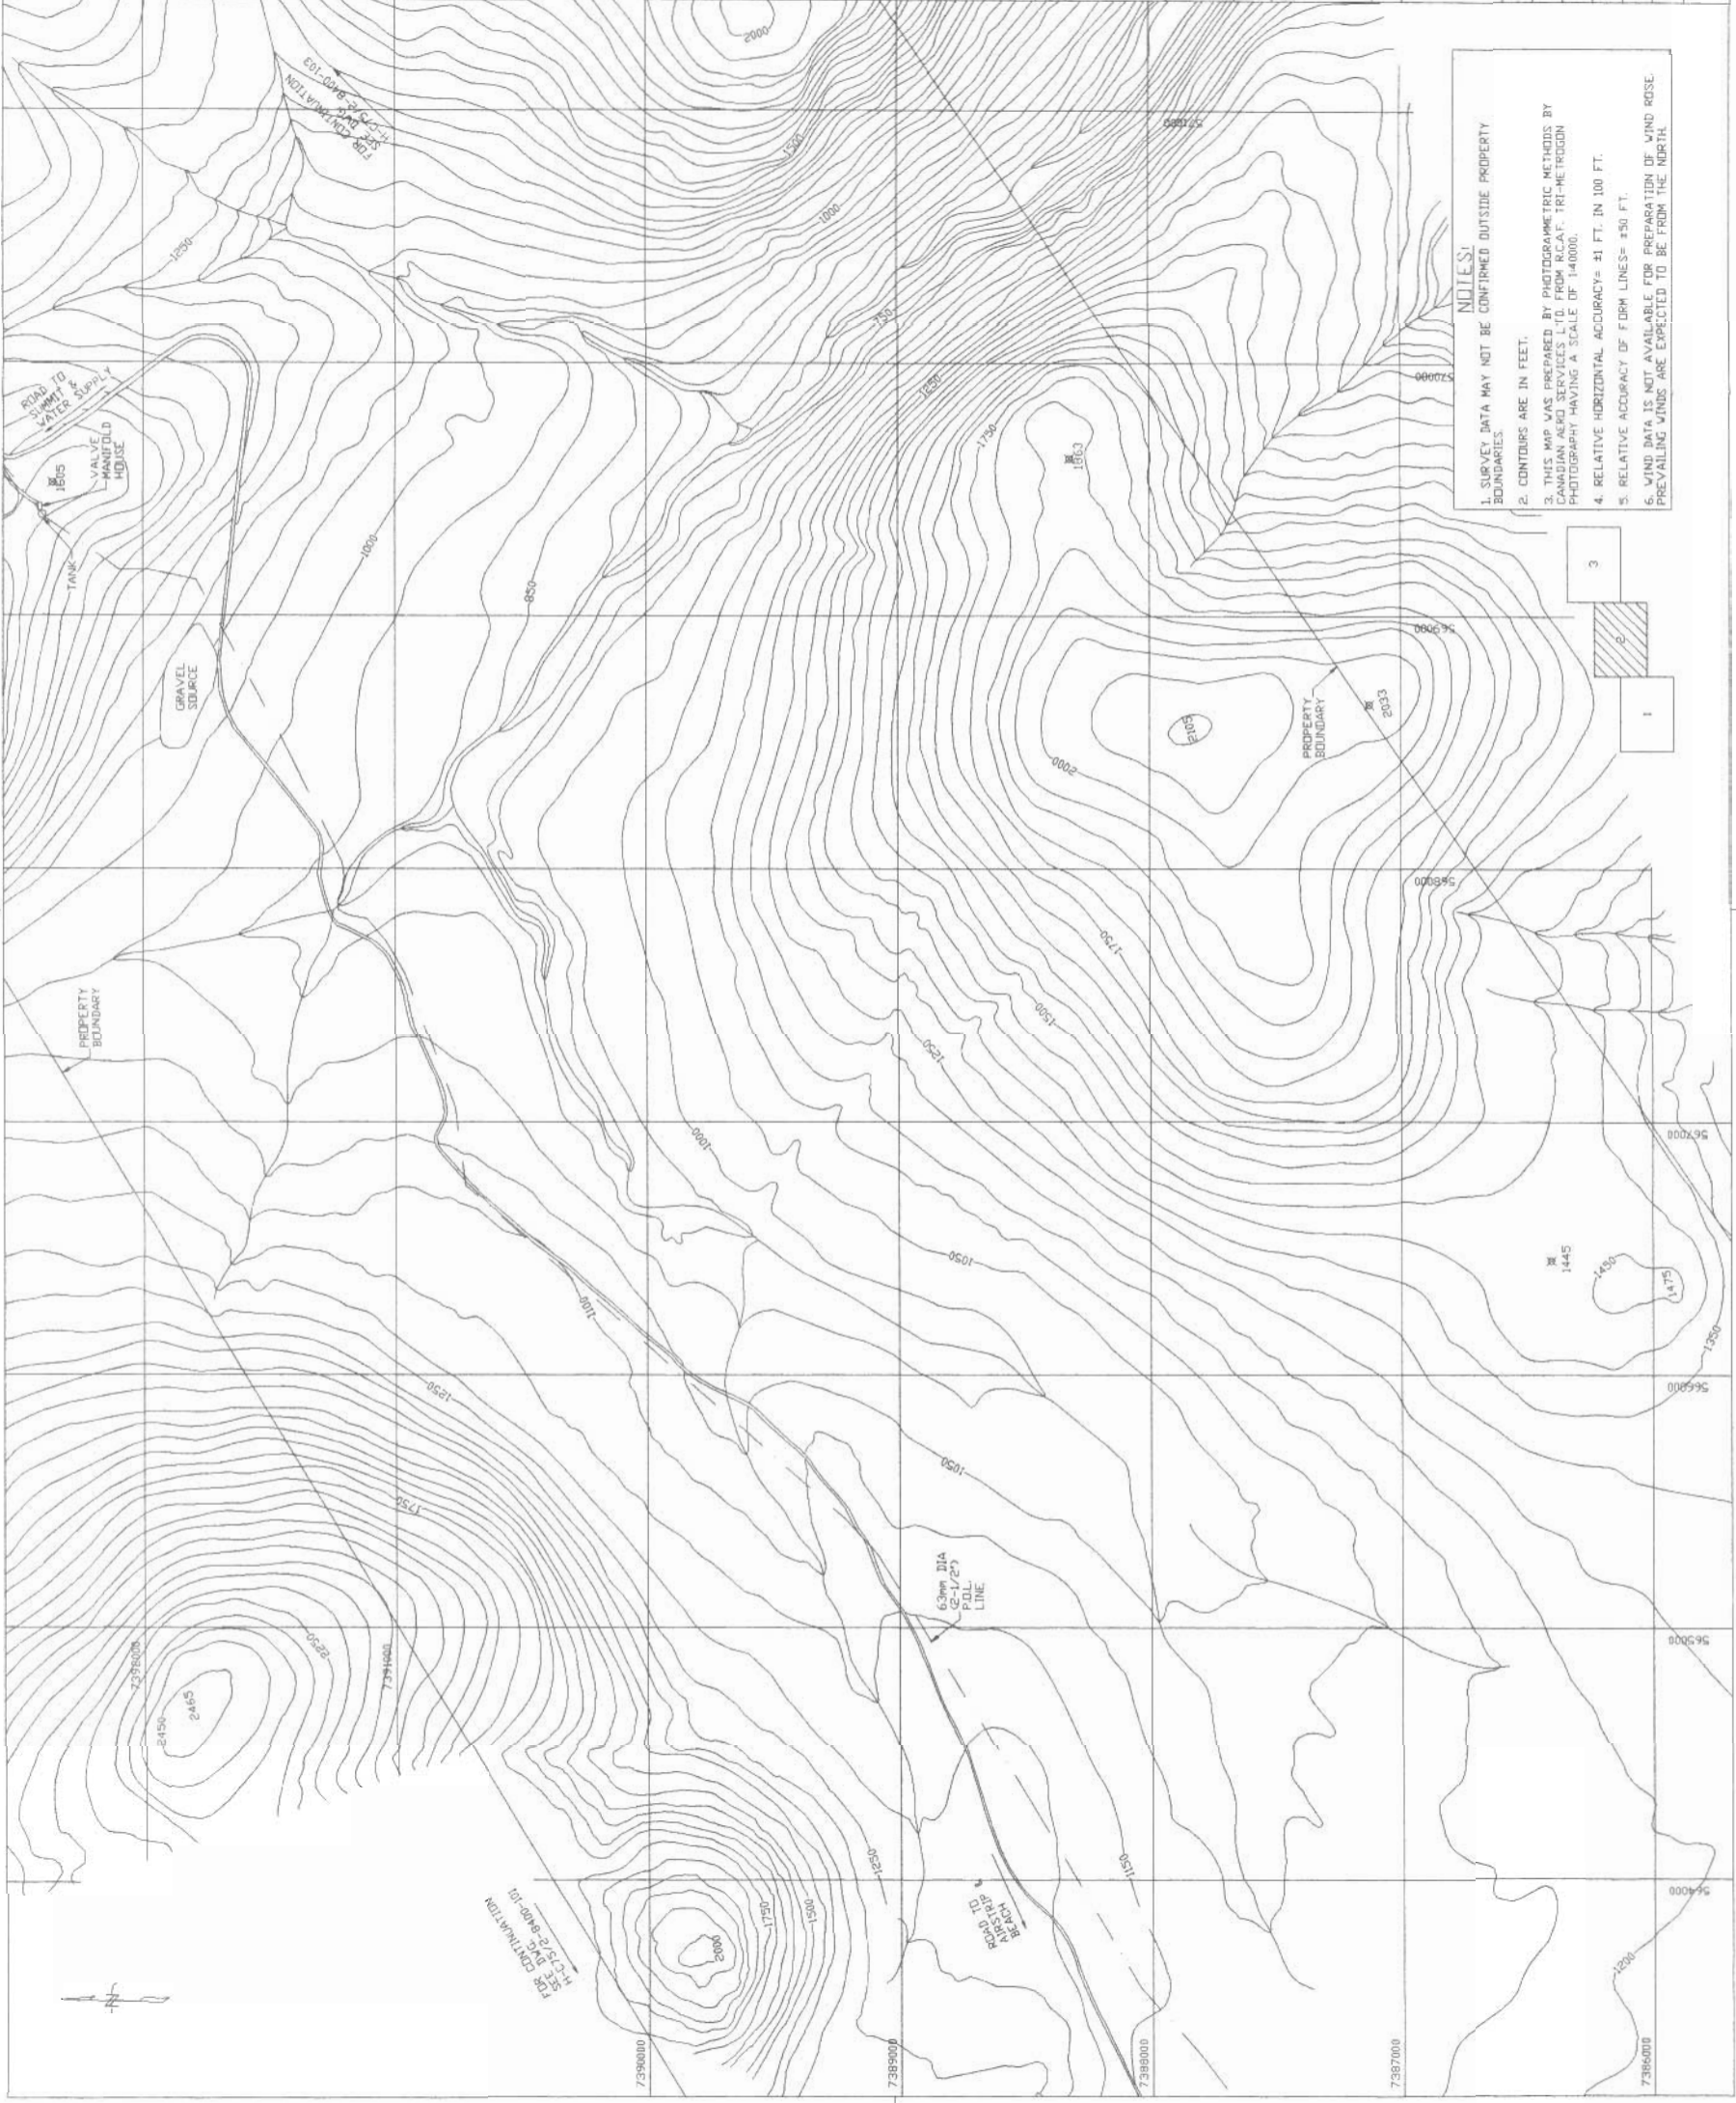

NOTES:
1. SURVEY DATA MAY NOT BE CONFIRMED OUTSIDE PROPERTY BOUNDARIES.
2. CONTOURS ARE IN FEET.
3. THIS MAP WAS PREPARED BY PHOTOGRAMMETRIC METHODS BY CANADIAN AERO SERVICES LTD. FROM R.C.A.F. TRI-METRODON PHOTOGRAPHY HAVING A SCALE OF 1:40000.
4. RELATIVE HORIZONTAL ACCURACY= 41 FT. IN 100 FT.
5. RELATIVE VERTICAL ACCURACY= 41 FT. IN 100 FT.
6. WIND DATA IS NOT AVAILABLE FOR PREPARATION OF WIND ROSE. PREVAILING WINDS ARE EXPECTED TO BE FROM THE NORTH.

National
Défense
Défense
nationale

NORTH WARNING SYSTEM OFFICE
Bureau du système d'alerte du Nord

LOCATION

DYE-M

100-175 LAURENCE AVE. WEST
SCARBOROUGH, ONTARIO M1P 5B6
TEL: (416) 291-2000
FAX: (416) 291-2000

ATCO Frontec

LEGEND:

SWAMP

WATER/LAKE

REDUCED DRAWING FOR
INFORMATION ONLY
SCALE IS REPRESENTATIVE
OF FULL SIZE DRAWING.

NO.	DATE	REVISION	BY	APPV.

SITE RECORD DRAWING

SCALE - ÉCHELLE
1 : 10000

PROJECT - PROJET
CM-66431

LONG RANGE RADAR SITE
DYE-M

CAPE DIER
TRAIL - MÉTIER
SITING
SUBJECT - SUJET

NUNAVUT
DATE
03 APR 02

PRODUCTION	CONCURRENCE - ASSÉNTIMENT
DESIGNED ETUDE	FIRE MARSHAL
DRAWN Dessin	K.R.
CHECKED VÉRIFIÉ	K.R.
COORDINATION	ENGINEERING INGÉNIEURIE
	INSTALLATION
	GENIE DE INSTALLATION

H-C75/2-8400-102

Canada

