


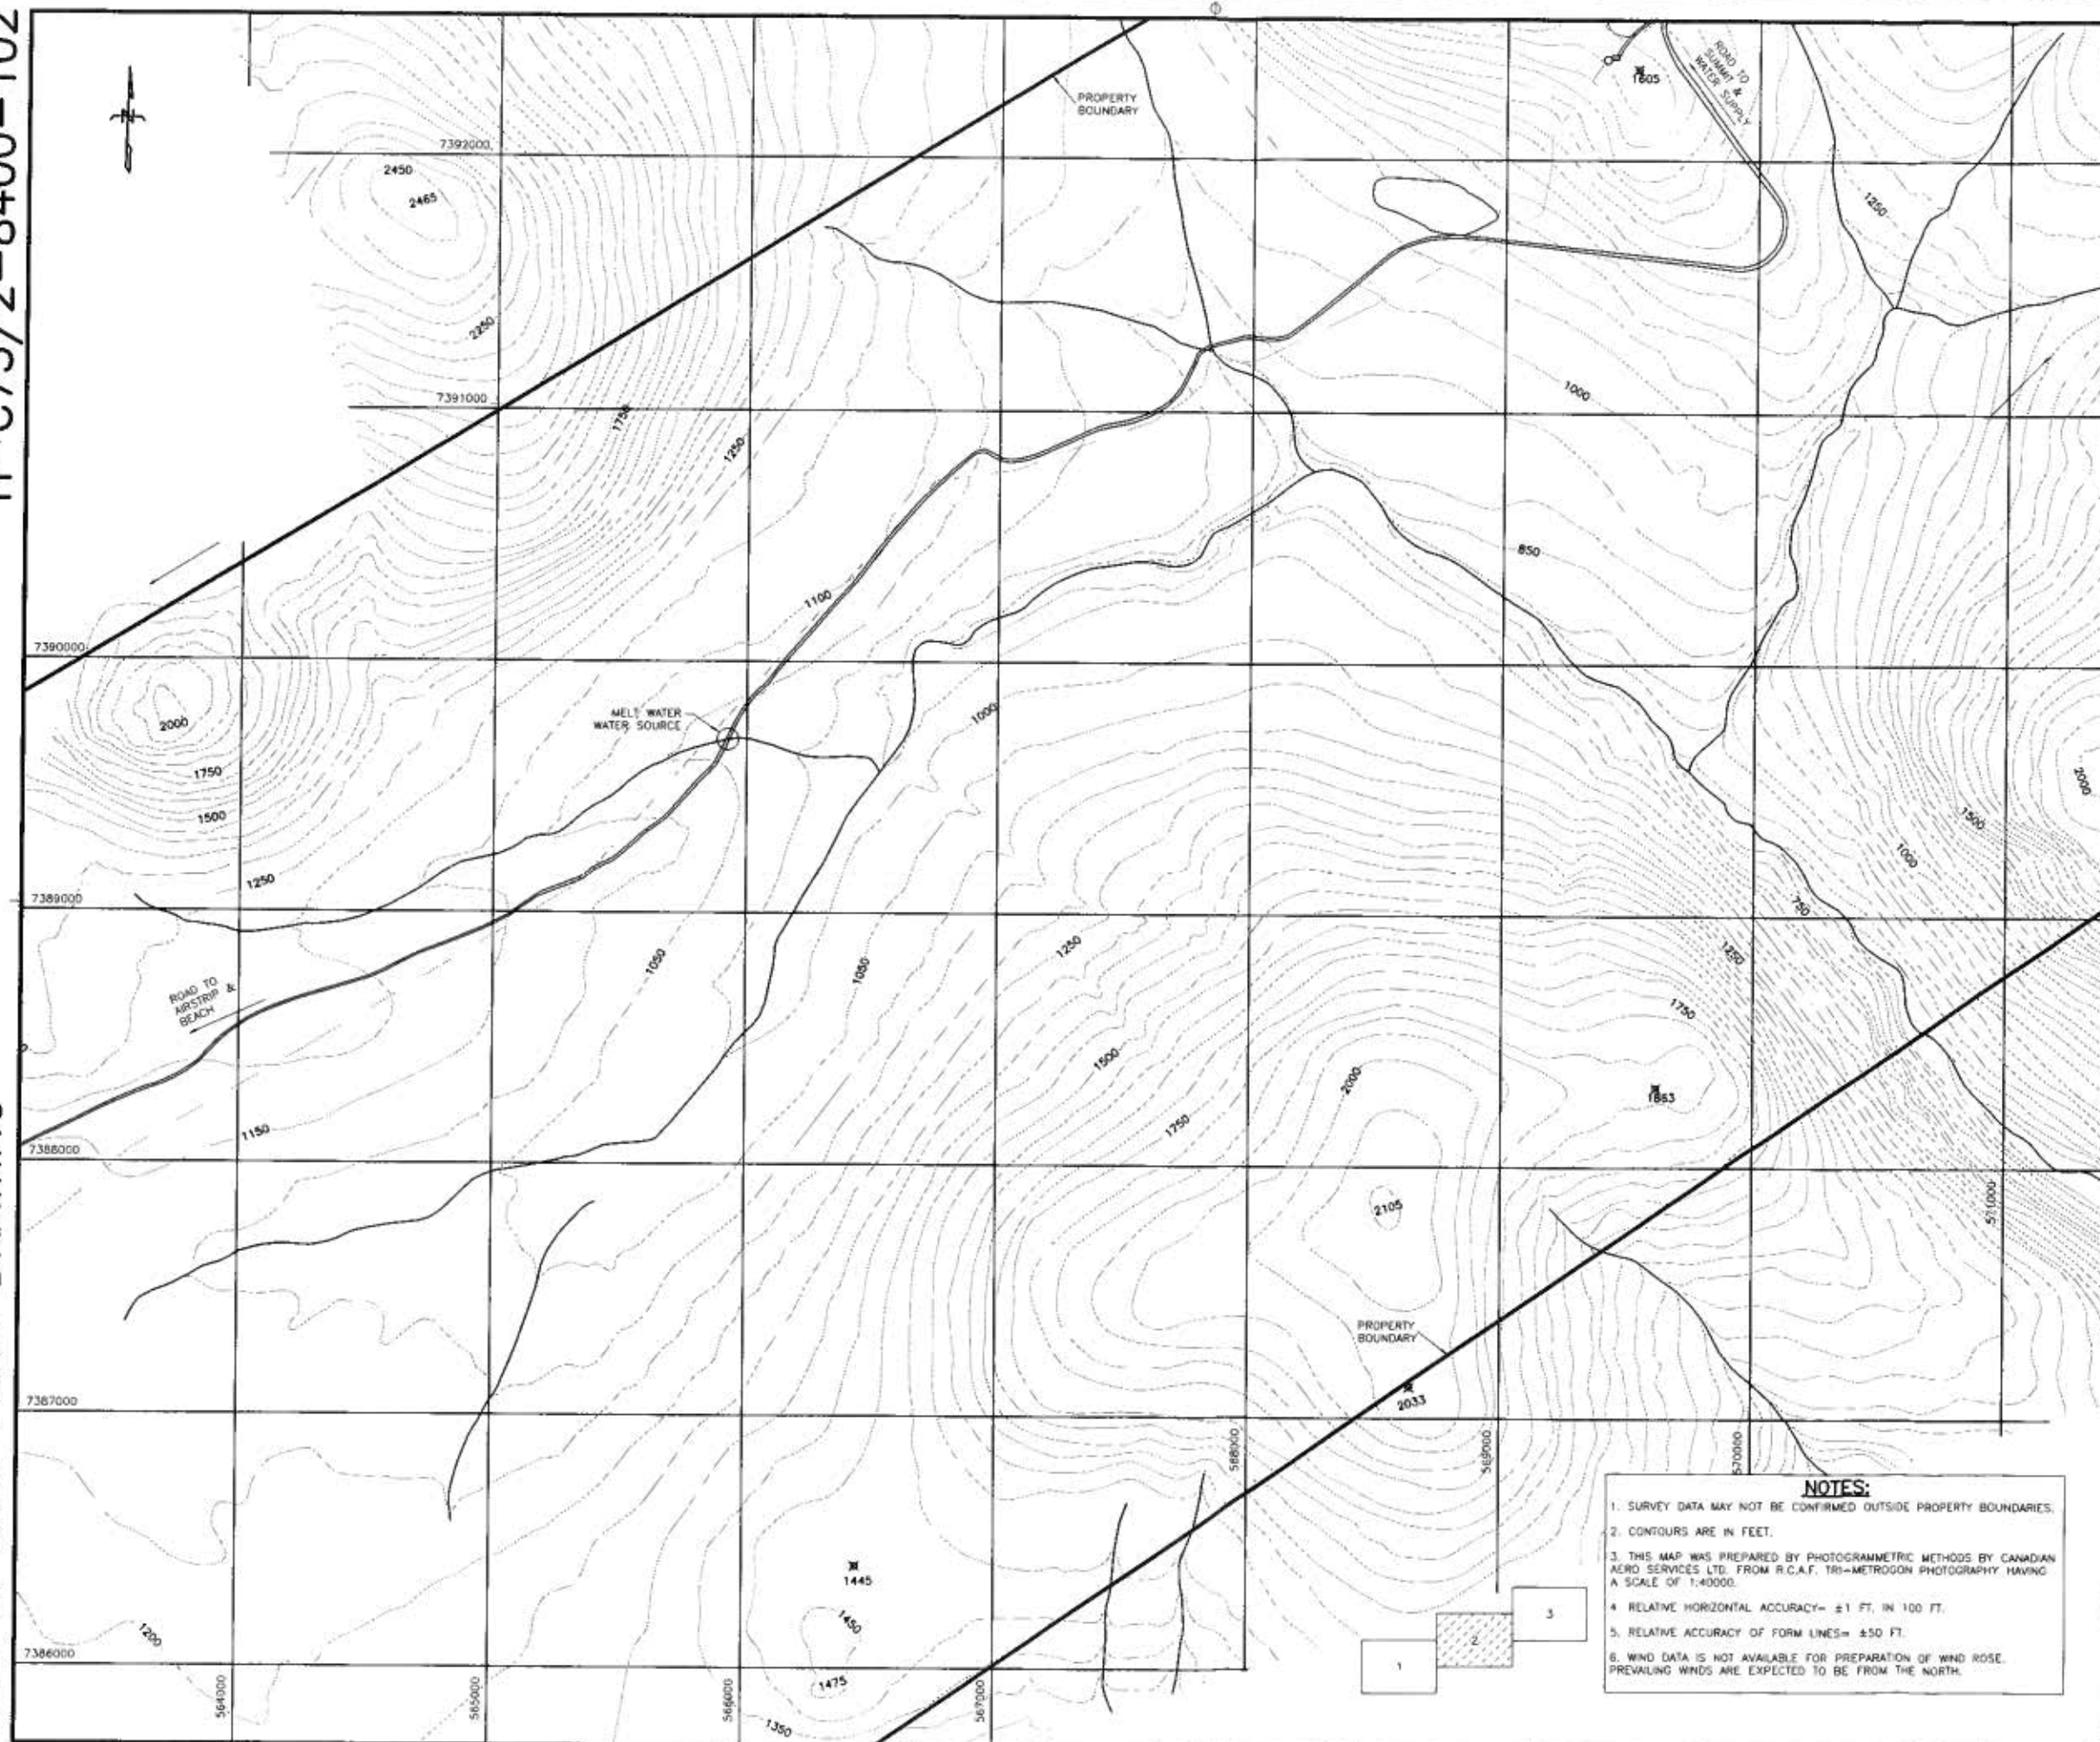

		National Défense		Défense nationale											
NORTH WARNING SYSTEM OFFICE Bureau du système d'alerte du Nord															
LOCATION															
															
															
100-110 LAURIER AVE. WEST OTTAWA, ONTARIO K1P 1W5 TEL: (613) 234-9833 FAX: (613) 234-7888															
NOTES: 1. NASITTUQ HAS CARE CUSTODY OF ENTIRE PARCEL.															
LEGEND:															
 SWAMP															
 WATER/LAKE															
REDUCED DRAWING FOR INFORMATION ONLY SCALE IS REPRESENTATIVE OF FULL SIZE DRAWING.															
<table border="1"><thead><tr><th>No.</th><th>DATE</th><th>REVISION</th><th>REVISION</th><th>OWN. APPR.</th></tr></thead><tbody><tr><td>1</td><td>13 JUN 06</td><td>REV AS PER REDUNES</td><td></td><td>F.P.</td></tr></tbody></table>						No.	DATE	REVISION	REVISION	OWN. APPR.	1	13 JUN 06	REV AS PER REDUNES		F.P.
No.	DATE	REVISION	REVISION	OWN. APPR.											
1	13 JUN 06	REV AS PER REDUNES		F.P.											
SITE RECORD DRAWING															
															
SCALE - ÉCHELLE 1 : 10000															
PROJECT - PROJET CM-66431															
LONG RANGE RADAR SITE															
DYE-M															
CAPE DYER															
TRADE - MÉTIER SITING															
NUNAVUT															
DATE 03 APR 02															
SUBJECT - SUJET															
SITE PLAN															
PRODUCTION															
CONCURRENCE - ASSESSMENT															
DESIGNED ÉTUDE															
DRAWN Dessin															
CHECKED VÉRIFIE															
COORDINATION															
FIRE MARSHAL															
PREVOT DU SERVICE DES INCENDIES															
K.R.															
T.R.															
ANNO ENGINEERING SERVICE															
ANNO FACILITIES ENGINEER															
OFFICER DU GÉNÉRAL															
GÉNÉRAL DES INSTALLATIONS															
OWN. NO. - DESIGN NO. H-C75/2-8400-102															
Canada															