


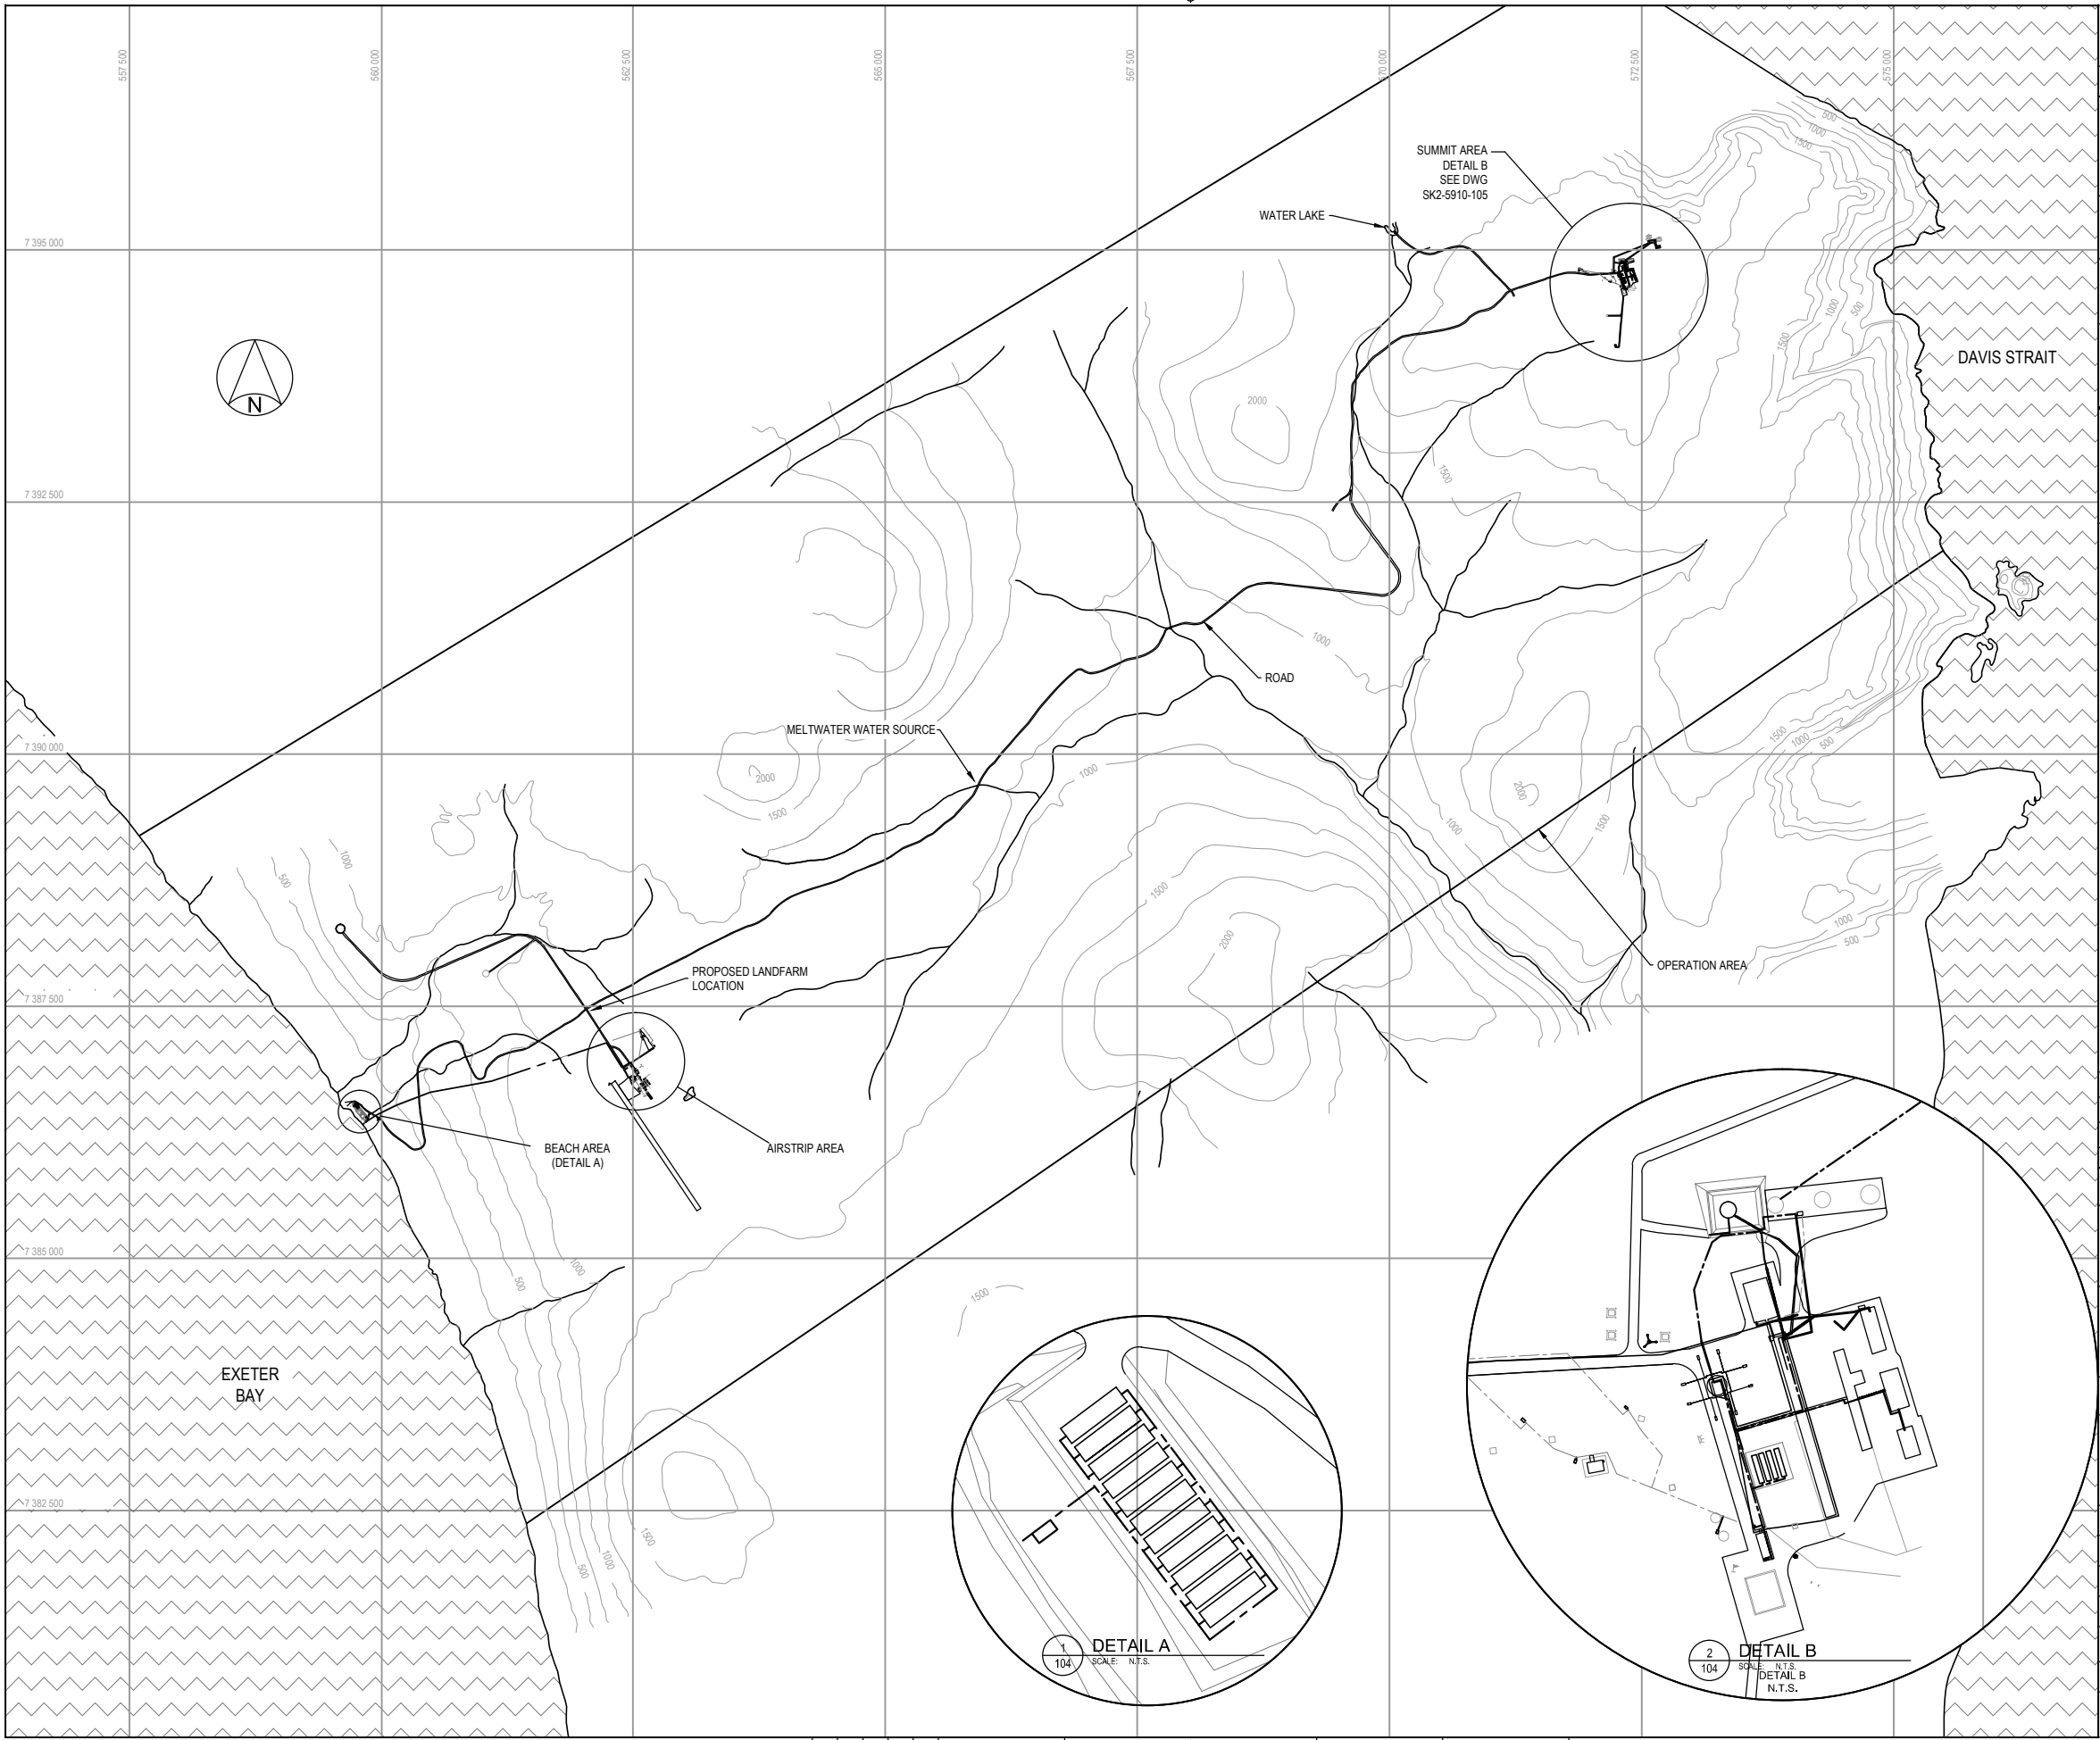



Government of Canada
Gouvernement du Canada

LEVEL OF SECURITY | NIVEAU DE SÉCURITÉ
TO BE REVIEWED | À ÊTRE RÉVISÉ

NORTH WARNING SYSTEM OFFICE
Bureau du système d'alerte du Nord



Suite 3000-400 COOPER STREET
OTTAWA, ONTARIO K2P 2H8
TEL.: (613) 787-3630
FAX.: (613) 787-3703

LOCATION



NOTES

1. PROPERTY BOUNDARIES SHOWN ARE APPROXIMATE, SEE NORTH WARNING SYSTEM REAL PROPERTY STATEMENT OF WORK DRAWING PACKAGE FOR THIS SITE'S PRECISE PROPERTY BOUNDARIES.

DRAWING DERIVED FROM PROJECT NO. 499559

NO.	DATE	REVISION	APPR.
1	10 OCT 18	REV AS PER ENVIRO. MARK-UPS	WW

SCALE | ÉCHELLE
N.T.S.

LOCATION | EMPLACEMENT
DYE-M
CAPE DYER
NUNAVUT
PROJECT | PROJET

TRADE | MÉTIER
SITING

DATE
2017/06/01

SUBJECT | SUJET

SITE PLAN

PRODUCTION	DESIGNED ÉTUDE	REVIEWED REVU	DES O AGENT CONC
A.B.			
DRAWN DESSINÉ			PROJ MGR GEST PROJ
T.R.			P.W.
CHECKED VÉRIFIÉ			DES MGR GEST CONC
M.L.			F.M.
COORDINATION			FIRE INCENDIE
			D.S.

WBS NO. | NO. OTP

PF NO. | NO. DP

DWG. NO. | NO. DESSIN
H-C75/2-5910-104

Canada


C:\Users\marginalak\Desktop\ISTS WATER BOARD\SK2-5910-10.DYE-M.dwg

Layout 1

marginalak

2018 Oct 17, 10:58am

Sheet # of #

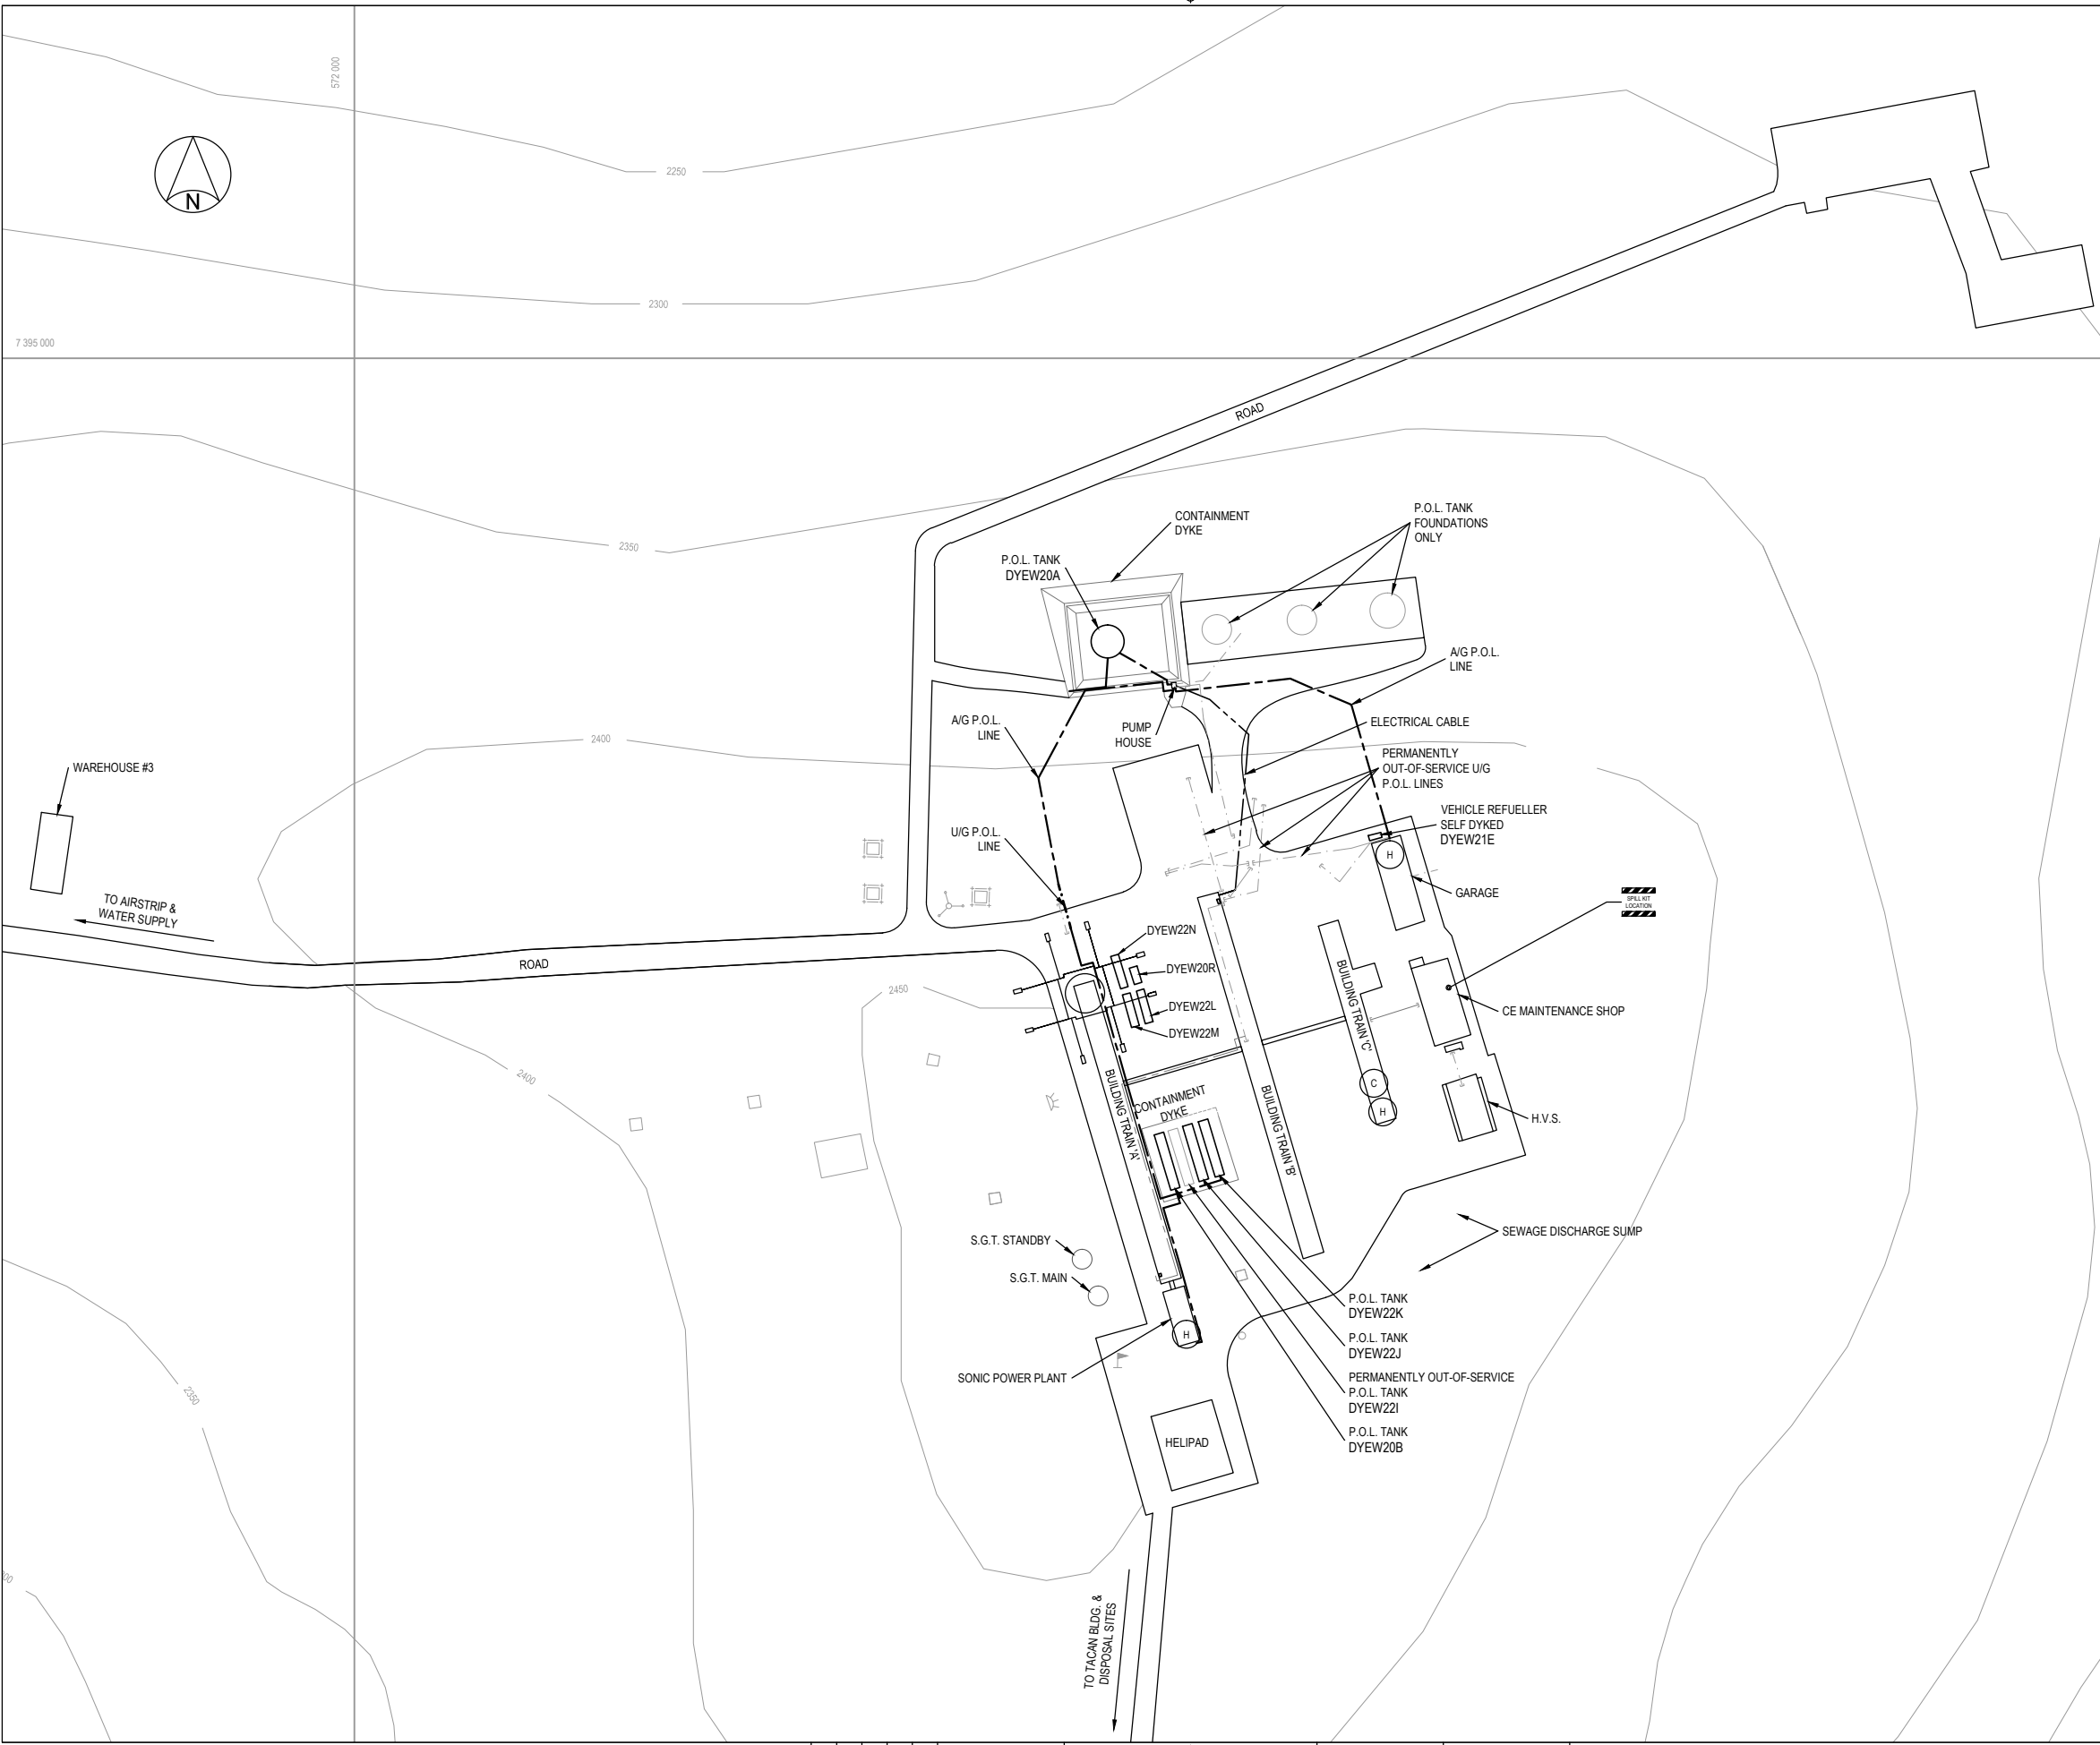



Government of Canada
Gouvernement du Canada

LEVEL OF SECURITY | NIVEAU DE SÉCURITÉ
TO BE REVIEWED | À ÊTRE RÉVISÉ

NORTH WARNING SYSTEM OFFICE
Bureau du système d'alerte du Nord

Raytheon
Canada Limited

Suite 3000-400 COOPER STREET
OTTAWA, ONTARIO K2P 2P8
TEL.: (613) 787-3630
FAX.: (613) 787-3703

LOCATION



NOTES:

--- ABOVEGROUND P.O.L. LINE

--- UNDERGROUND P.O.L. LINE

--- ELECTRICAL CABLE

 P.O.L. SPILL KIT

 HAZMAT STORAGE

 CHEMICAL SPILL KIT

DRAWING DERIVED FROM PROJECT NO. 499559

NO.	DATE	REVISION	APPR.
1	10 OCT 18	REV AS PER ENVIRO. MARK-UPS	WW

SCALE | ÉCHELLE
N.T.S.

LOCATION | EMPLACEMENT
DYE-M
CAPE DYER
NUNAVUT

PROJECT | PROJET

TRADE | MÉTIER
SITING

DATE
2017/06/01

SUBJECT | SUJET
SUMMIT AREA PLAN

PRODUCTION
DESIGNED | ÉTUDIÉ

REVIEWED | REVU

DES O | AGENT CONC.

A.B.

PROJ MGR | GEST PROJ

T.R.

P.W.

CHECKED | VÉRIFIÉ

DES MGR | GEST CONC

M.L.

F.M.

COORDINATION

FIRE | INCENDIE

D.S.

WBS NO. | NO. OTP

PF NO. | NO. DP

DWG. NO. | NO. DESSIN

H-C75/2-5910-105

Canada

Sheet # of #

2018 Oct 17, 10:58am

margin: 10mm

C:\Users\mangyn\OneDrive\Documents\WATER BOARD\SC-5910_105\DYEM.dwg

Layout 1