


H-D67/2-8400-101

FOX-3

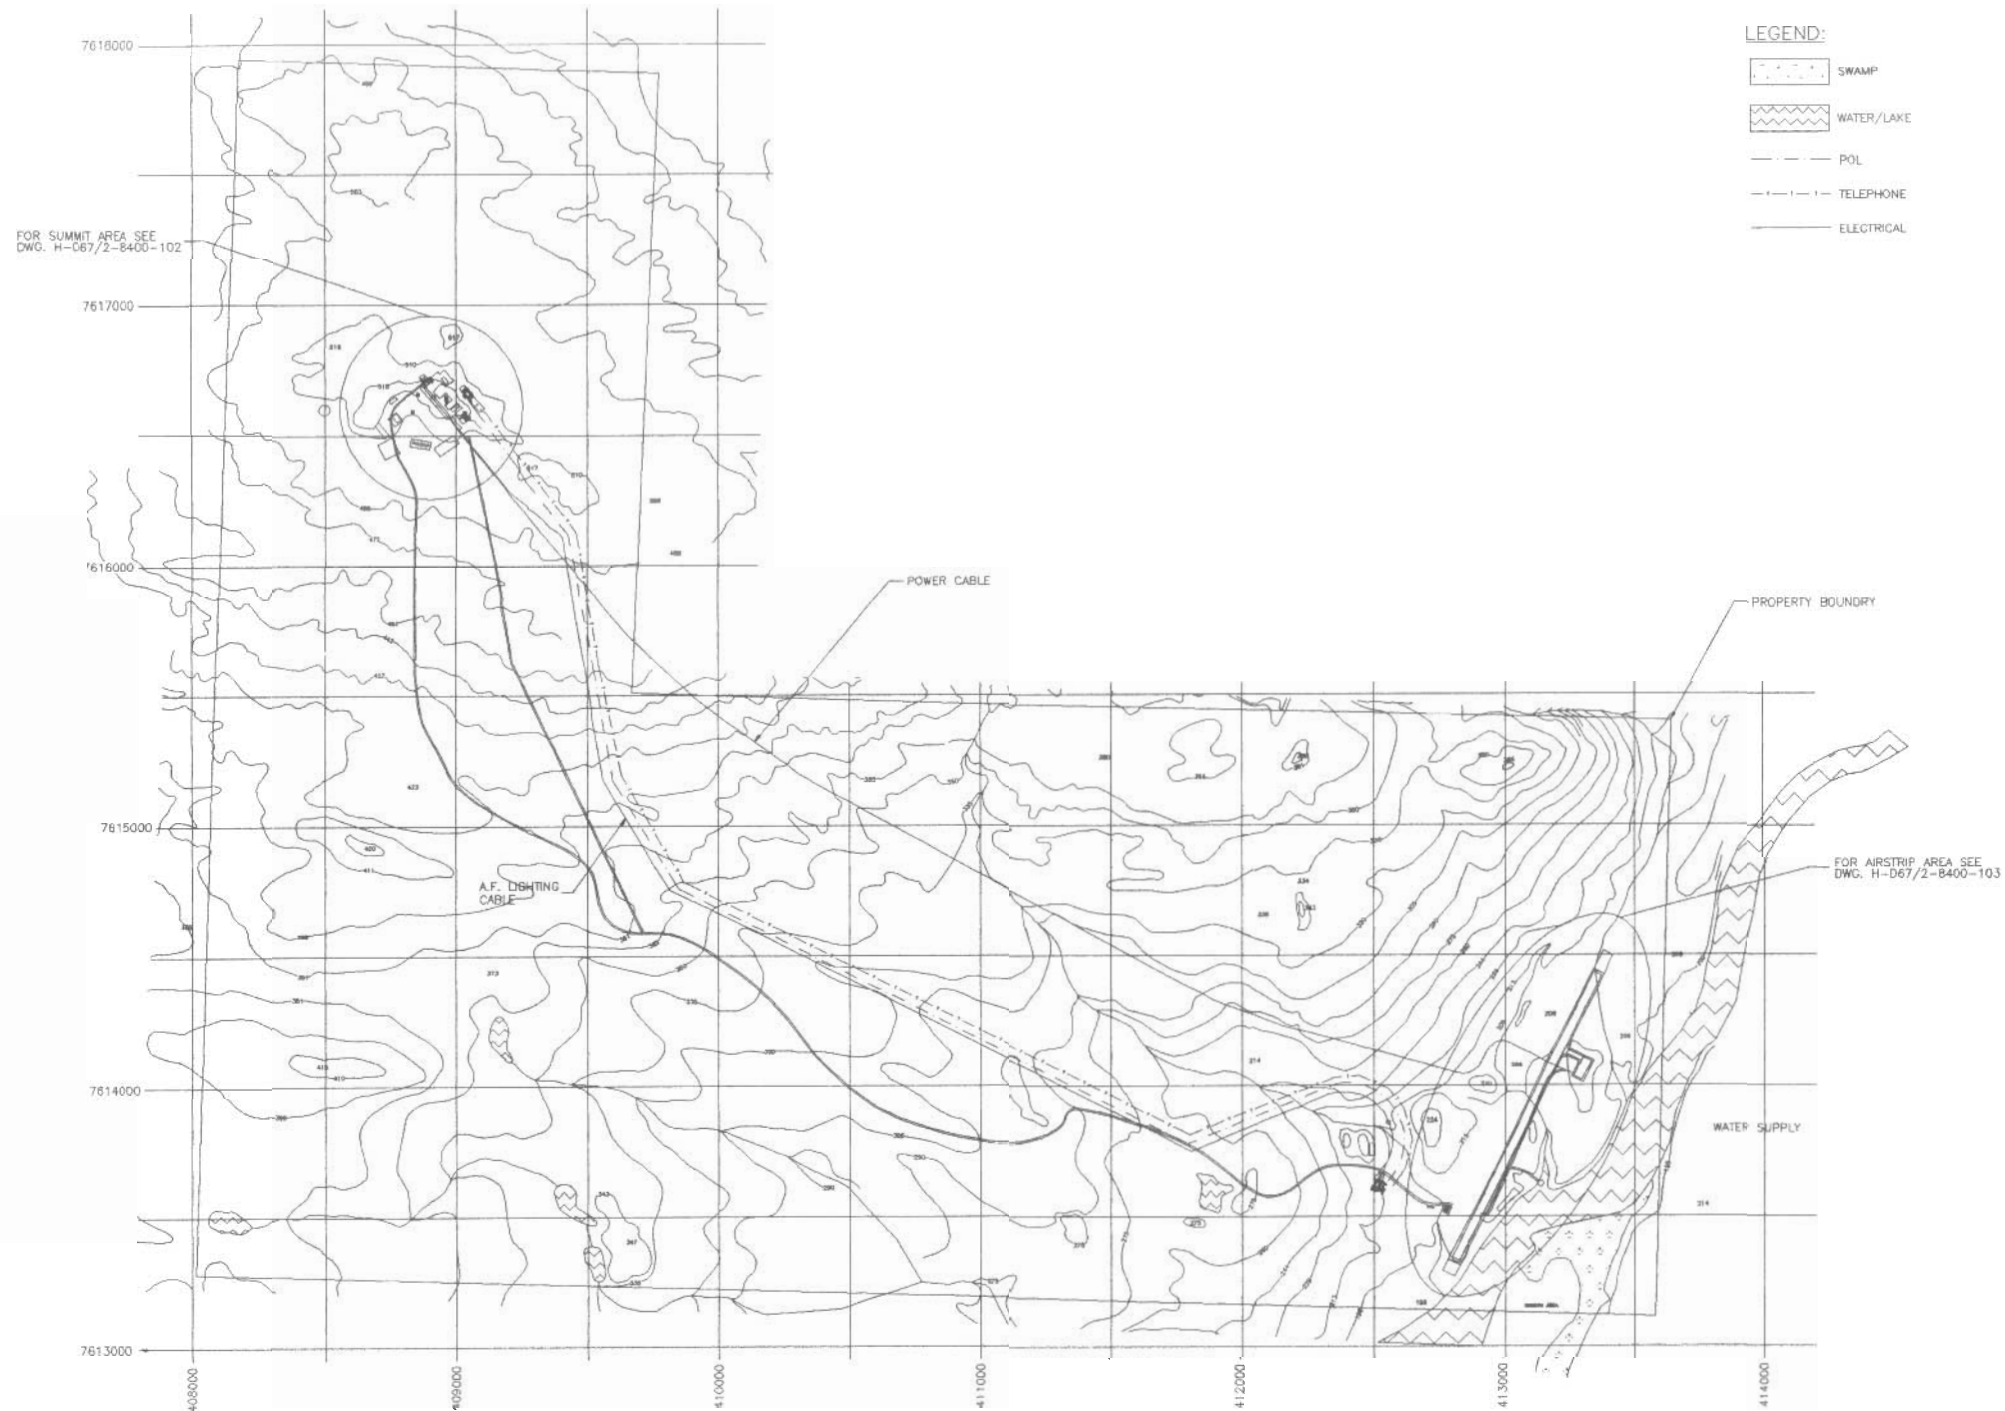

LEGEND:

- SWAMP
- WATER/LAKE
- POL
- TELEPHONE
- ELECTRICAL



NORTH WARNING SYSTEM OFFICE
Bureau du système d'alerte du Nord



ATCO Frontec
100-170 LAUREL AVE. WEST
OTTAWA, ONTARIO K1P 0V5
TEL: (613) 234-4568
FAX: (613) 234-5678

NOTES:

1. CONTOURS ARE IN METERS.

REDUCED DRAWING FOR
INFORMATION ONLY
SCALE IS REPRESENTATIVE
OF FULL SIZE DRAWING.

No.	DATE	REVISION	REVISION	DRN	APPR.

SITE RECORD DRAWING



SCALE - ÉCHELLE

1:10000

PROJECT - PROJET
CM-66431

LONG RANGE RADAR SITE

FOX-3

DEWAR LAKES NUNAVUT

TRADE - MÉTIER SITING DATE 06 MAR 02

SUBJECT - SUJET


SITE PLAN

PRODUCTION	CONCURRENCE - ASSENTIMENT	
DESIGNED ÉTUDE	FIRE MARSHAL	PROVOT DU SERVILE DES INCENDIES
DRAWN DESSIN	F.P.	
CHECKED VÉRIFIÉ	T.R.	
COORDINATION	INVS FACILITIES ENGINEER	OFFICIER DU GENIE BSAN GENIE DES INSTALLATIONS BSAN
DWG. NO. - DESSIN NO. H-D67/2-8400-101		

Canada

H-D67/2-8400-102

FOX-3

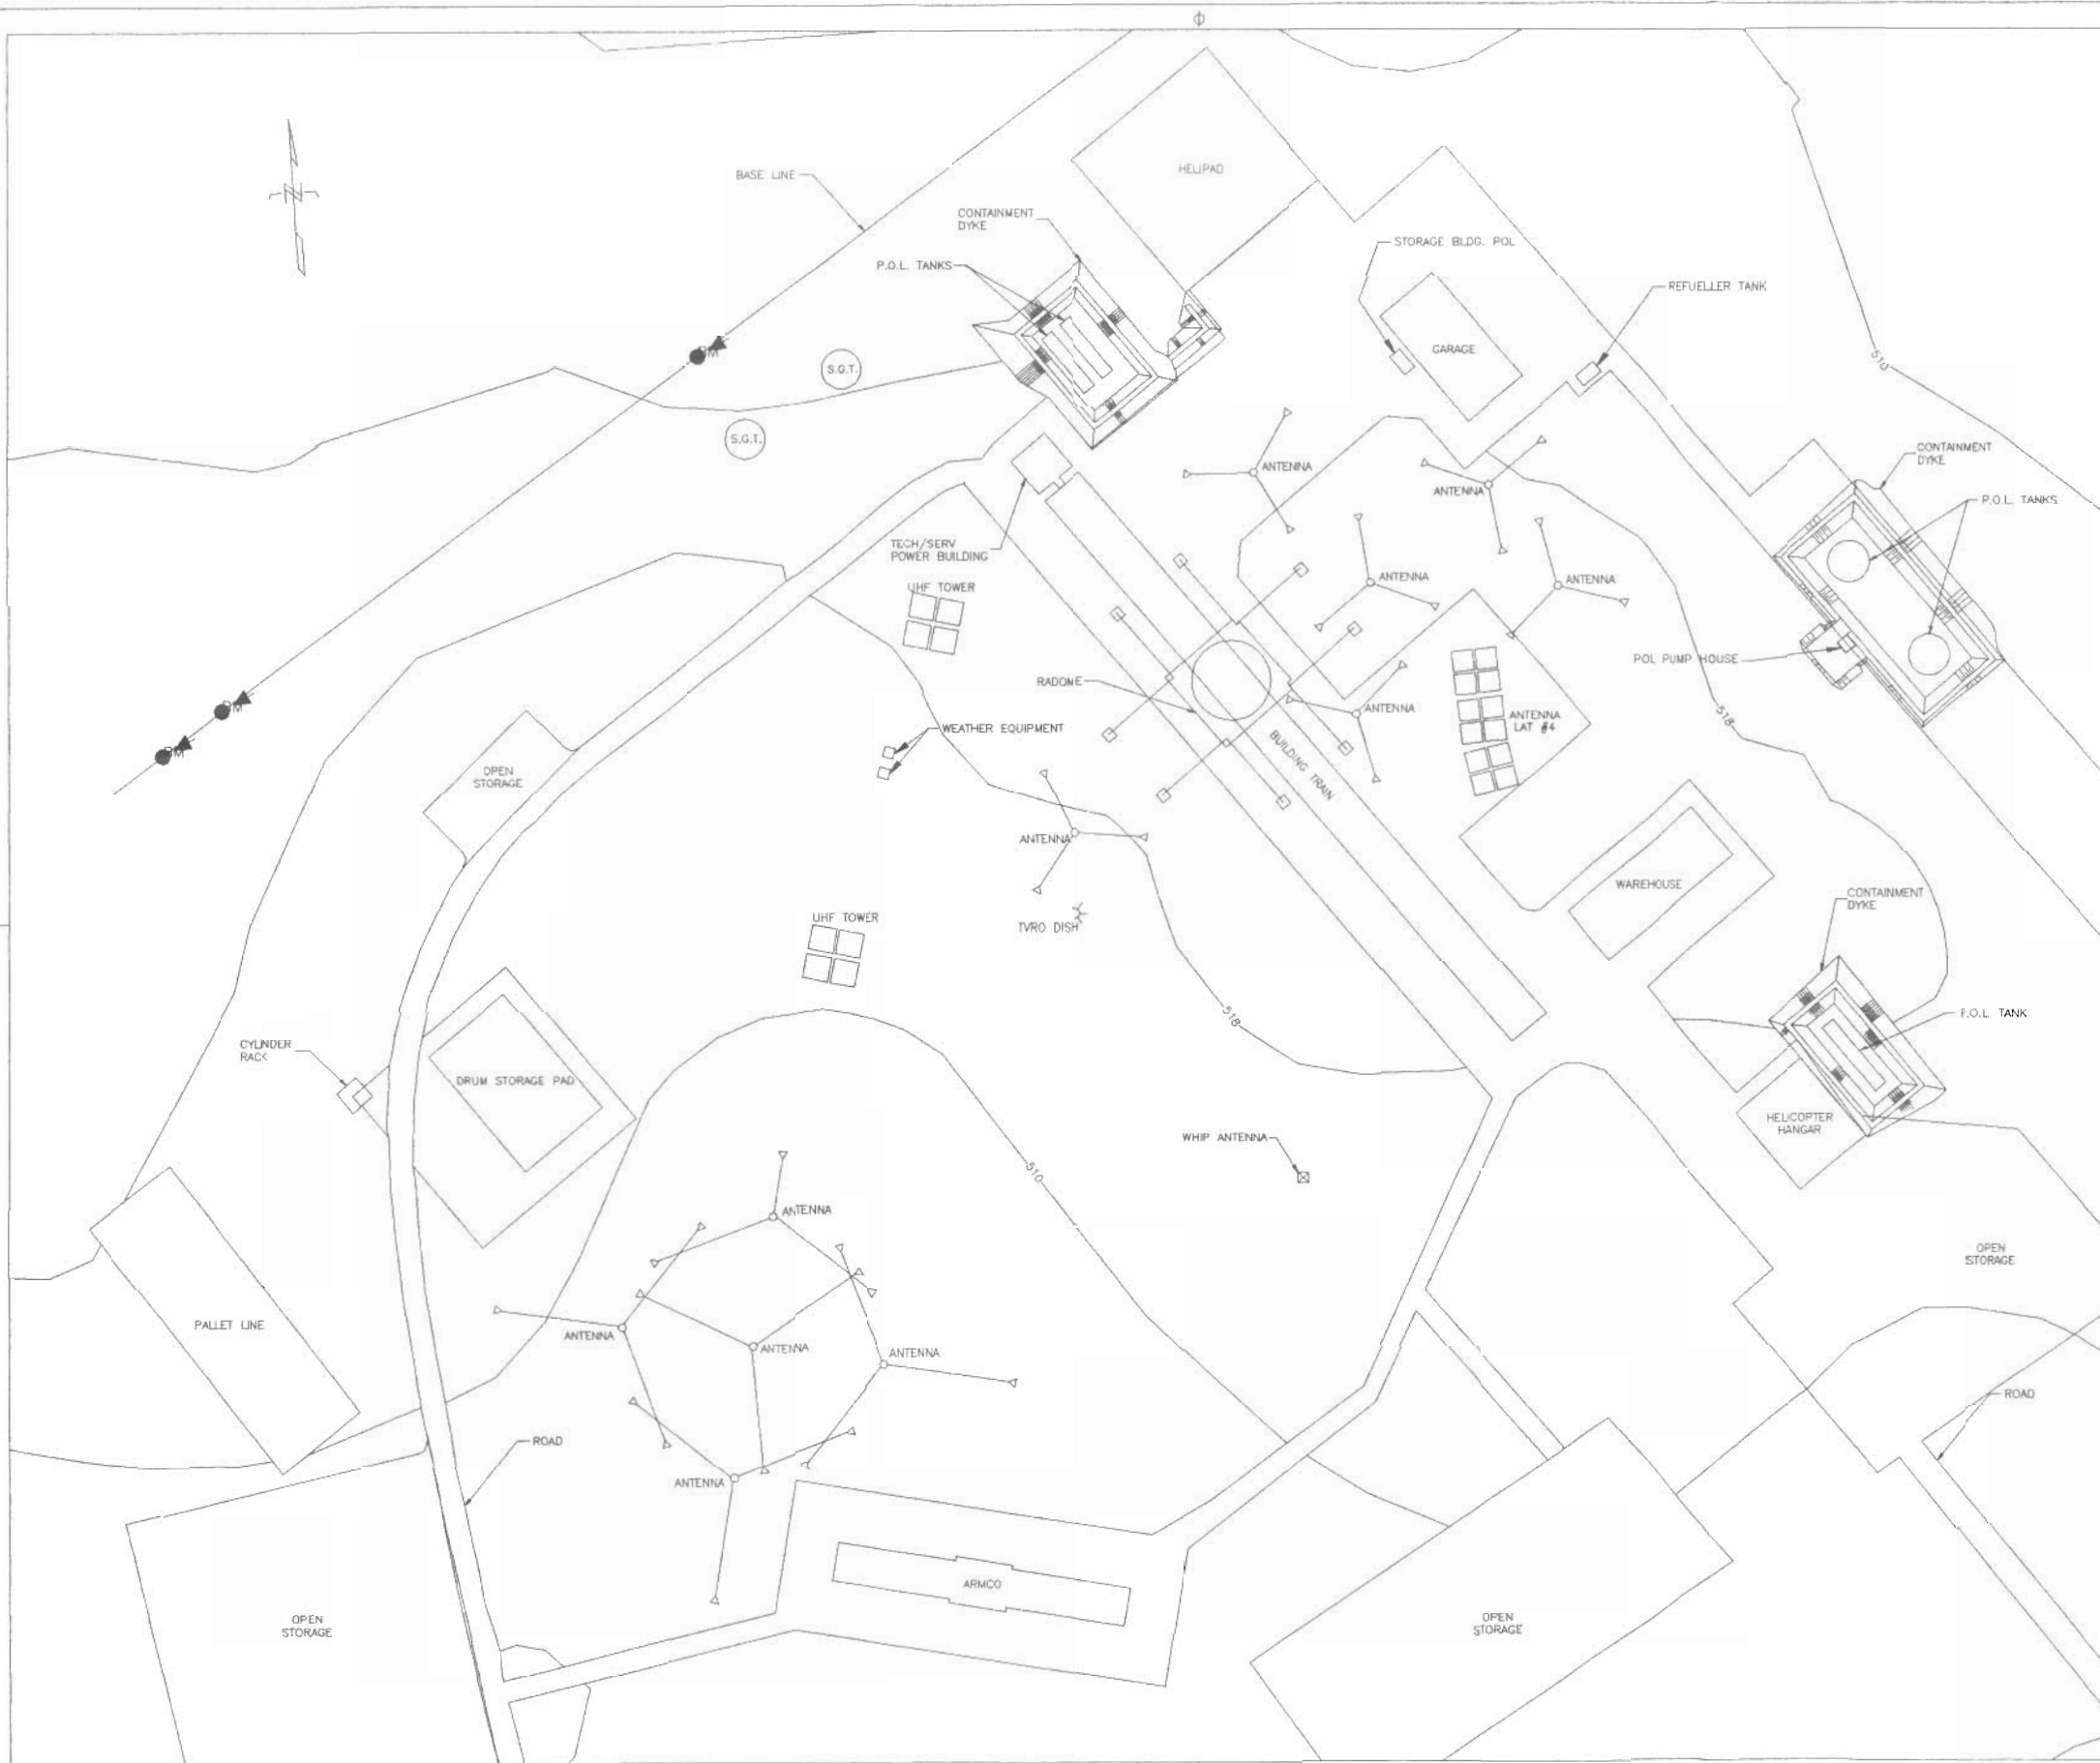

NORTH WARNING SYSTEM OFFICE
Bureau du système d'alerte du Nord



ATCO Frontec
100-170 LAURENCE AVE. WEST
OTTAWA, ONTARIO K1P 8Y5
TEL: (613) 234-6666
FAX: (613) 234-5888

NOTES:
1. CONTOURS ARE IN METERS.

REDUCED DRAWING FOR
INFORMATION ONLY
SCALE IS REPRESENTATIVE
OF FULL SIZE DRAWING.

NO.	DATE	REVISION	REVISION	DRN	APPR
-----	------	----------	----------	-----	------

SITE RECORD DRAWING



SCALE - ÉCHELLE
1:500

PROJECT - PROJET
CM-66431

LONG RANGE RADAR SITE

FOX-3

DEWAR LAKES NUNAVUT


TRADE - MÉTIER SITING DATE 06 MAR 02

SUBJECT - SUJET
SUMMIT
AREA PLAN

PRODUCTION	CONCURRENCE - ASSENTIMENT
DESIGNED ETUDIE	FIRE MARSHAL
DRAWN Dessin	F.P.
CHECKED VÉRIFIÉ	T.R.
COORDINATION	ENGINEERING OFFICER
	GENIC DES INSTALLATIONS
	GENIC DES INSTALLATIONS

Canada

FOX-3

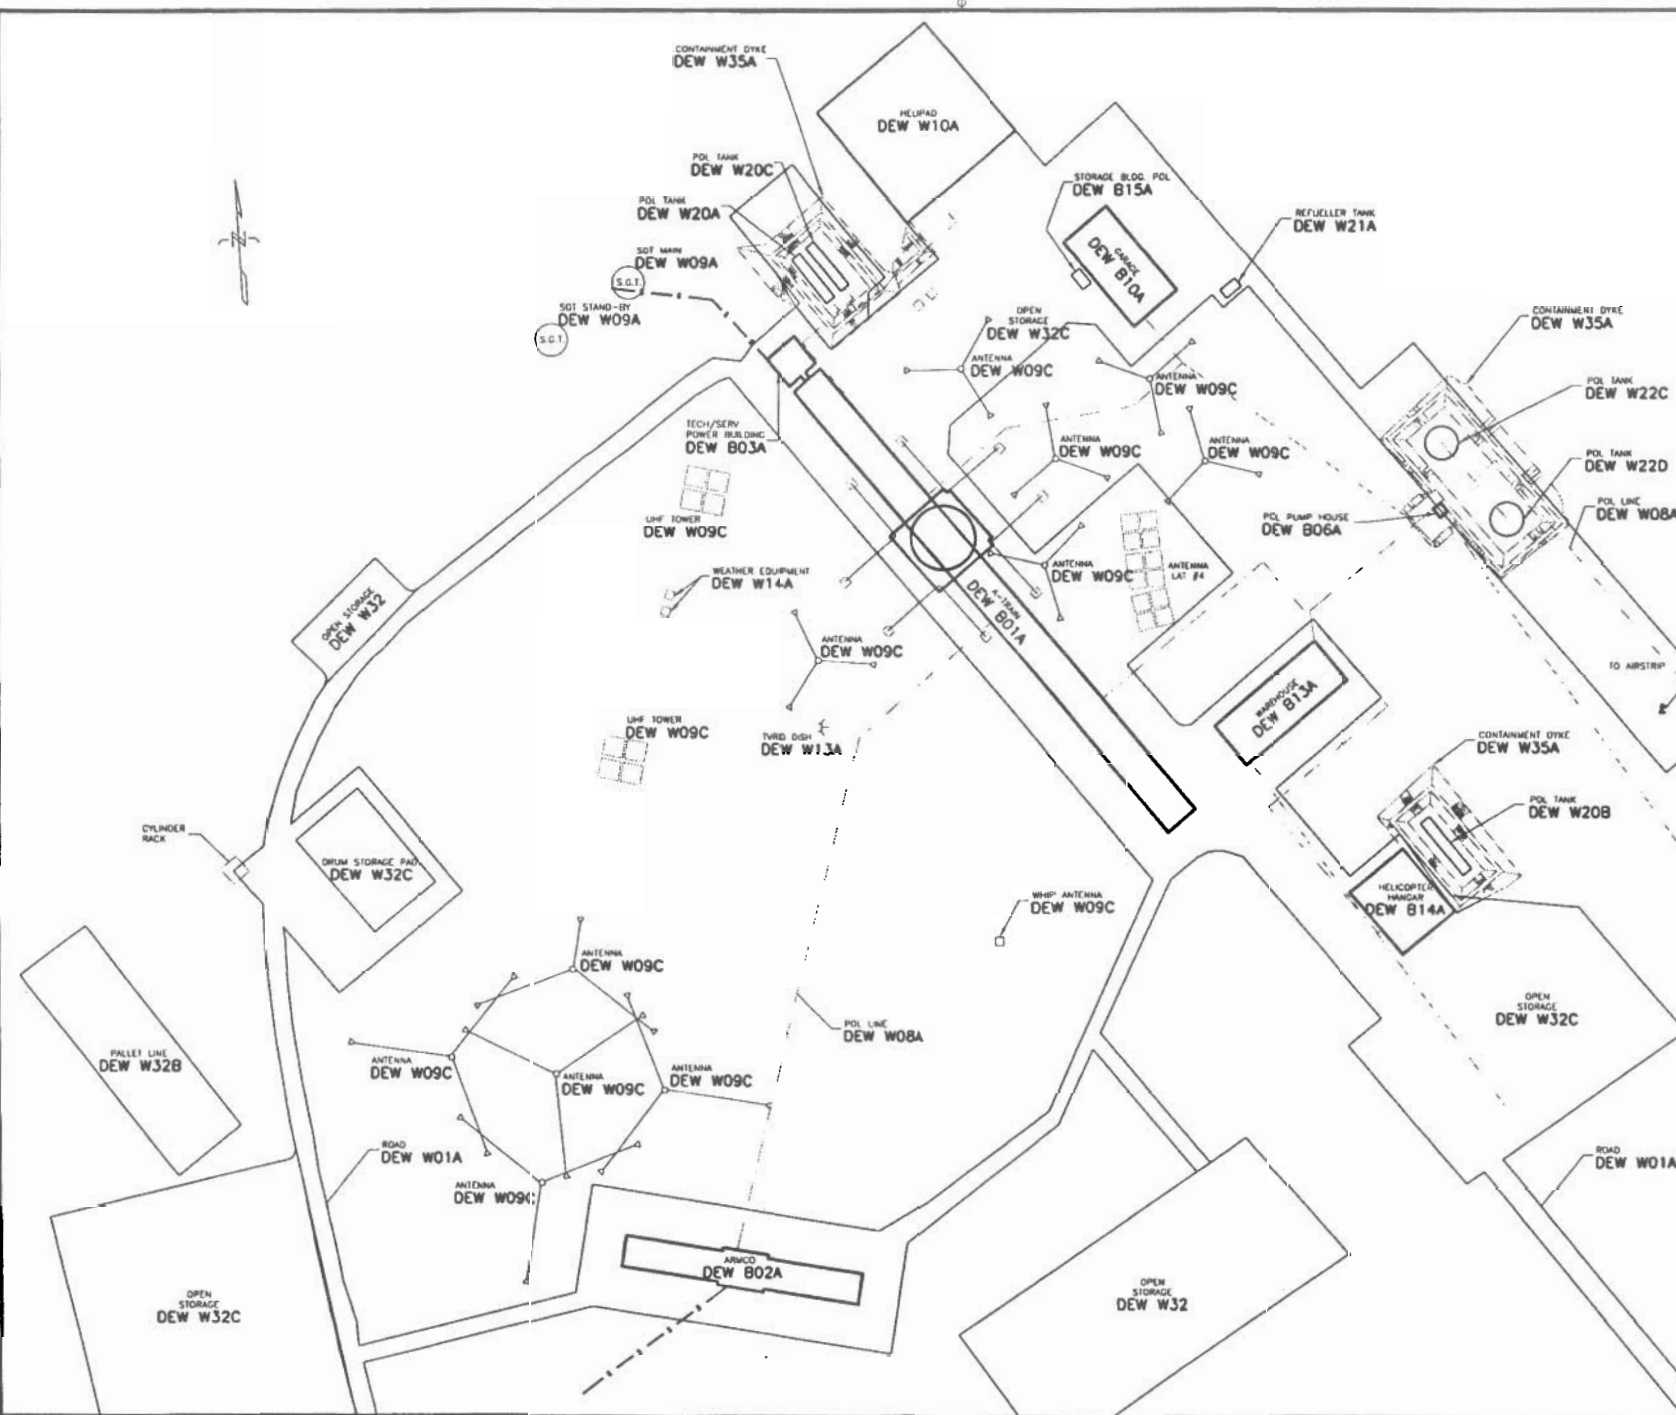


REDUCED DRAWING FOR
INFORMATION ONLY

SCALE IS REPRESENTATIVE
OF FULL SIZE DRAWING.

No.	DATE	REVISION	REVISION	DRAWN BY
SITE RECORD DRAWING				
1:500				
PROJECT - PROJECT				
CM-66431				
LONG RANGE RADAR SITE				
FOX-3				
DEBAR LAKES				NUMA/UT
TYPICAL SECTION				DATE
SITING				06 MAR 82
SUBJECT - SUBJECT				
SUMMIT				
LOCID PLAN				
PRELIMINARY		CONFORMANCE - ATTENTION		
DESIGNED THRU BY DATE F.P.	FILE MARSHAL	PROJECT BU (G.M.) BY DATE		
CHECKED BY DATE T.S.	INSTR ENGINEERING OFFICE BY DATE INSTR ENGINEERING OFFICE	OFFICE BU (G.M.) BY DATE INSTR ENGINEERING OFFICE		
H-6672-8400-104				
Canada				

H-D67/2-8400-105

FOX-3

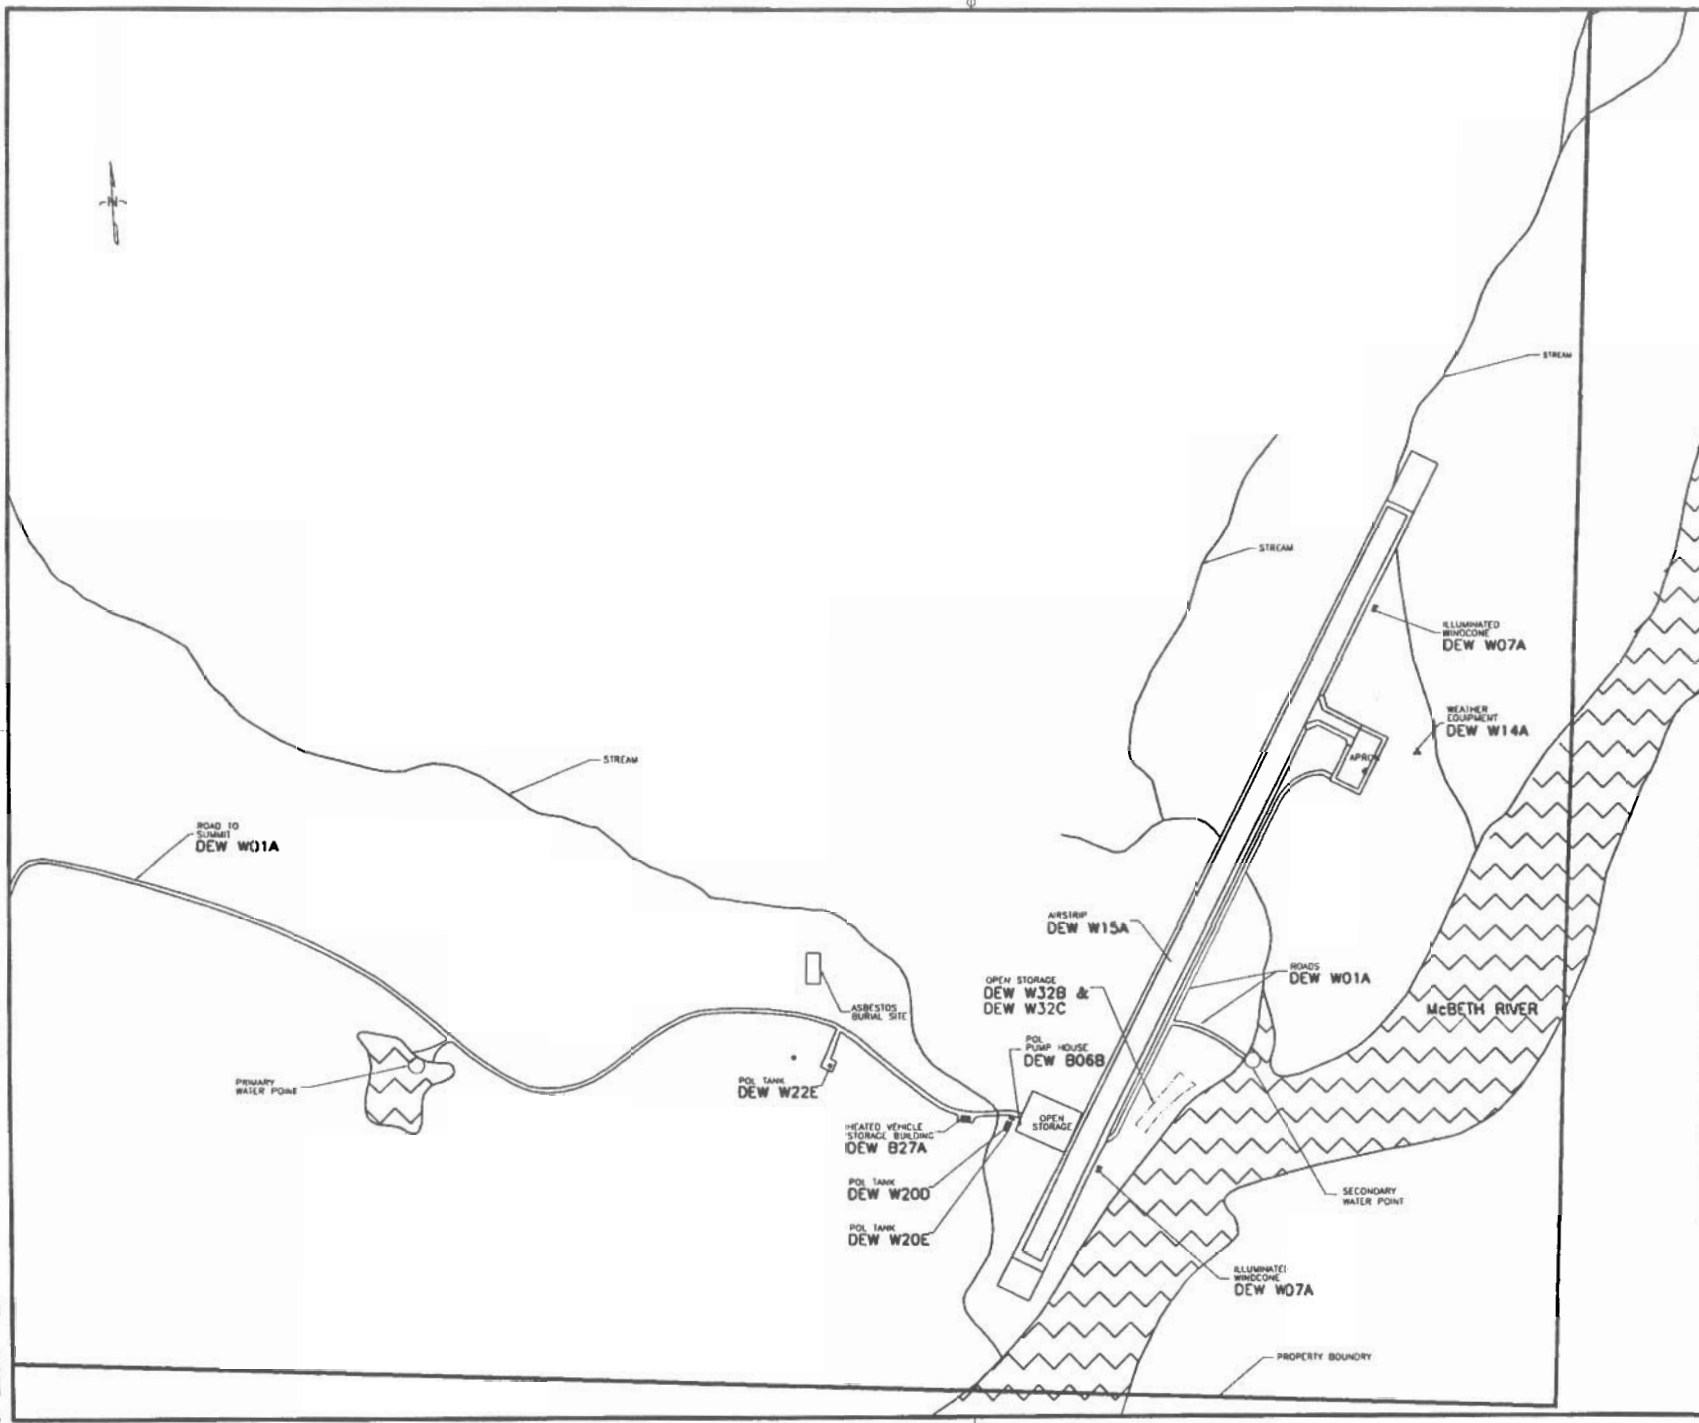

		National Defence Défense nationale	
NORTH WARNING SYSTEM OFFICE Bureau du système d'alerte du Nord			
LOCATION 			
ATCO <i>Protections</i>			
NOTES: 1. CONTOURS ARE IN METERS.			
LEGEND: WATER/LAKE			
REDUCED DRAWING FOR INFORMATION ONLY SCALE IS REPRESENTATIVE OF FULL SIZE DRAWING.			
NO.	DATE	REVISION	BY
SITE RECORD DRAWING			
0 60 120 180 240 300 metres SCALE - ÉCHELLE 1:3000			
PROJECT - PROJET CH-66431 LONG RANGE RADAR SITE			
FOX-3			
DEWAR LAKES TRADE - MÉTIER SITING		HUMANITY DATE 00 MAR 82	
SUBJECT - SUJET AIRSTRIP LOCID PLAN			
PRODUCTION DESIGNED CHECKED DRAWN REVISION T.P.		CONCURRENCE - ASSÉNTIMENT FIVE HANDED SERVICE DESIGNS T.R. ENGINEERING OFFICE H-67/2-8400-105 BESSIN NO H-67/2-8400-105	
Canada			