


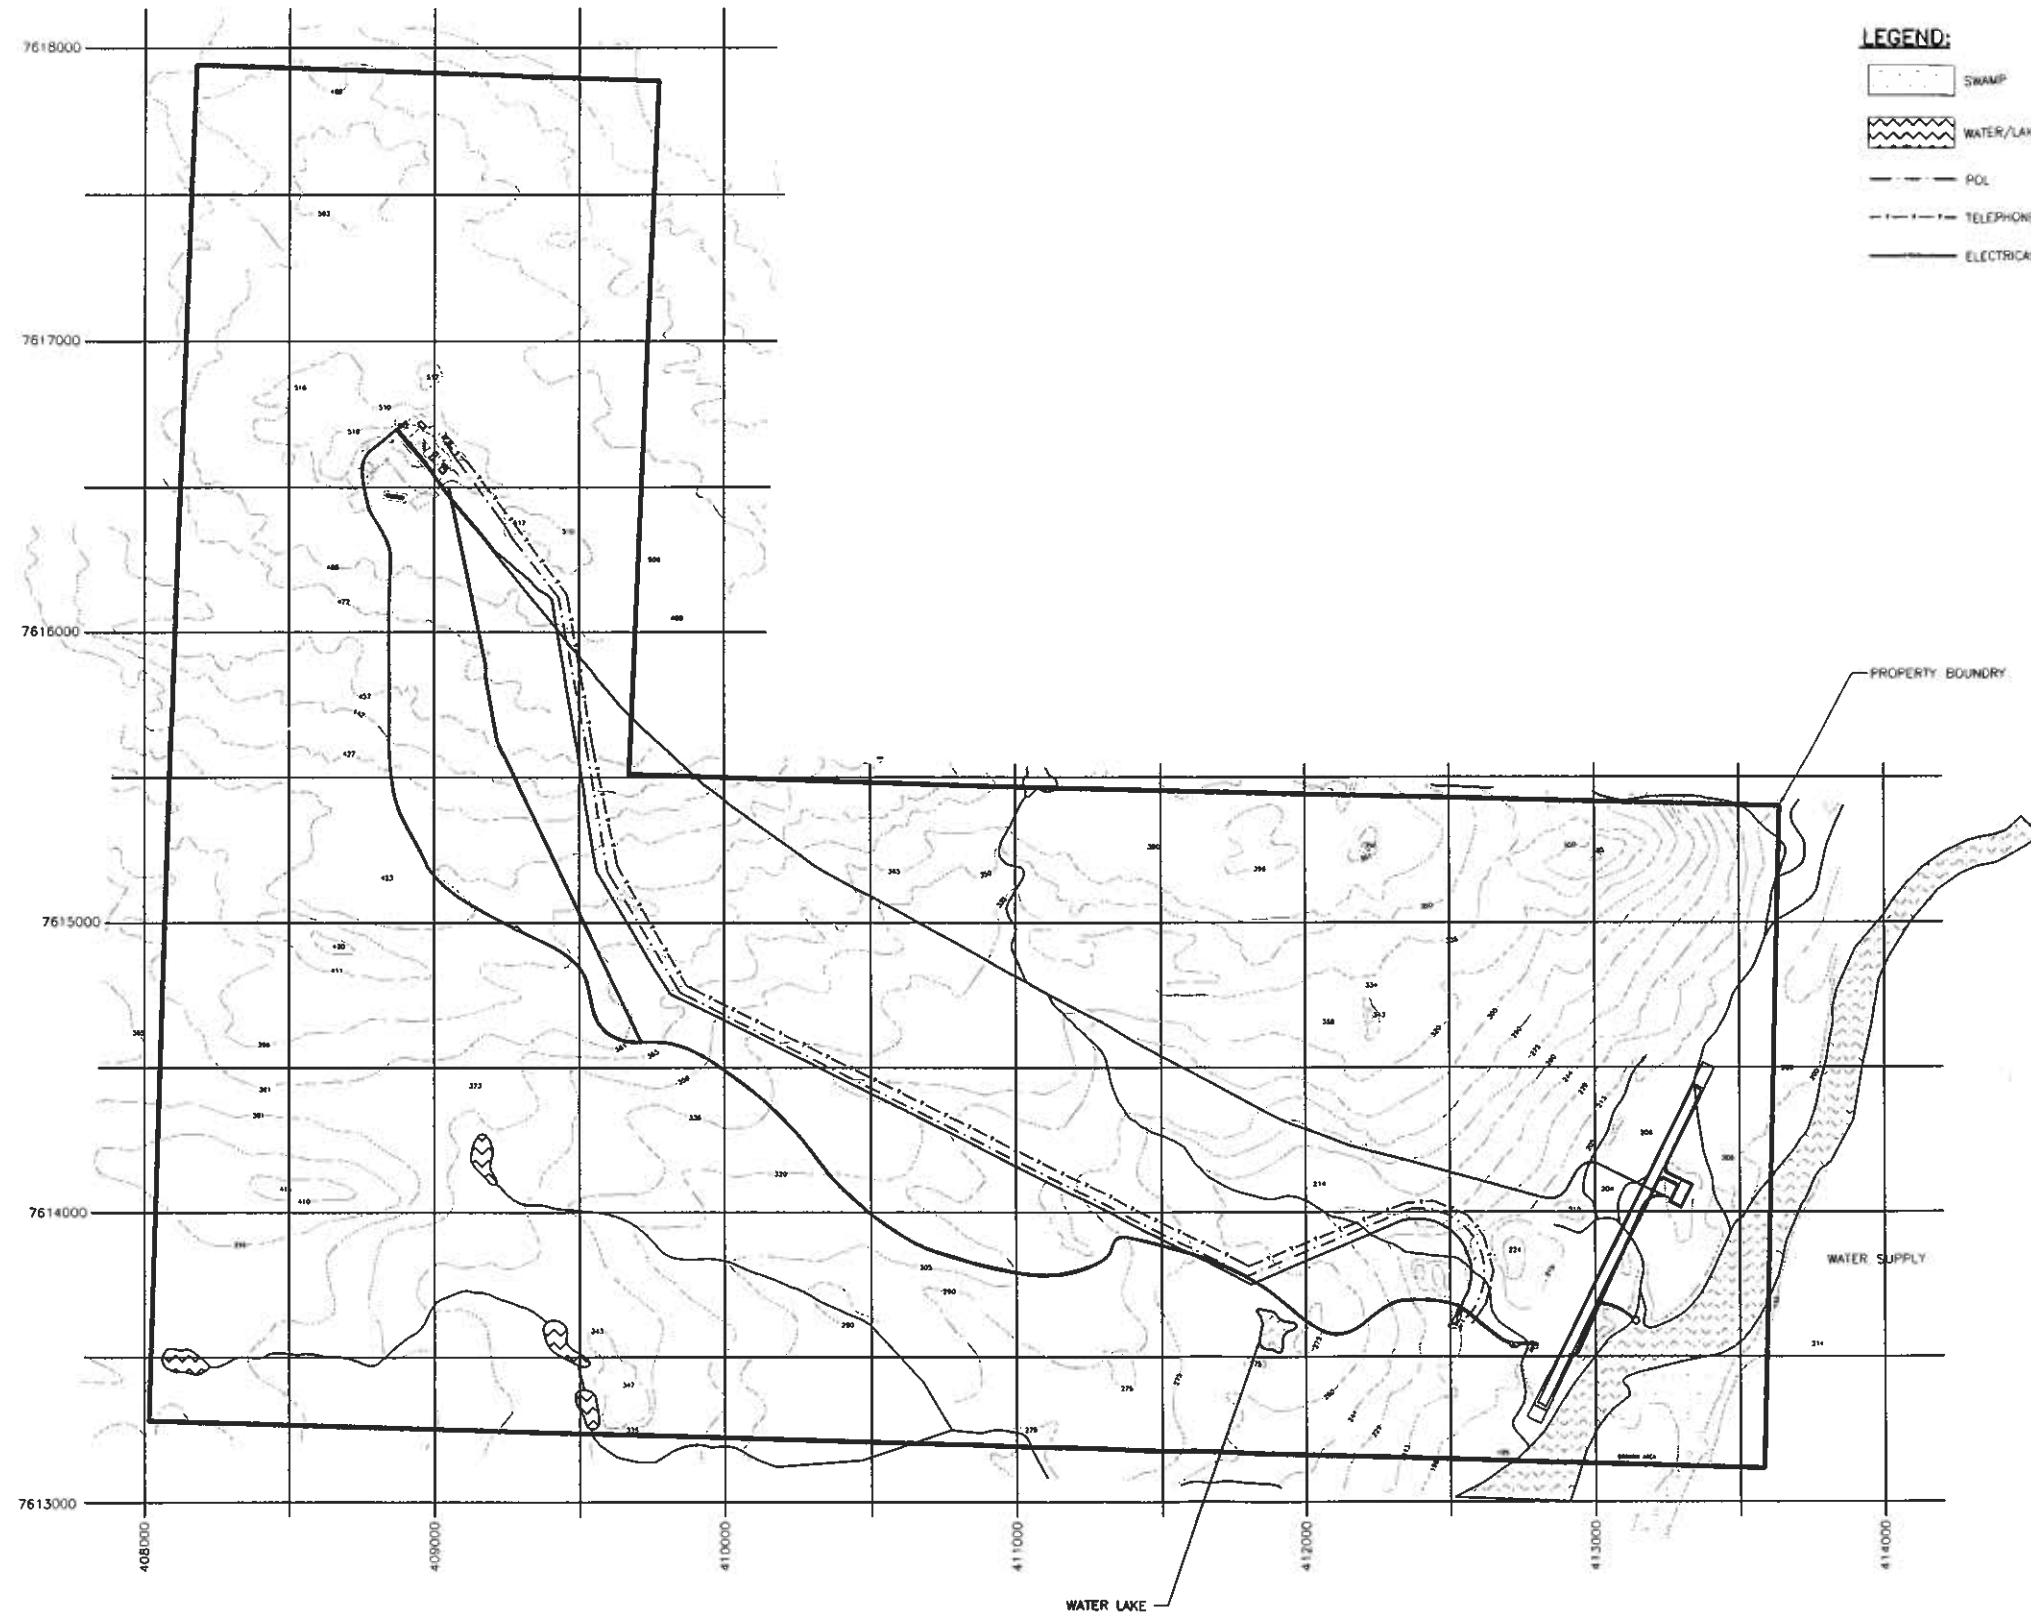

NOTES:

1. CONTOURS ARE IN METERS.
2. NASITTUQ HAS CARE CUSTODY OF ENTIRE PARCEL.

REDUCED DRAWING FOR
INFORMATION ONLY

SCALE IS REPRESENTATIVE
OF FULL SIZE DRAWING.

1	13 JUN 06	REV AS PER REDLINES	F.P.
No.	DATE	REVISION	CRN. APPR.

SITE RECORD DRAWING

0 200 400 600 800 1000 metres

SCALE - ÉCHELLE

1:10000

PROJECT - PROJET

CM-66431

LONG RANGE RADAR SITE

FOX-3

DEWAR LAKES

NUNAVUT

TRADE - MÉTIER

SITING

DATE 06 MAR 02

SUBJECT - SUJET

SITE PLAN

DESIGNED ÉTUDE	FIRE MARSHAL	PREV'D DU SERVICE DES INCENDIES
DRAWN Dessin	F.P.	
CHECKED VÉRIFIÉ	T.R.	ENGINEERING OFFICER BSAN
COORDINATION	ENGINEER	INSTALLATIONS BSAN

H-D67/2-8400-101

Canada