


H-D67/2-8400-101

FOX-3

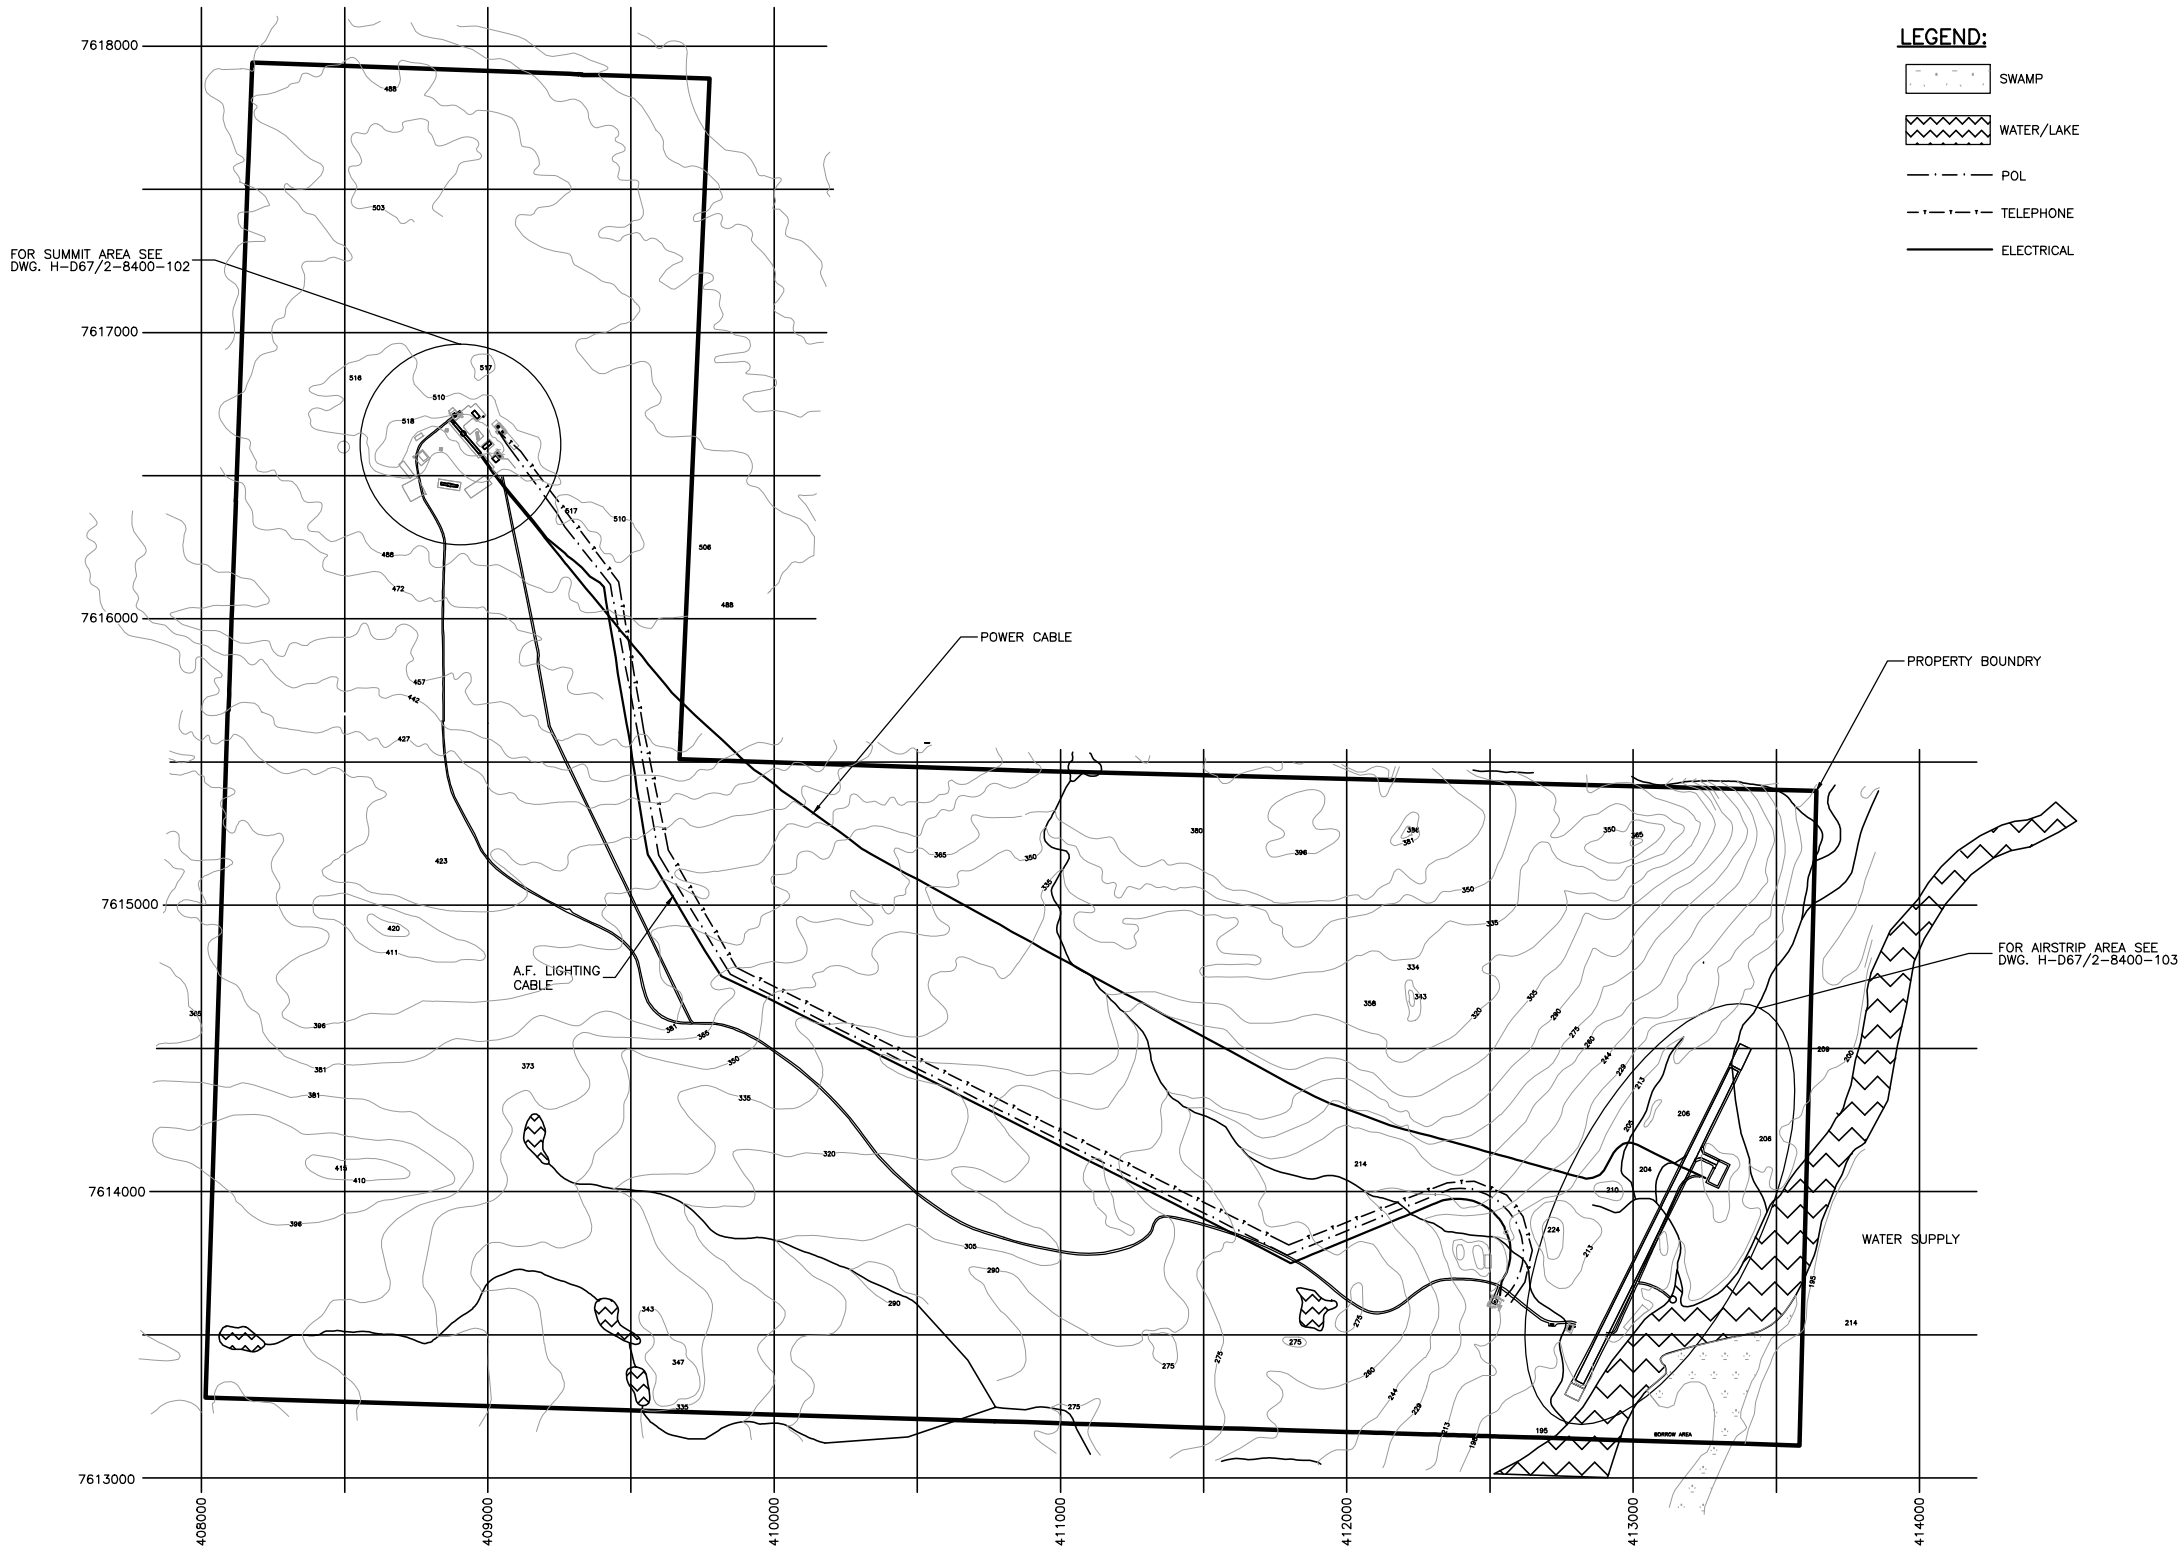


- NOTES:**
1. CONTOURS ARE IN METERS.
 2. NASITTUQ HAS CARE CUSTODY OF ENTIRE PARCEL.

REDUCED DRAWING FOR
INFORMATION ONLY

SCALE IS REPRESENTATIVE
OF FULL SIZE DRAWING.

1	13 JUN 06	REV AS PER REDLINES	F.P.
No.	DATE	REVISION	DRN APPR

 SITE RECORD DRAWING



SCALE - ÉCHELLE
1:10000

PROJECT - PROJET
CM-66431

LONG RANGE RADAR SITE

FOX-3

DEWAR LAKES NUNAVUT
TRADE - MÉTIER SITING DATE 06 MAR 02

SUBJECT - SUJET

SITE PLAN

PRODUCTION	CONCURRENCE - ASSENTIMENT	
DESIGNED ÉTUDIÉ	FIRE MARSHAL	PRÉVOT DU SERVICE DES INCENDIES
DRAWN DESSINÉ	F.P.	
CHECKED VÉRIFIÉ	T.R.	NWSD ENGINEERING OFFICER DU GENIE BSAN
COORDINATION	NWSD FACILITIES ENGINEER	GENIE DES INSTALLATIONS BSAN

DWG. NO. DESSIN NO.
H-D67/2-8400-101