


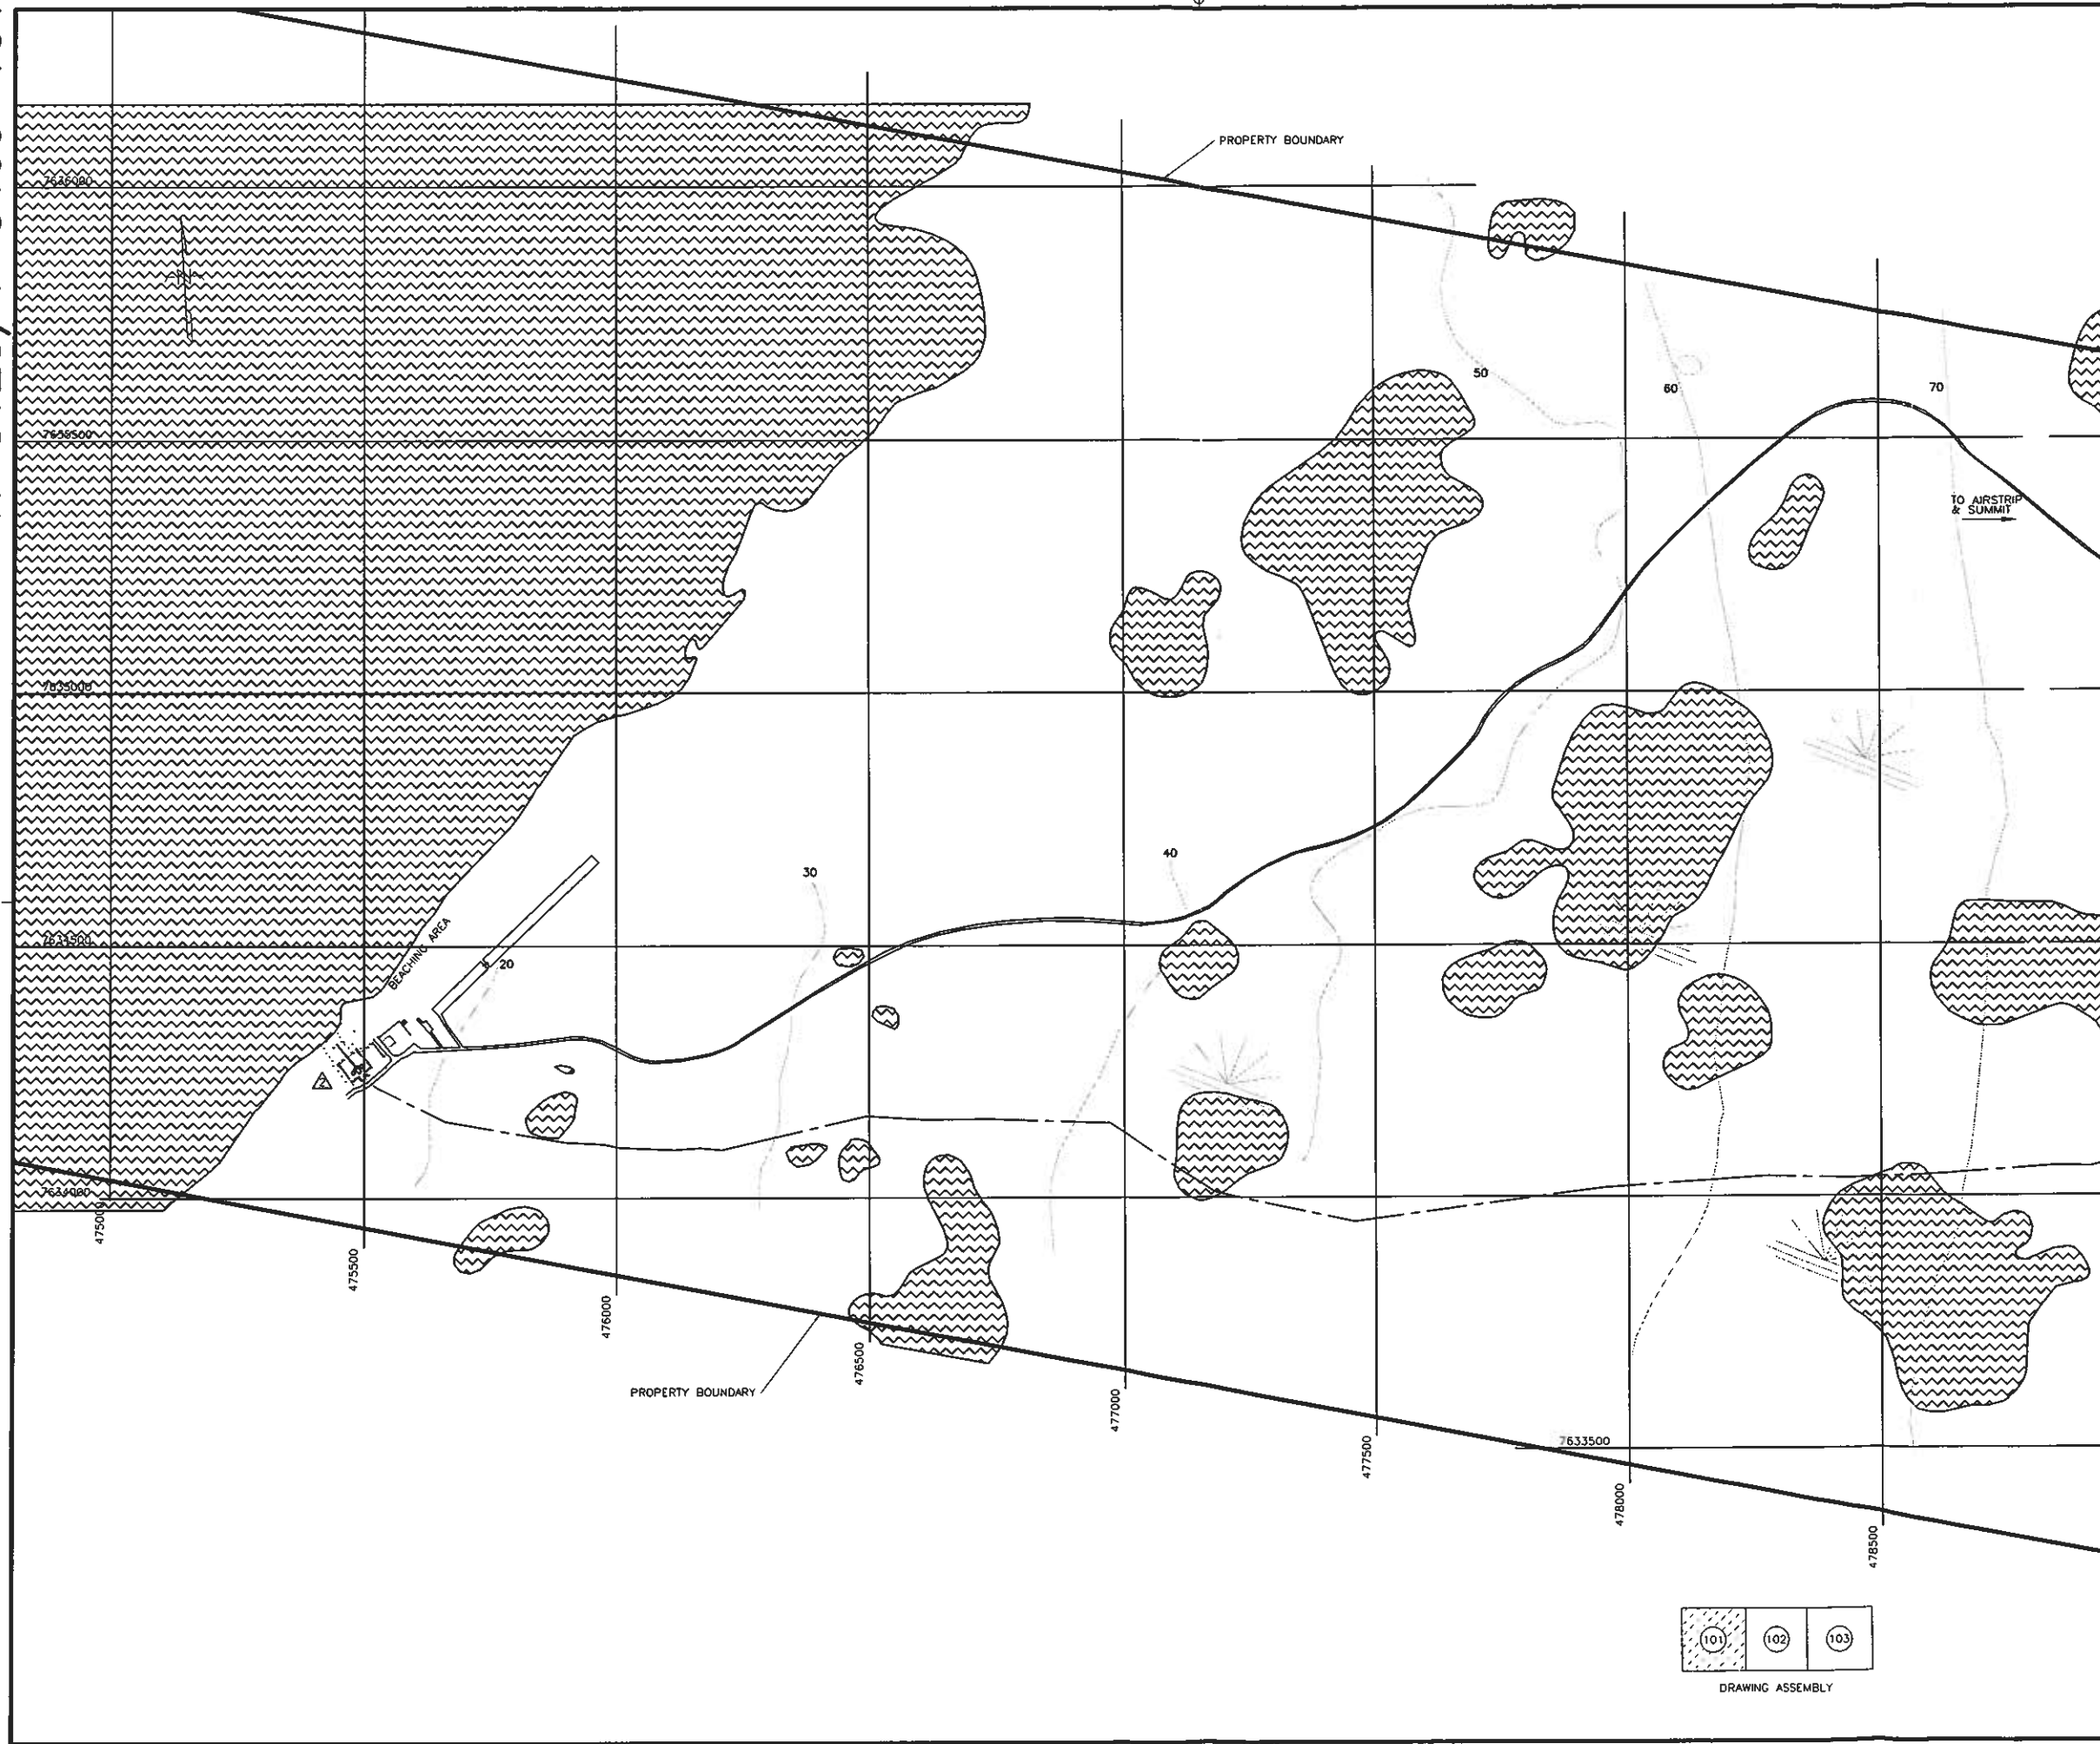



National Defence
Défense nationale

NORTH WARNING SYSTEM OFFICE
Bureau du système d'alerte du Nord

LOCATION

CAM-3



100-170 LAURIER AVE. WEST
OTTAWA, ONTARIO K1P 5V5
TEL: (613) 234-9033
FAX: (613) 234-3886

 
NOTES:
1. NASITTUQ HAS CARE CUSTODY OF ENTIRE PARCEL.
2. CONTOURS ARE IN FEET

LEGEND:
 WATER
 POL LINE
 APPROXIMATE LOCATION OF SWAMPY AREAS
 GRAVEL ROADWAY
NO DATA AVAILABLE FOR CONSTRUCTION OF WIND ROSE INFORMATION.

REDUCED DRAWING FOR INFORMATION ONLY
SCALE IS REPRESENTATIVE OF FULL SIZE DRAWING.

2	31 MAR 07	REV AS PER REDLINES	J.G.
1	13 JUN 06	REV AS PER REDLINES	F.P.
No.	DATE	REVISION	DRN. APPR.

SITE RECORD DRAWING


SCALE - ECHELLE
1 : 5000

PROJECT - PROJET
CM-66272
LONG RANGE RADAR SITE
CAM-3

SHEPHERD BAY
TRADE - MÉTIER
SITING
DATE
21 JAN 02
NUNAVUT

SUBJECT - SUJET
SITE PLAN

PRODUCTION	CONCURRENCE - ASSENTIMENT
DESIGNED ÉTUDE K.R.	FIRE MARSHAL PRÉVOT DU SERVISE DES INCENDIES
DRAWN DESSINÉ T.R.	ENGINEERING OFFICER OFFICIER DU GÉNIE DESAN
CHECKED VÉRIFIÉ T.R.	ENGINEERING OFFICER OFFICIER DU GÉNIE DESAN
COORDINATION	ENGINEERING OFFICER OFFICIER DU GÉNIE DESAN

DWG. NO. - DESSIN NO.
H-S123/1-8400-101

Canada

(101) (102) (103)
DRAWING ASSEMBLY